




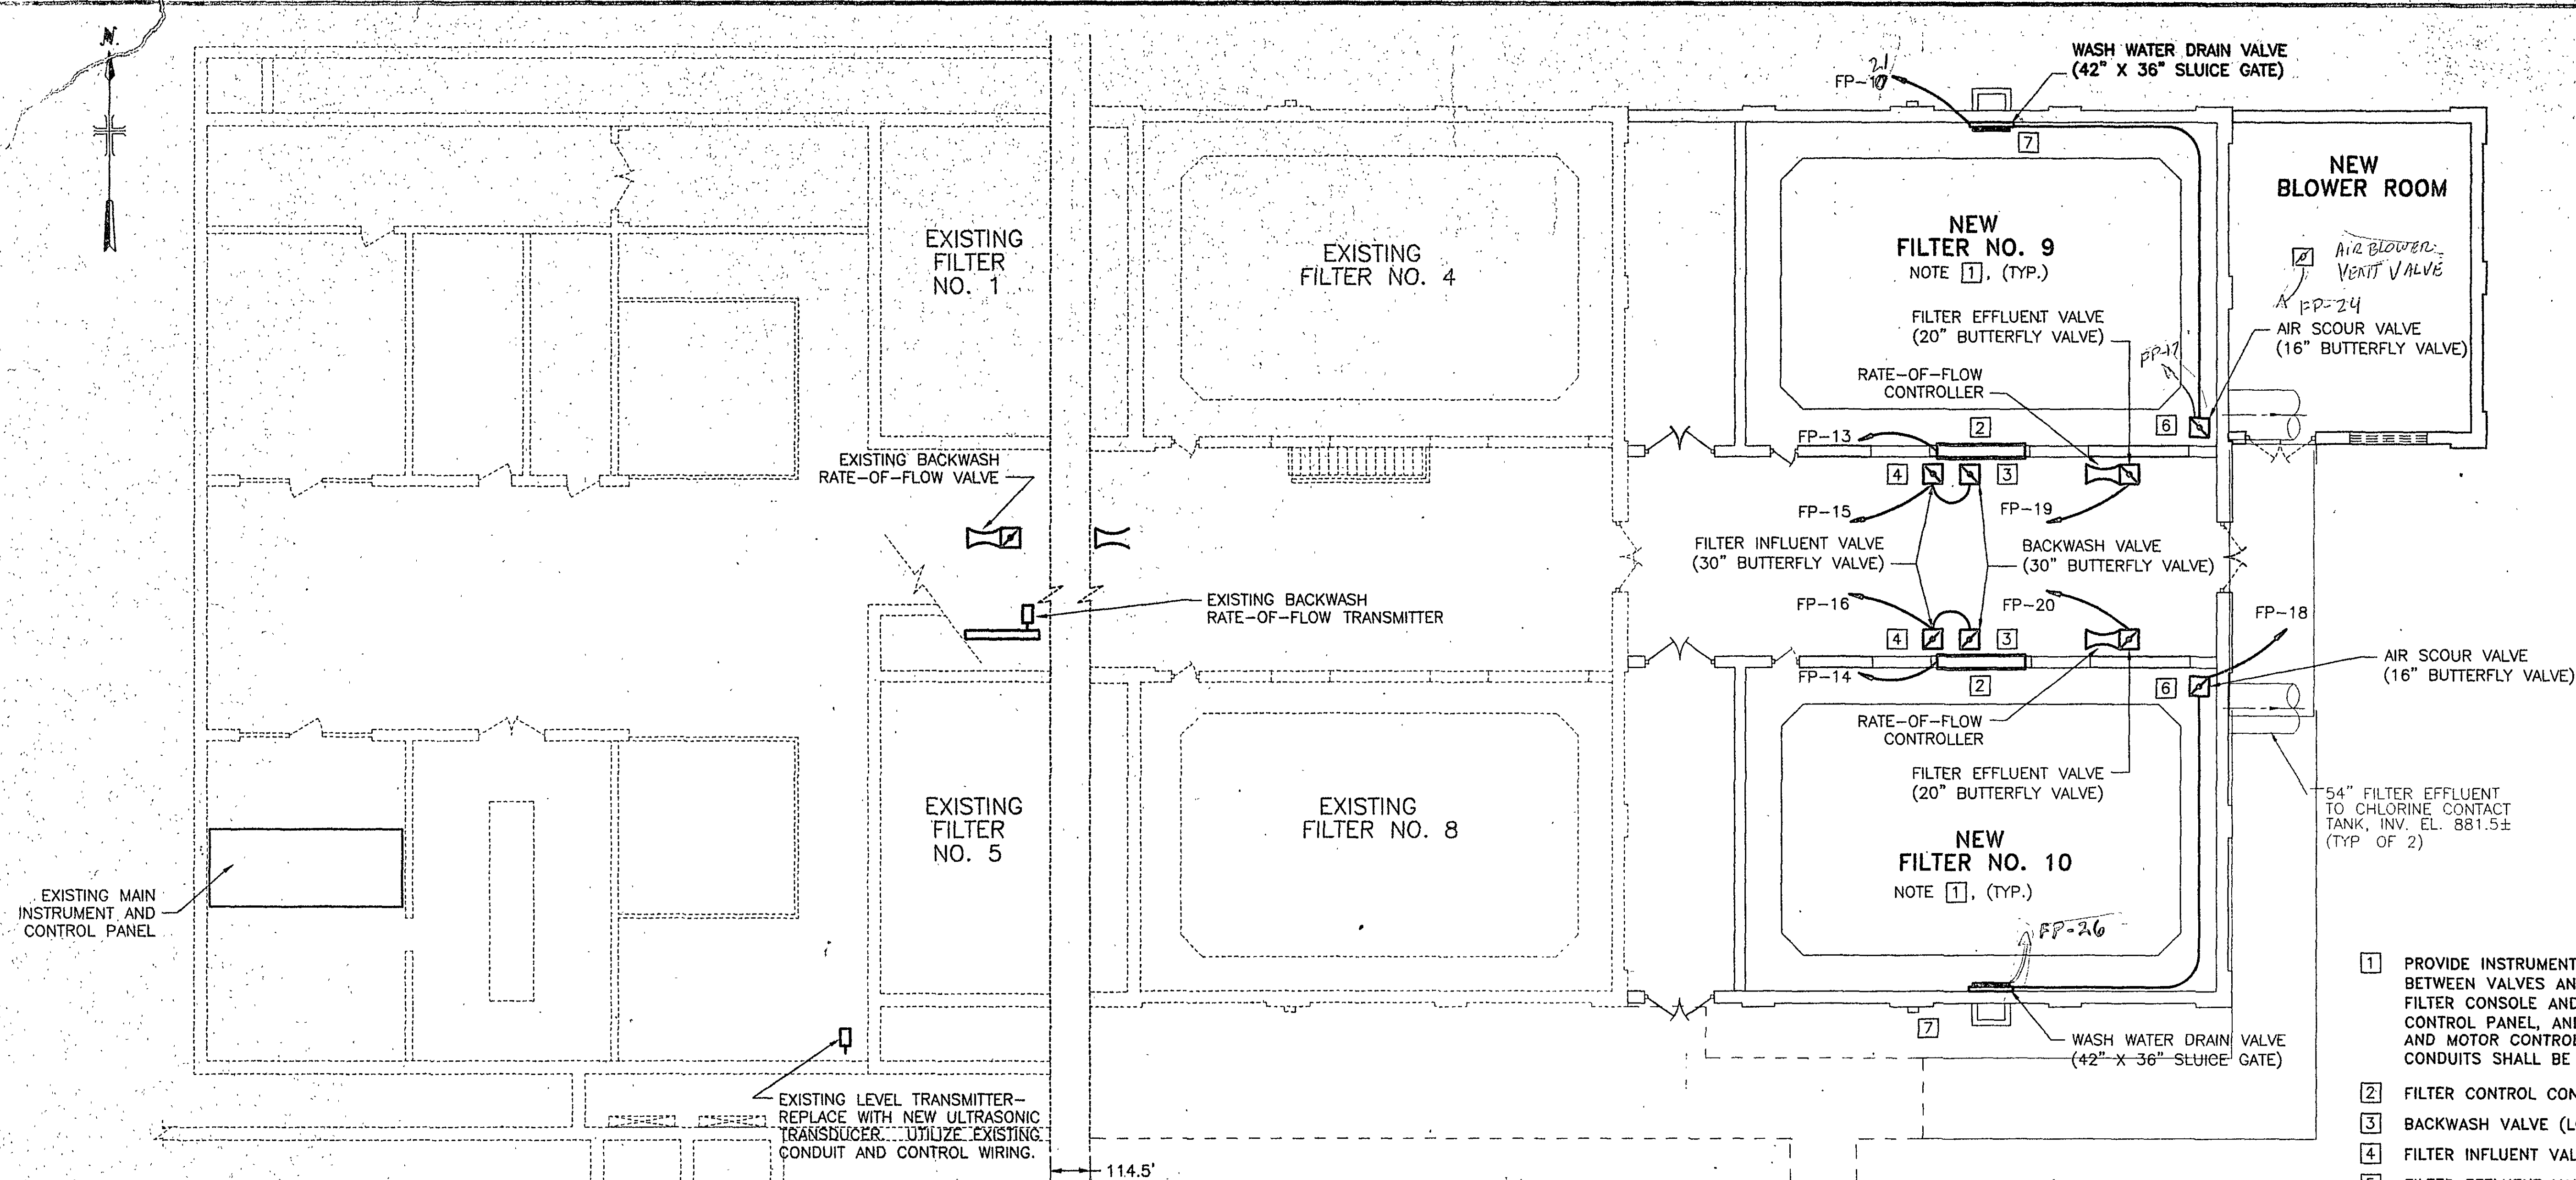


EXISTING OPERATING FLOOR PLAN EL. 907.17
SCALE: 1/8" = 1'-0"

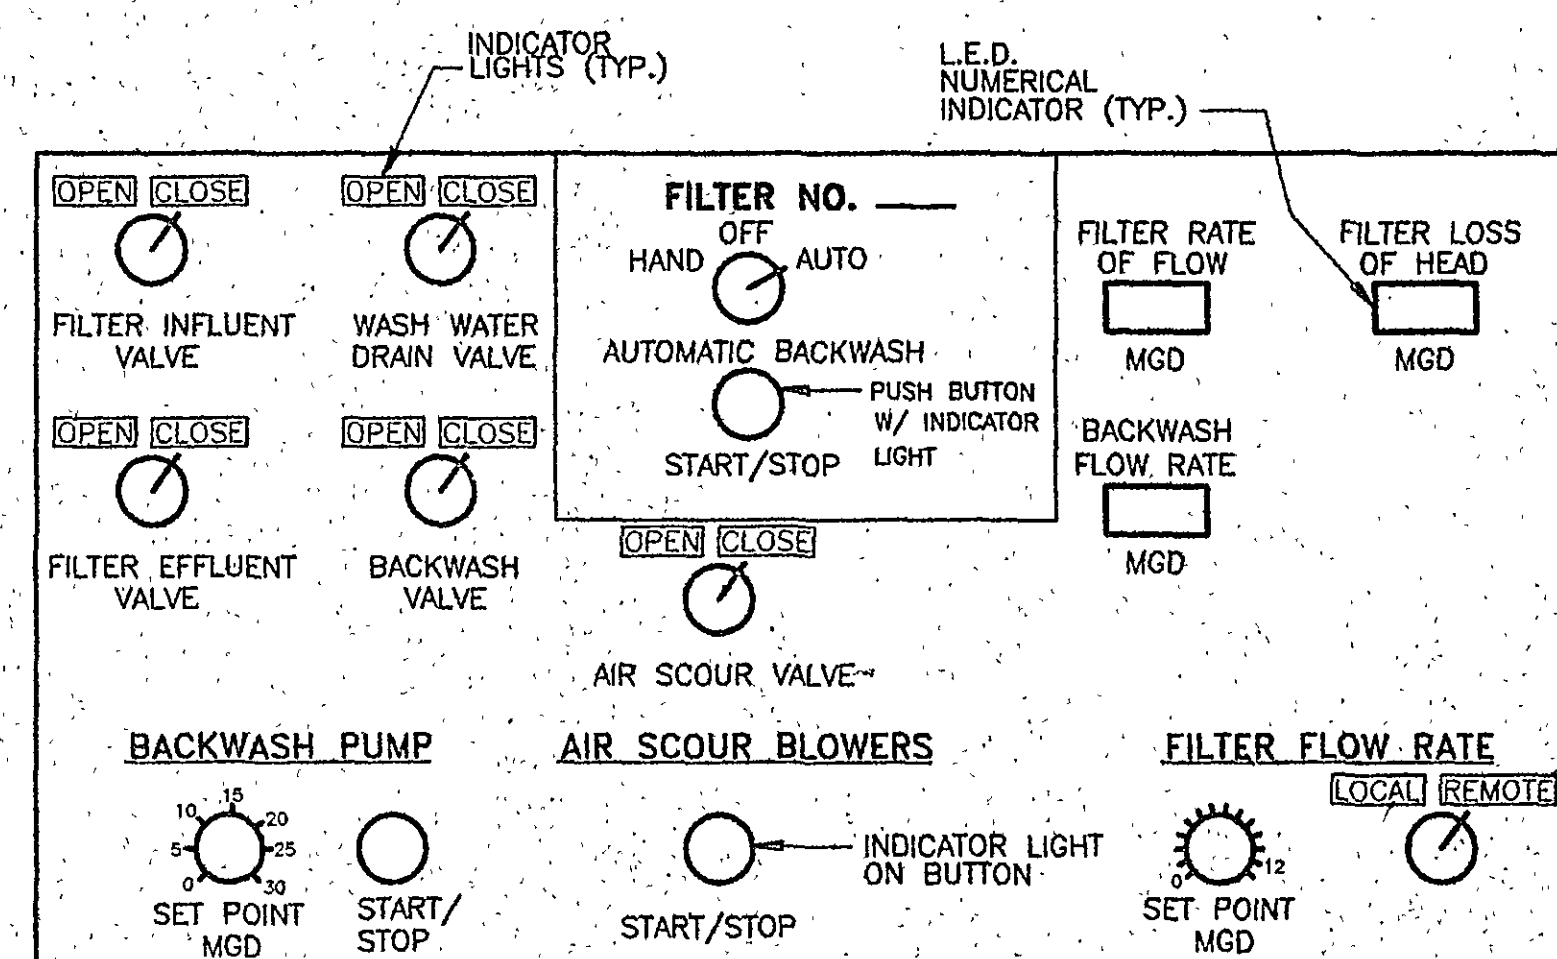


FILTER CONTROL CONSOLE (TYPICAL FOR EACH FILTER)
NO SCALE

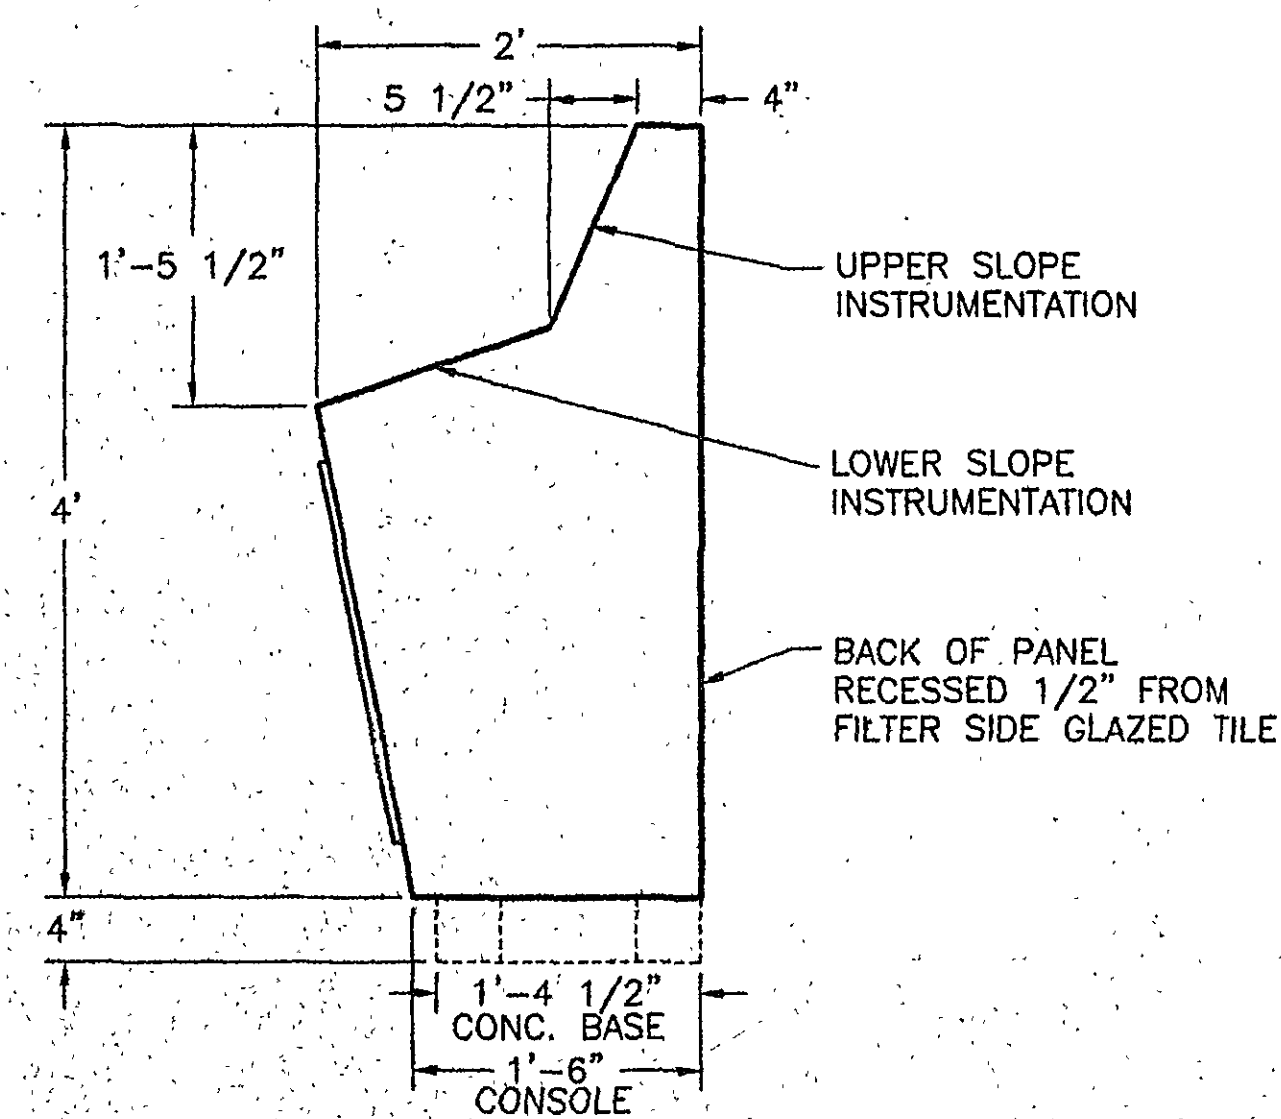

PROFILE ELEVATION
SCALE: 1" = 1'-0"

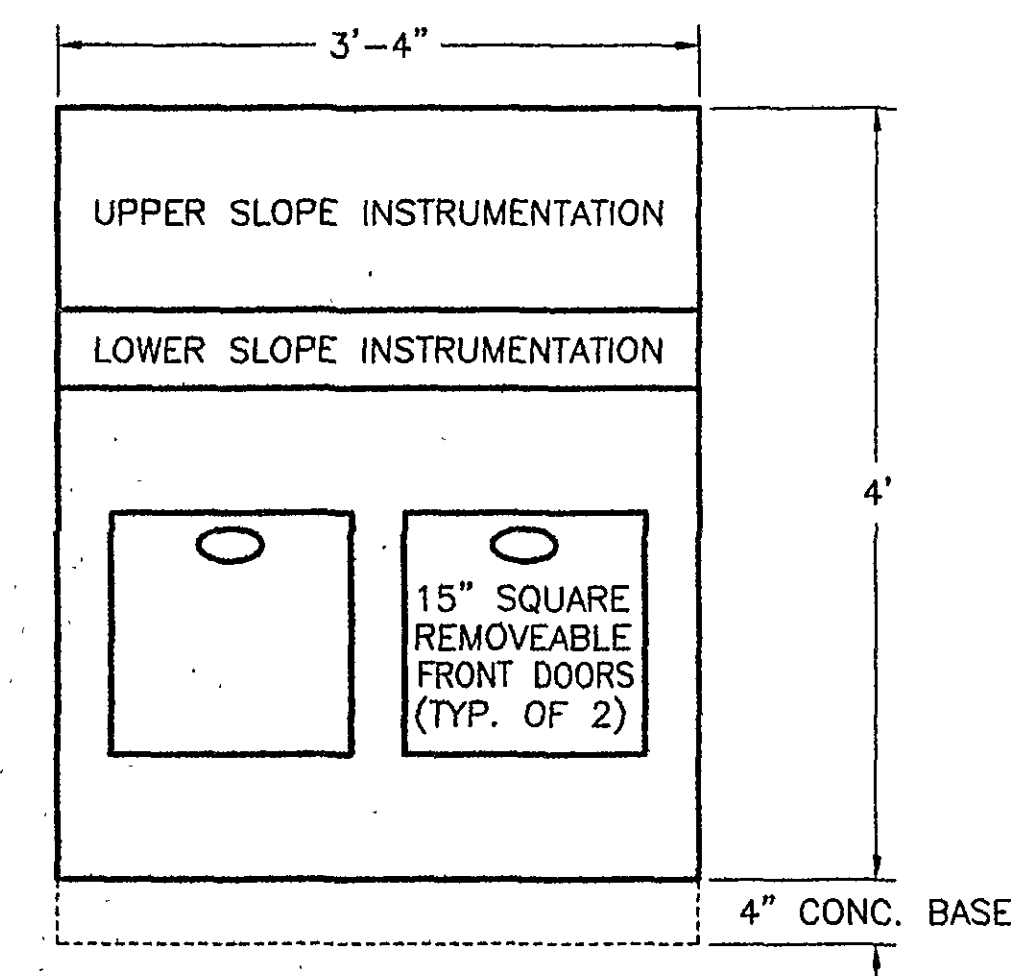

FRONT ELEVATION
SCALE: 1" = 1'-0"

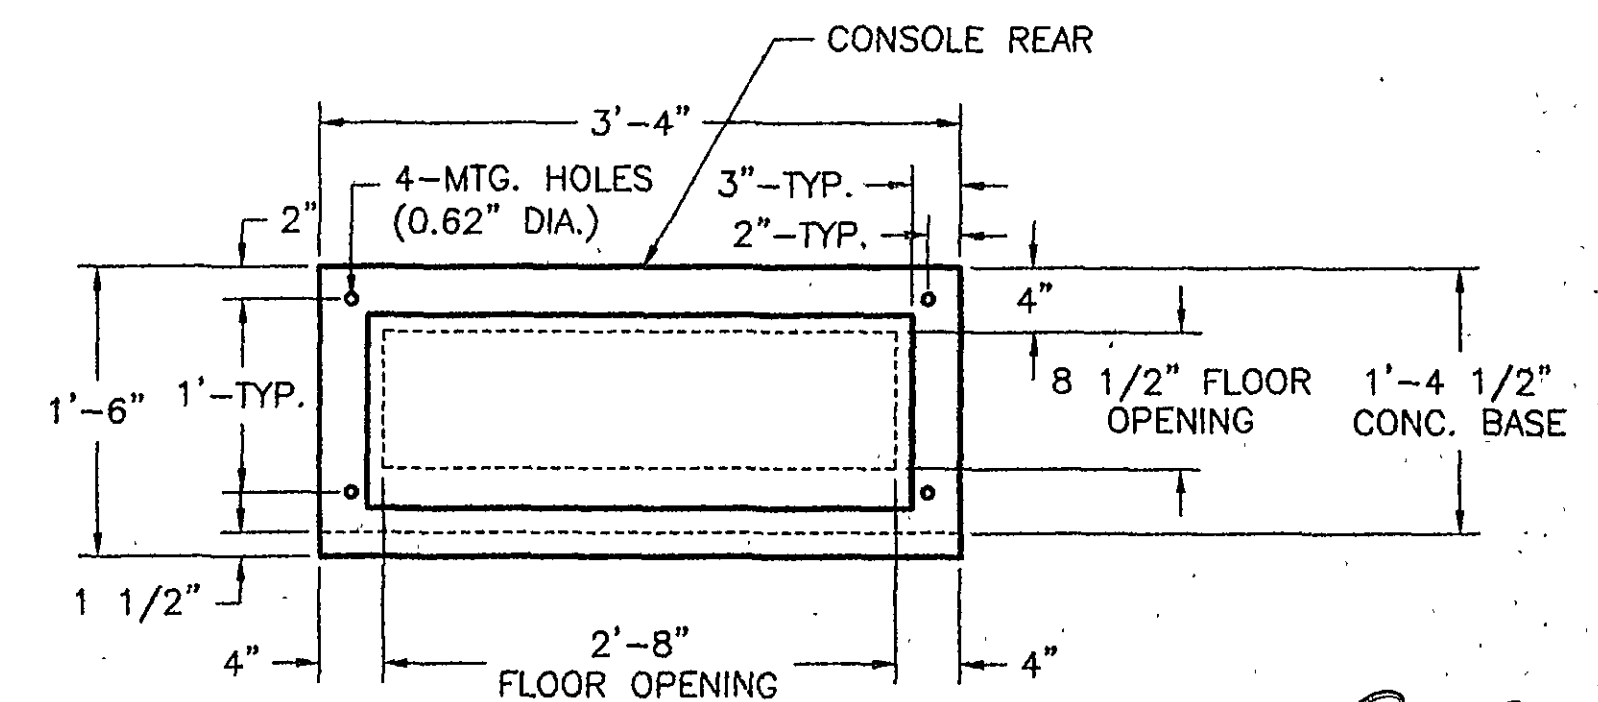

FLOOR MOUNTING PLAN
SCALE: 1" = 1'-0"

NOTES THIS SHEET:

- 1 PROVIDE INSTRUMENT AND CONTROL WIRING, IN CONDUIT, BETWEEN VALVES AND FILTER CONTROL CONSOLE, BETWEEN FILTER CONSOLE AND EXISTING MAIN INSTRUMENT AND CONTROL PANEL, AND BETWEEN FILTER CONTROL CONSOLES AND MOTOR CONTROL CENTER (MCC12), AS REQUIRED. CONDUITS SHALL BE RUN ALONG CEILING OF PIPING GALLERY.
- 2 FILTER CONTROL CONSOLE
- 3 BACKWASH VALVE (LOCATED IN PIPING GALLERY)
- 4 FILTER INFLUENT VALVE (LOCATED IN PIPING GALLERY)
- 5 FILTER EFFLUENT VALVE (LOCATED IN PIPING GALLERY)
- 6 AIR SCOUR VALVE (LOCATED ABOVE WALKWAY)
- 7 WASH WATER DRAIN VALVE (LOCATED IN FILTER WASH WATER GULLET)
- 8 DISCONNECT AND RECONNECT POWER AND CONTROL WIRING AS REQUIRED.

RECORD DRAWINGS