



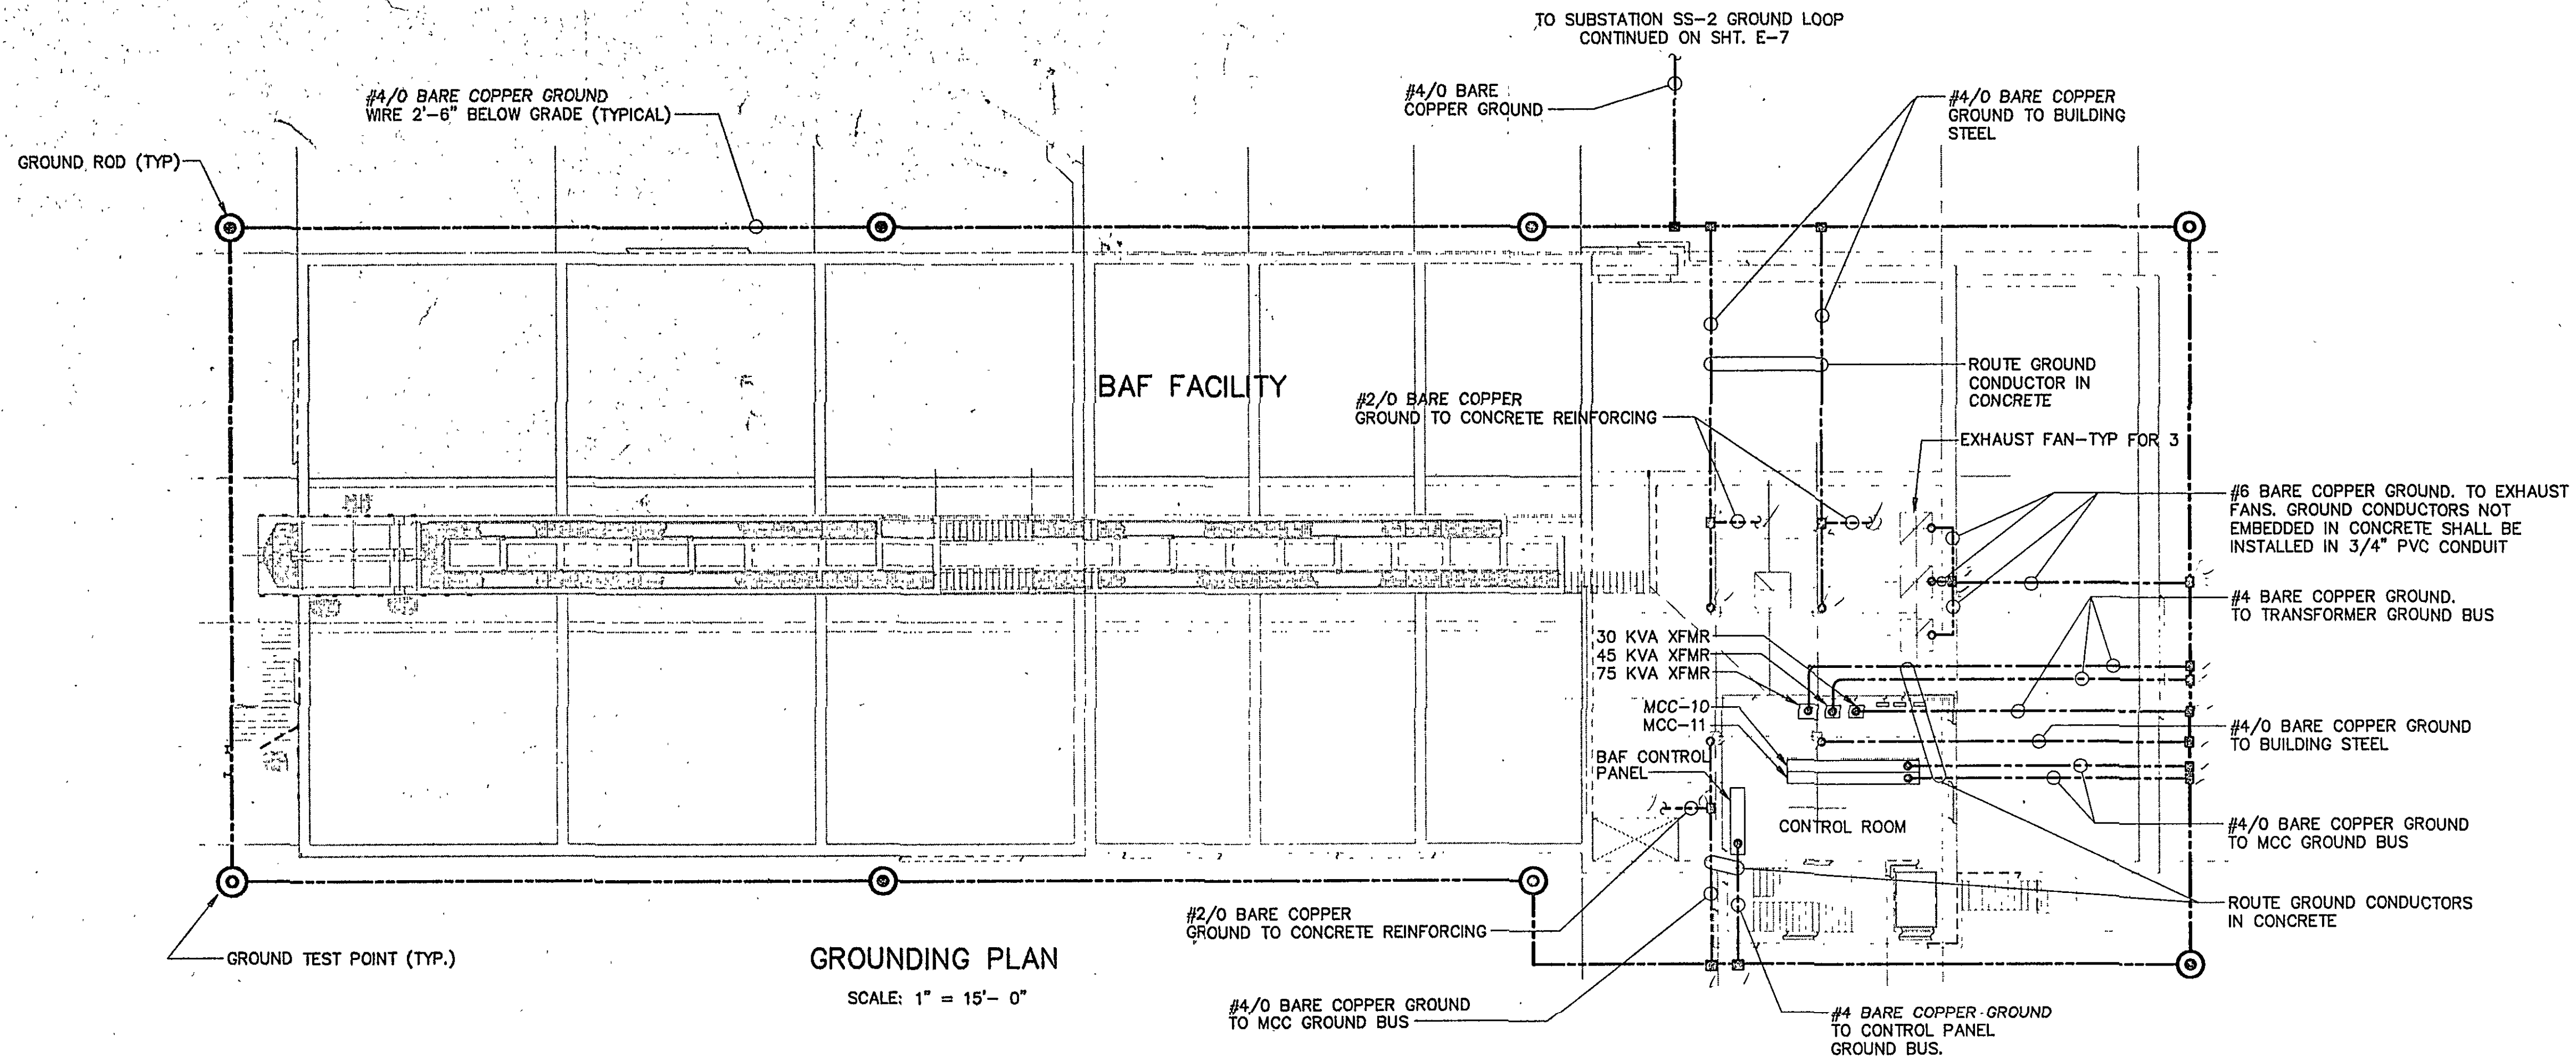

GROUNDING PLAN

SCALE: 1" = 15'- 0"

- NOTES:
1. SEE SHEET E-15 FOR AREA CLASSIFICATION
 2. FOR LIGHTING FIXTURE SCHEDULE SEE SH. E-12

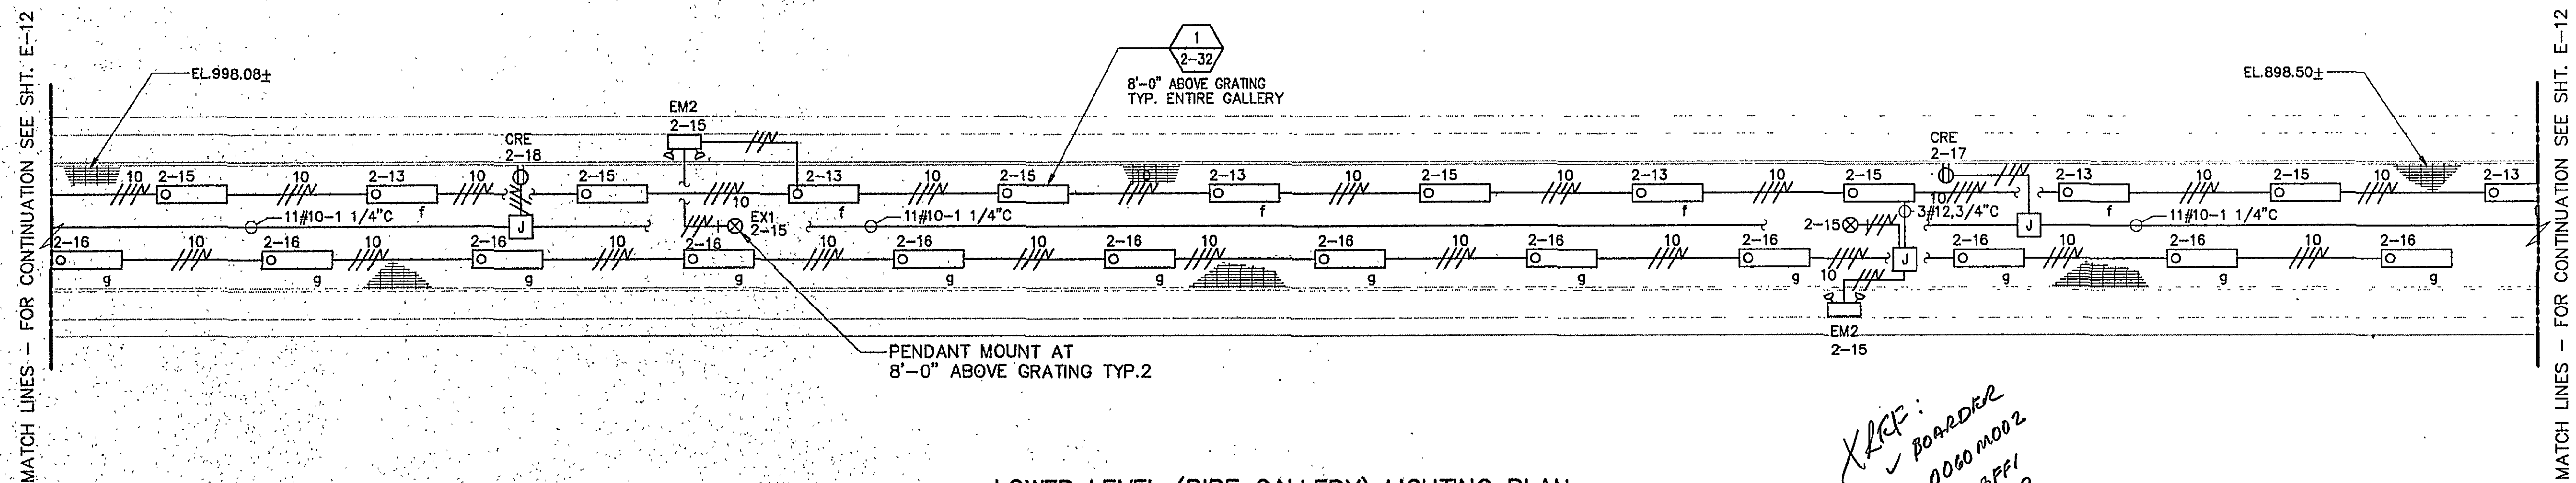

LOWER LEVEL (PIPE GALLERY) LIGHTING PLAN

SCALE: 3/16"=1'-0"

Handwritten notes:
 XREF:
 - BOARDER
 - 0060 M002
 - EG DBFFI
 - SGPB PTP

RECORD DRAWINGS

	MALCOLM PIRNIE 11832 Rock Landing Drive, Suite 400 Newport News, Virginia 23606	REVISIONS <table border="1"> <tr> <th>NO.</th> <th>BY</th> <th>DATE</th> <th>REMARKS</th> </tr> <tr><td> </td><td> </td><td> </td><td> </td></tr> <tr><td> </td><td> </td><td> </td><td> </td></tr> <tr><td> </td><td> </td><td> </td><td> </td></tr> </table>		NO.	BY	DATE	REMARKS													DES - KLL DWN - KLL CKD - TK		CITY OF ROANOKE, VIRGINIA WATER POLLUTION CONTROL PLANT UPGRADE AND EXPANSION	BIOLOGICAL AERATED FILTER GROUNDING PLAN SCALE: AS NOTED	COPYRIGHT © 1997 MALCOLM PIRNIE, INC. DATE - MAY 1997
		NO.	BY	DATE	REMARKS																			
E SHEET 13 OF 36																								
CAD REF. NO. 0060E688																								
UNDER SKIDS																								