




NOTES:
1. AREA CLASSIFICATION:
a. THE ENTIRE LOWER LEVEL IS CONSIDERED A WET LOCATION. ALL MATERIALS, EQUIPMENT AND INCIDENTALS SHALL MEET NEMA 4X REQUIREMENTS. ALL EXPOSED CONDUITS SHALL BE PVC COATED RIGID STEEL.

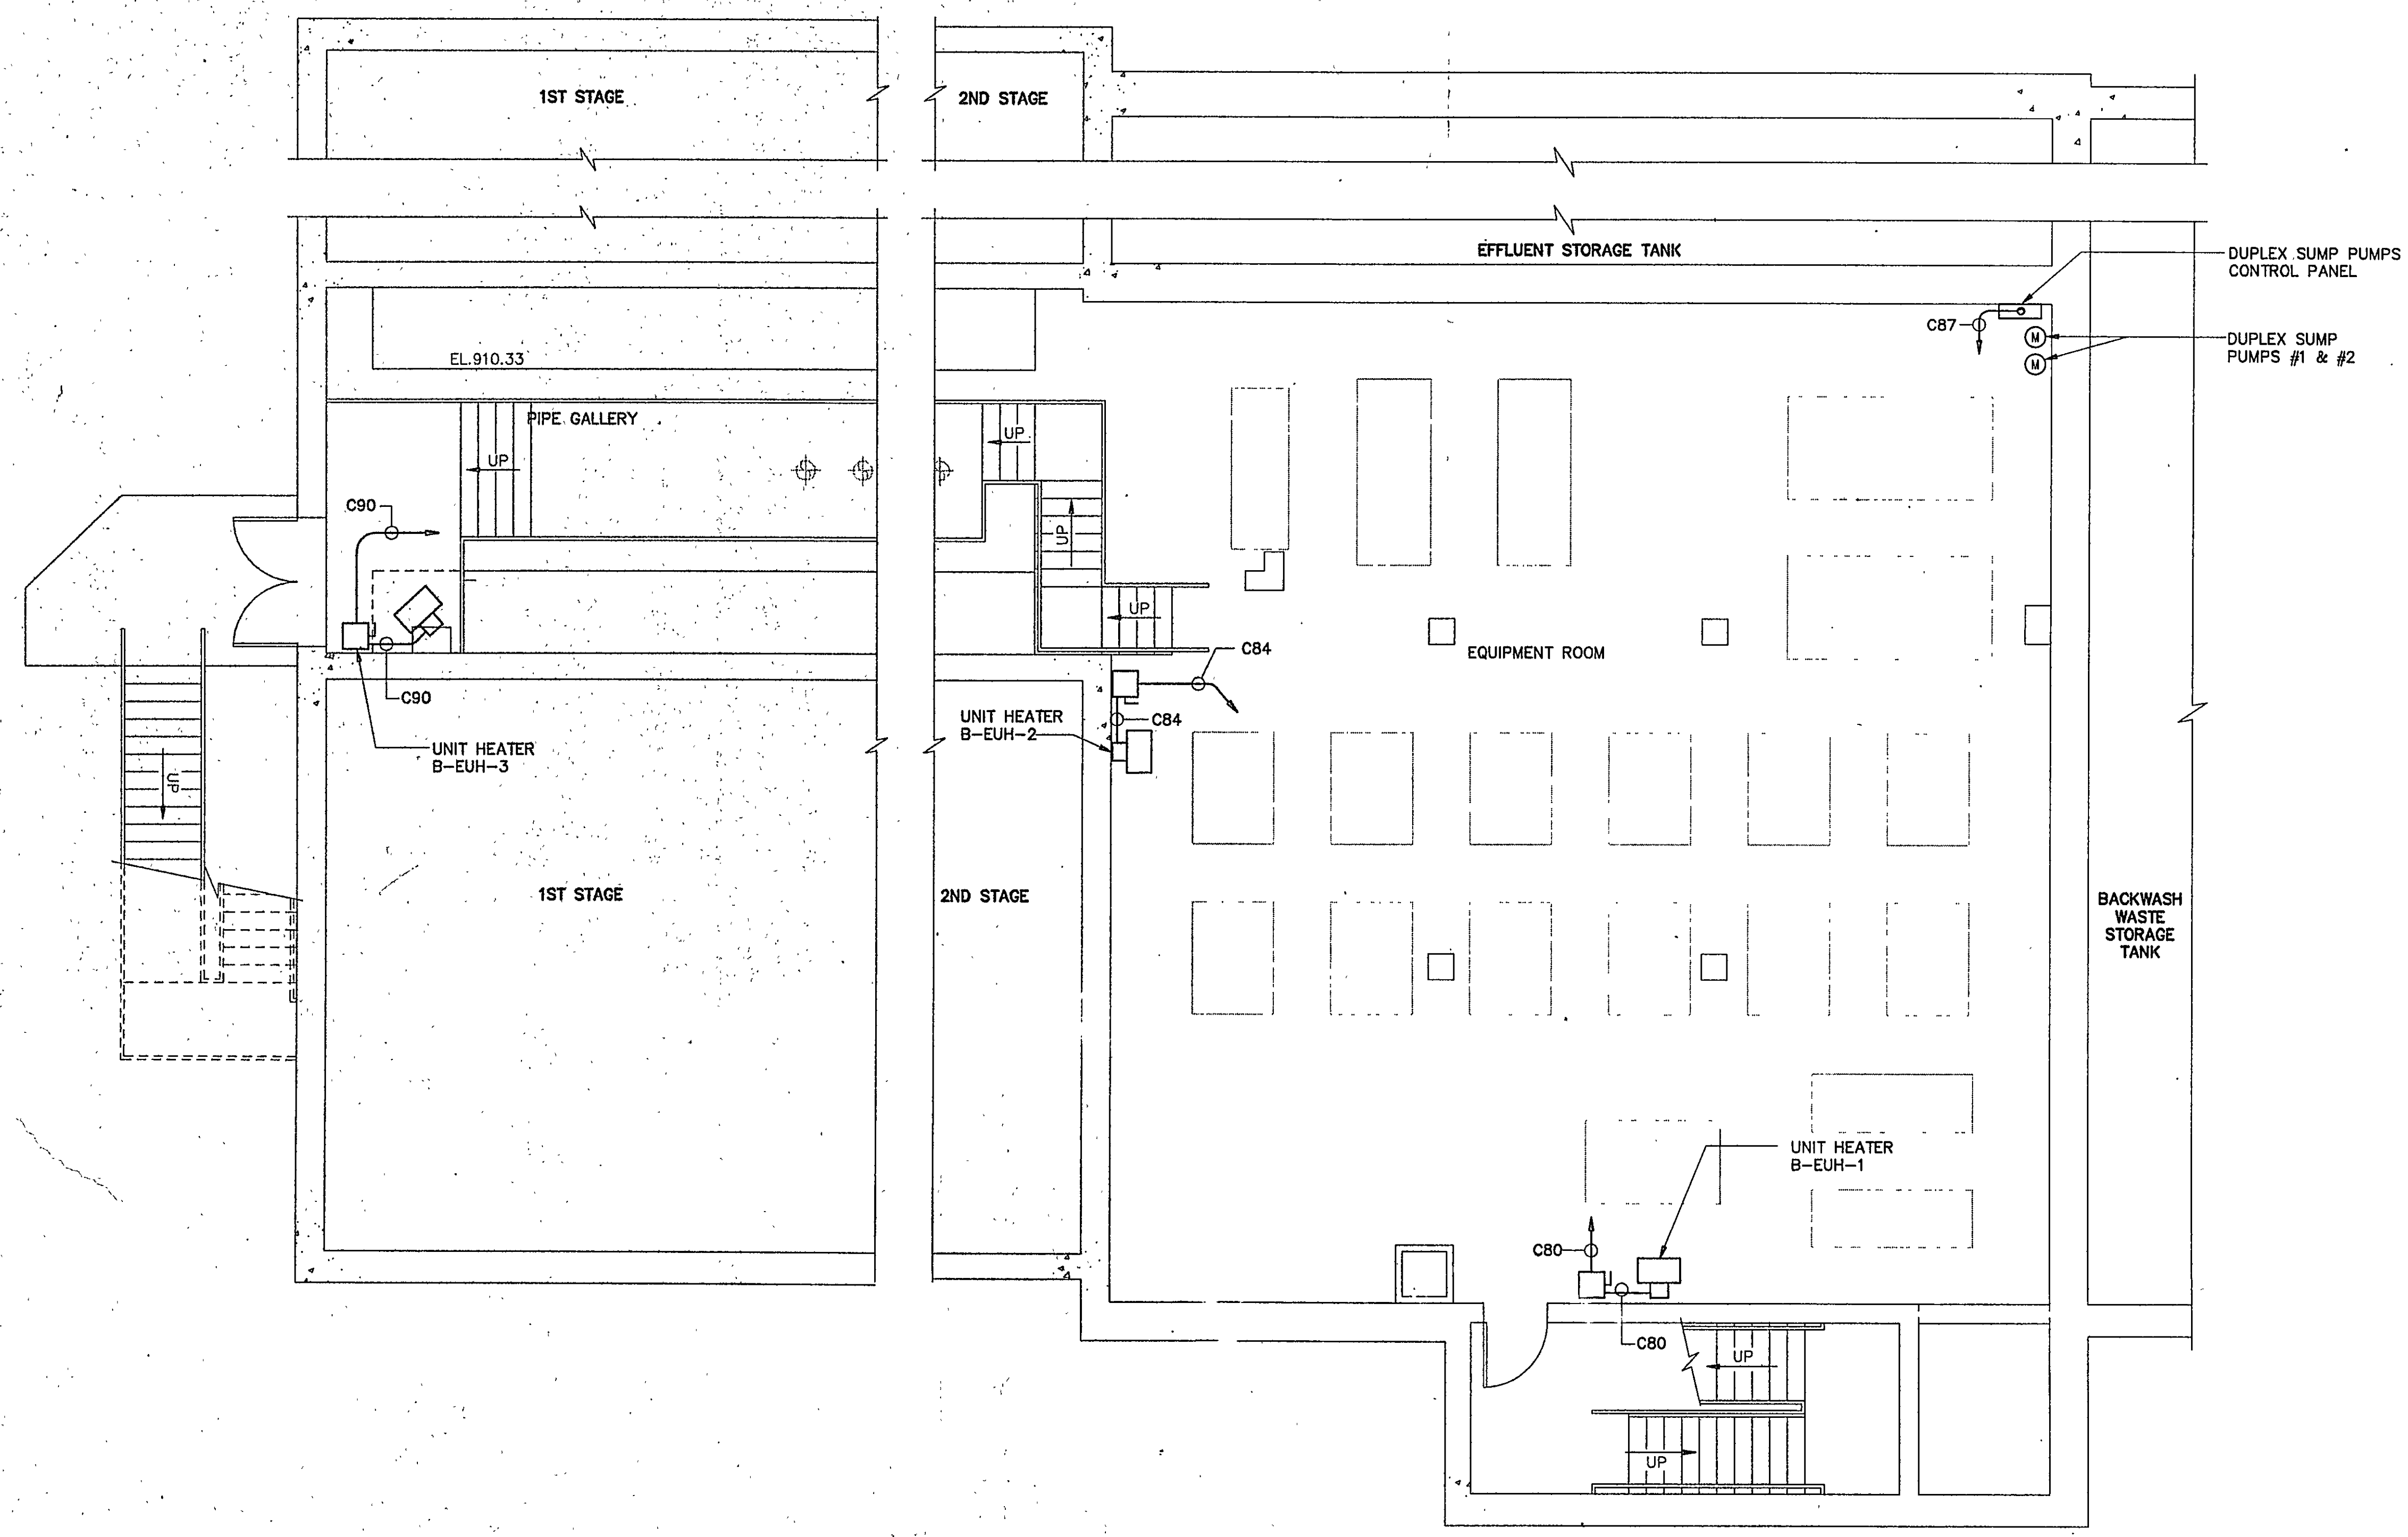

PLAN

RECORD DRAWINGS

BIOLOGICAL AERATED FILTER LOWER LEVEL POWER PLAN

SCALE: 3/16"=1'-0"

CITY OF ROANOKE, VIRGINIA
WATER POLLUTION
CONTROL PLANT
UPGRADE AND EXPANSION



DES - GJM
DWN - GJM
CKD - TK

REVISIONS					REMARKS
NO.	BY	DATE	DESCRIPTION	REVISIONS	

MALCOLM PIRNIE
11832 Rock Landing Drive, Suite 400
Newport News, Virginia 23608

7361 00602690 L:\CAD\PROJ\00602690\00602690.dwg Scale: 1/8"=1'-0" Date: 05/05/1997 Time: 15:25
5/6/97
MALCOLM PIRNIE, INC.
PROFESSIONAL ENGINEER
No. 030171

COPYRIGHT © 1997
MALCOLM PIRNIE, INC.
DATE MAY 1997
E SHEET 15 OF 36
CAD REF. NO. 00602690