


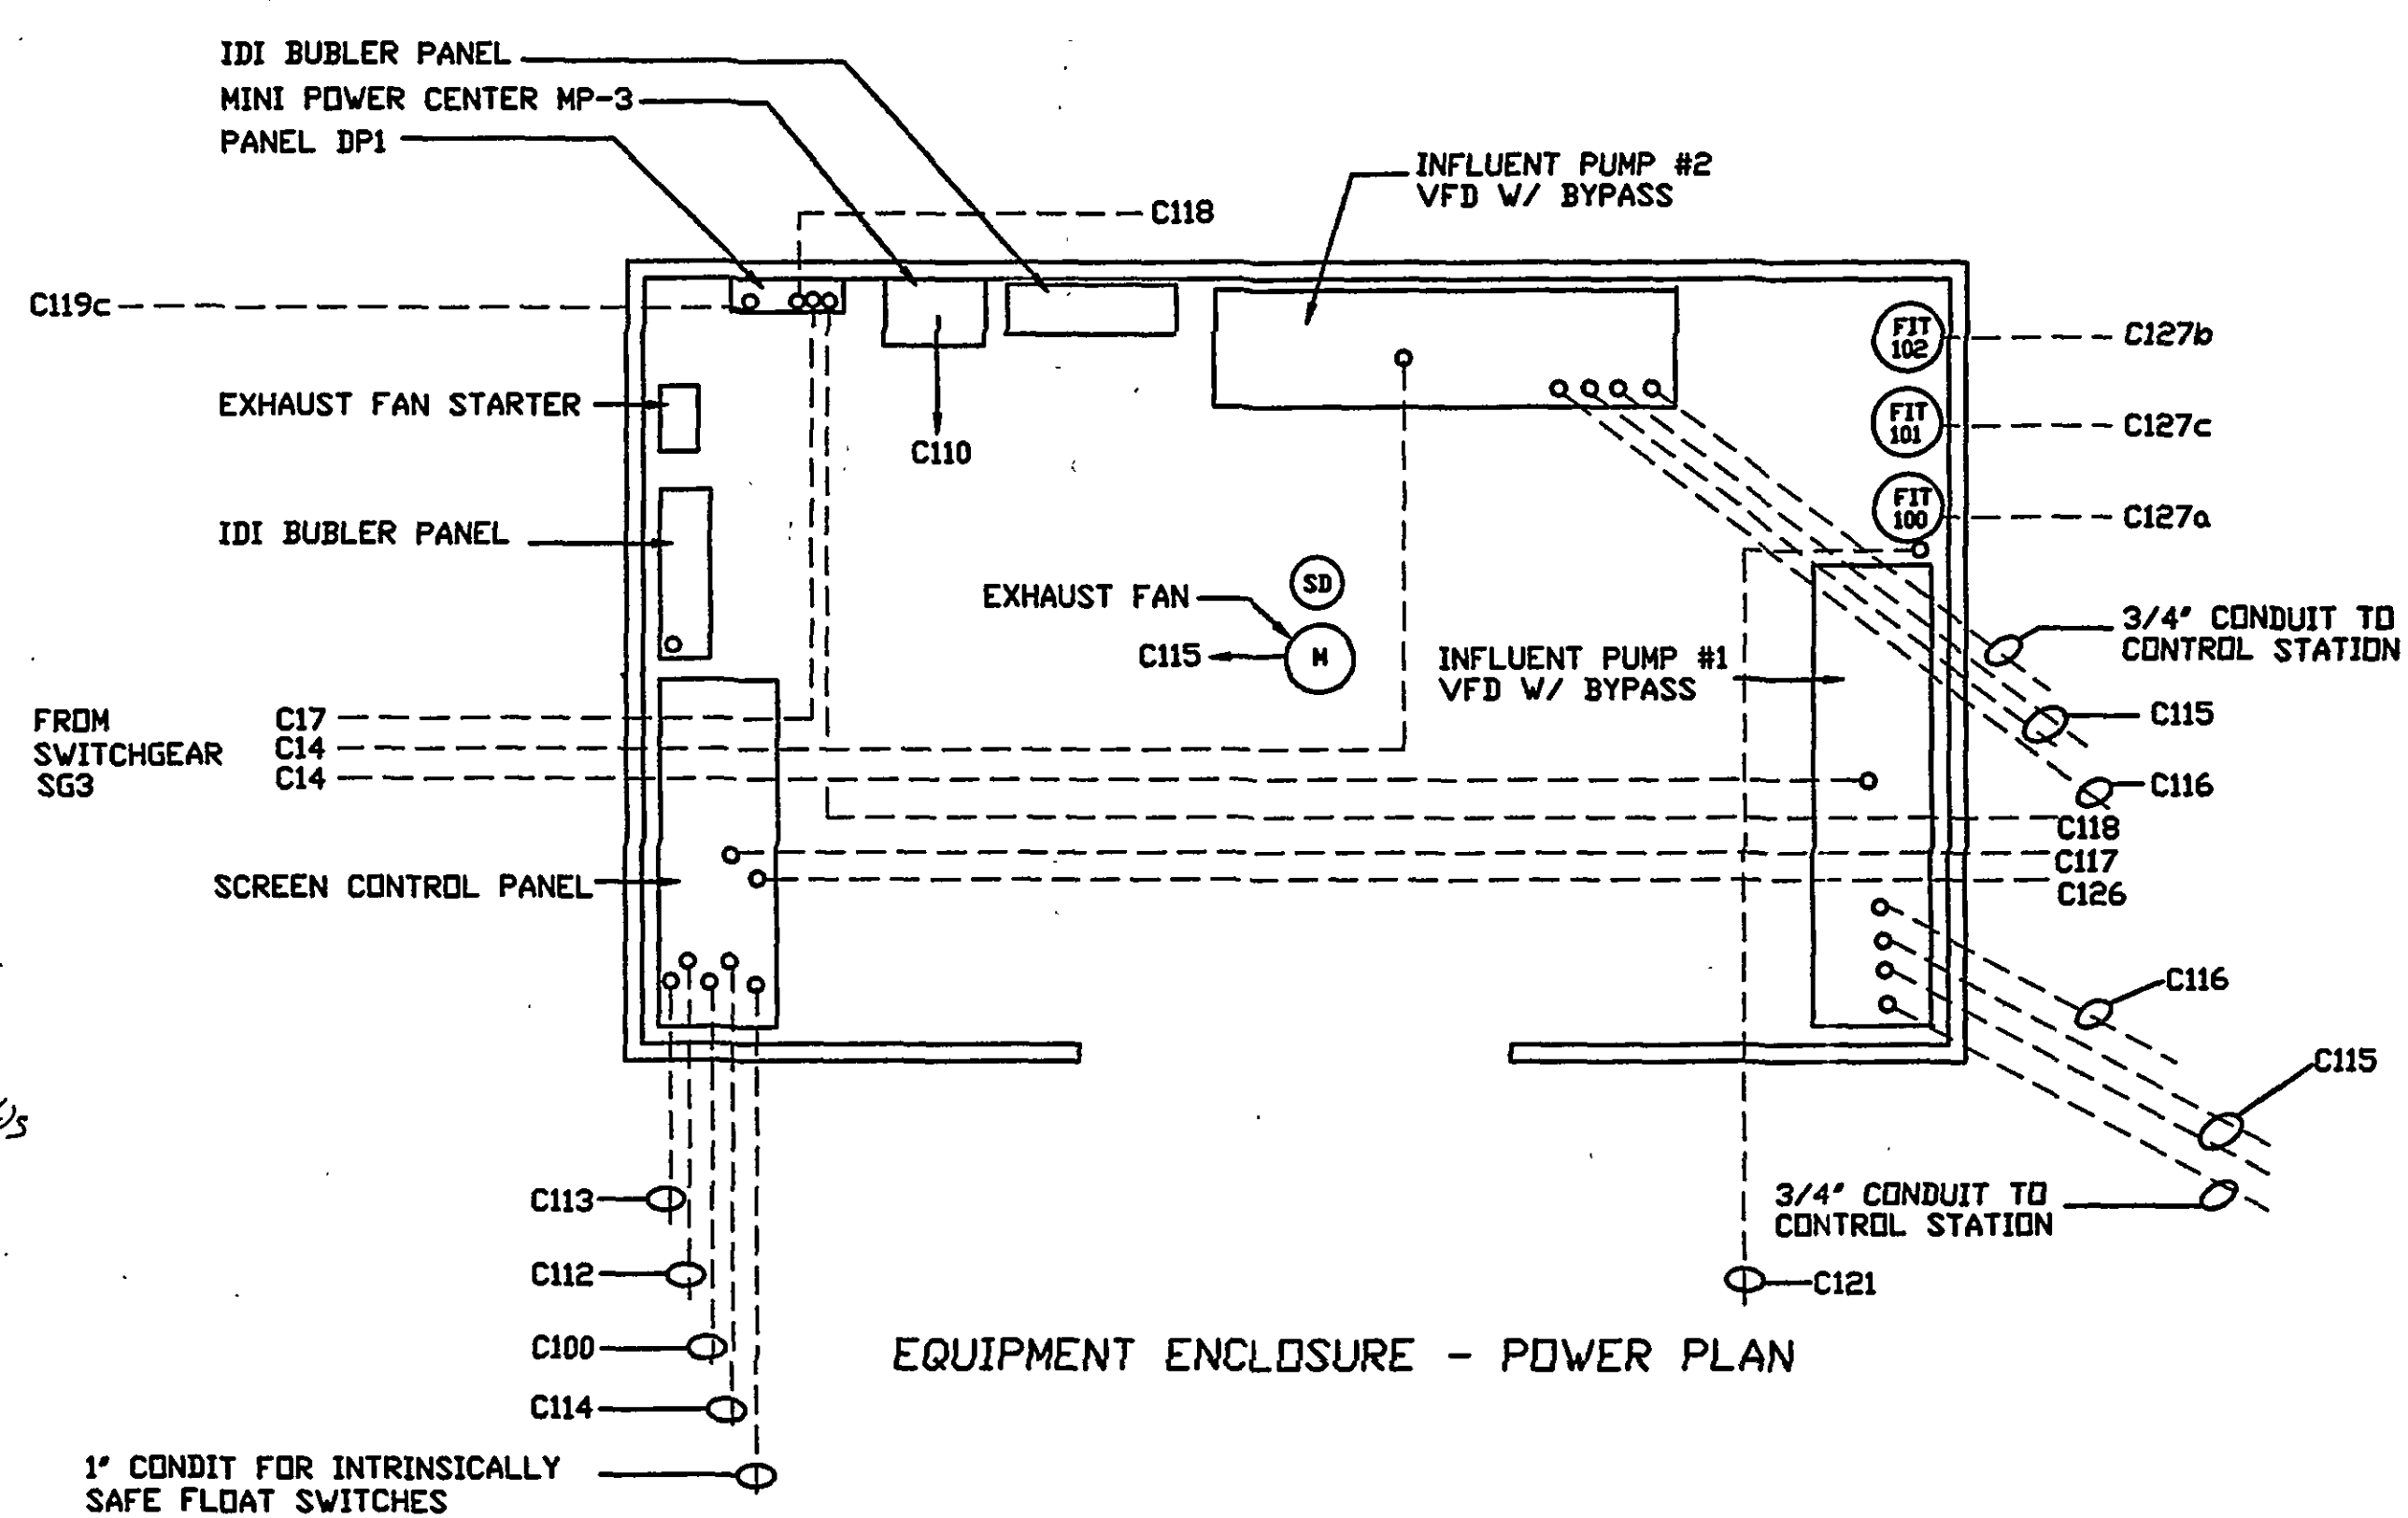

KEY PLAN		
NO	DESCRIPTION	DATE
REVISIONS		
NOTES		
SEAL		
		
G. J. HOPKINS, INC. MECHANICAL & ELECTRICAL CONTRACTORS P.O. BOX 12467 ROANOKE, VIRGINIA 24025 PHONE: 540-928-1873 FAX: 540-922-0553		
DESIGNED BY	DRAWN BY	
DV	DV	
CHECKED BY	APPROVED BY	
DV	DV	
PROJECT		
ROANOKE Water Pollution Control Plant Roanoke, VA		
DRAWING TITLE		
EQUIPMENT ENCLOSURE POWER PLAN		
JOB NUMBER	DATE	
377	1/30/2000	
SHEET NUMBER		
E-20A		