


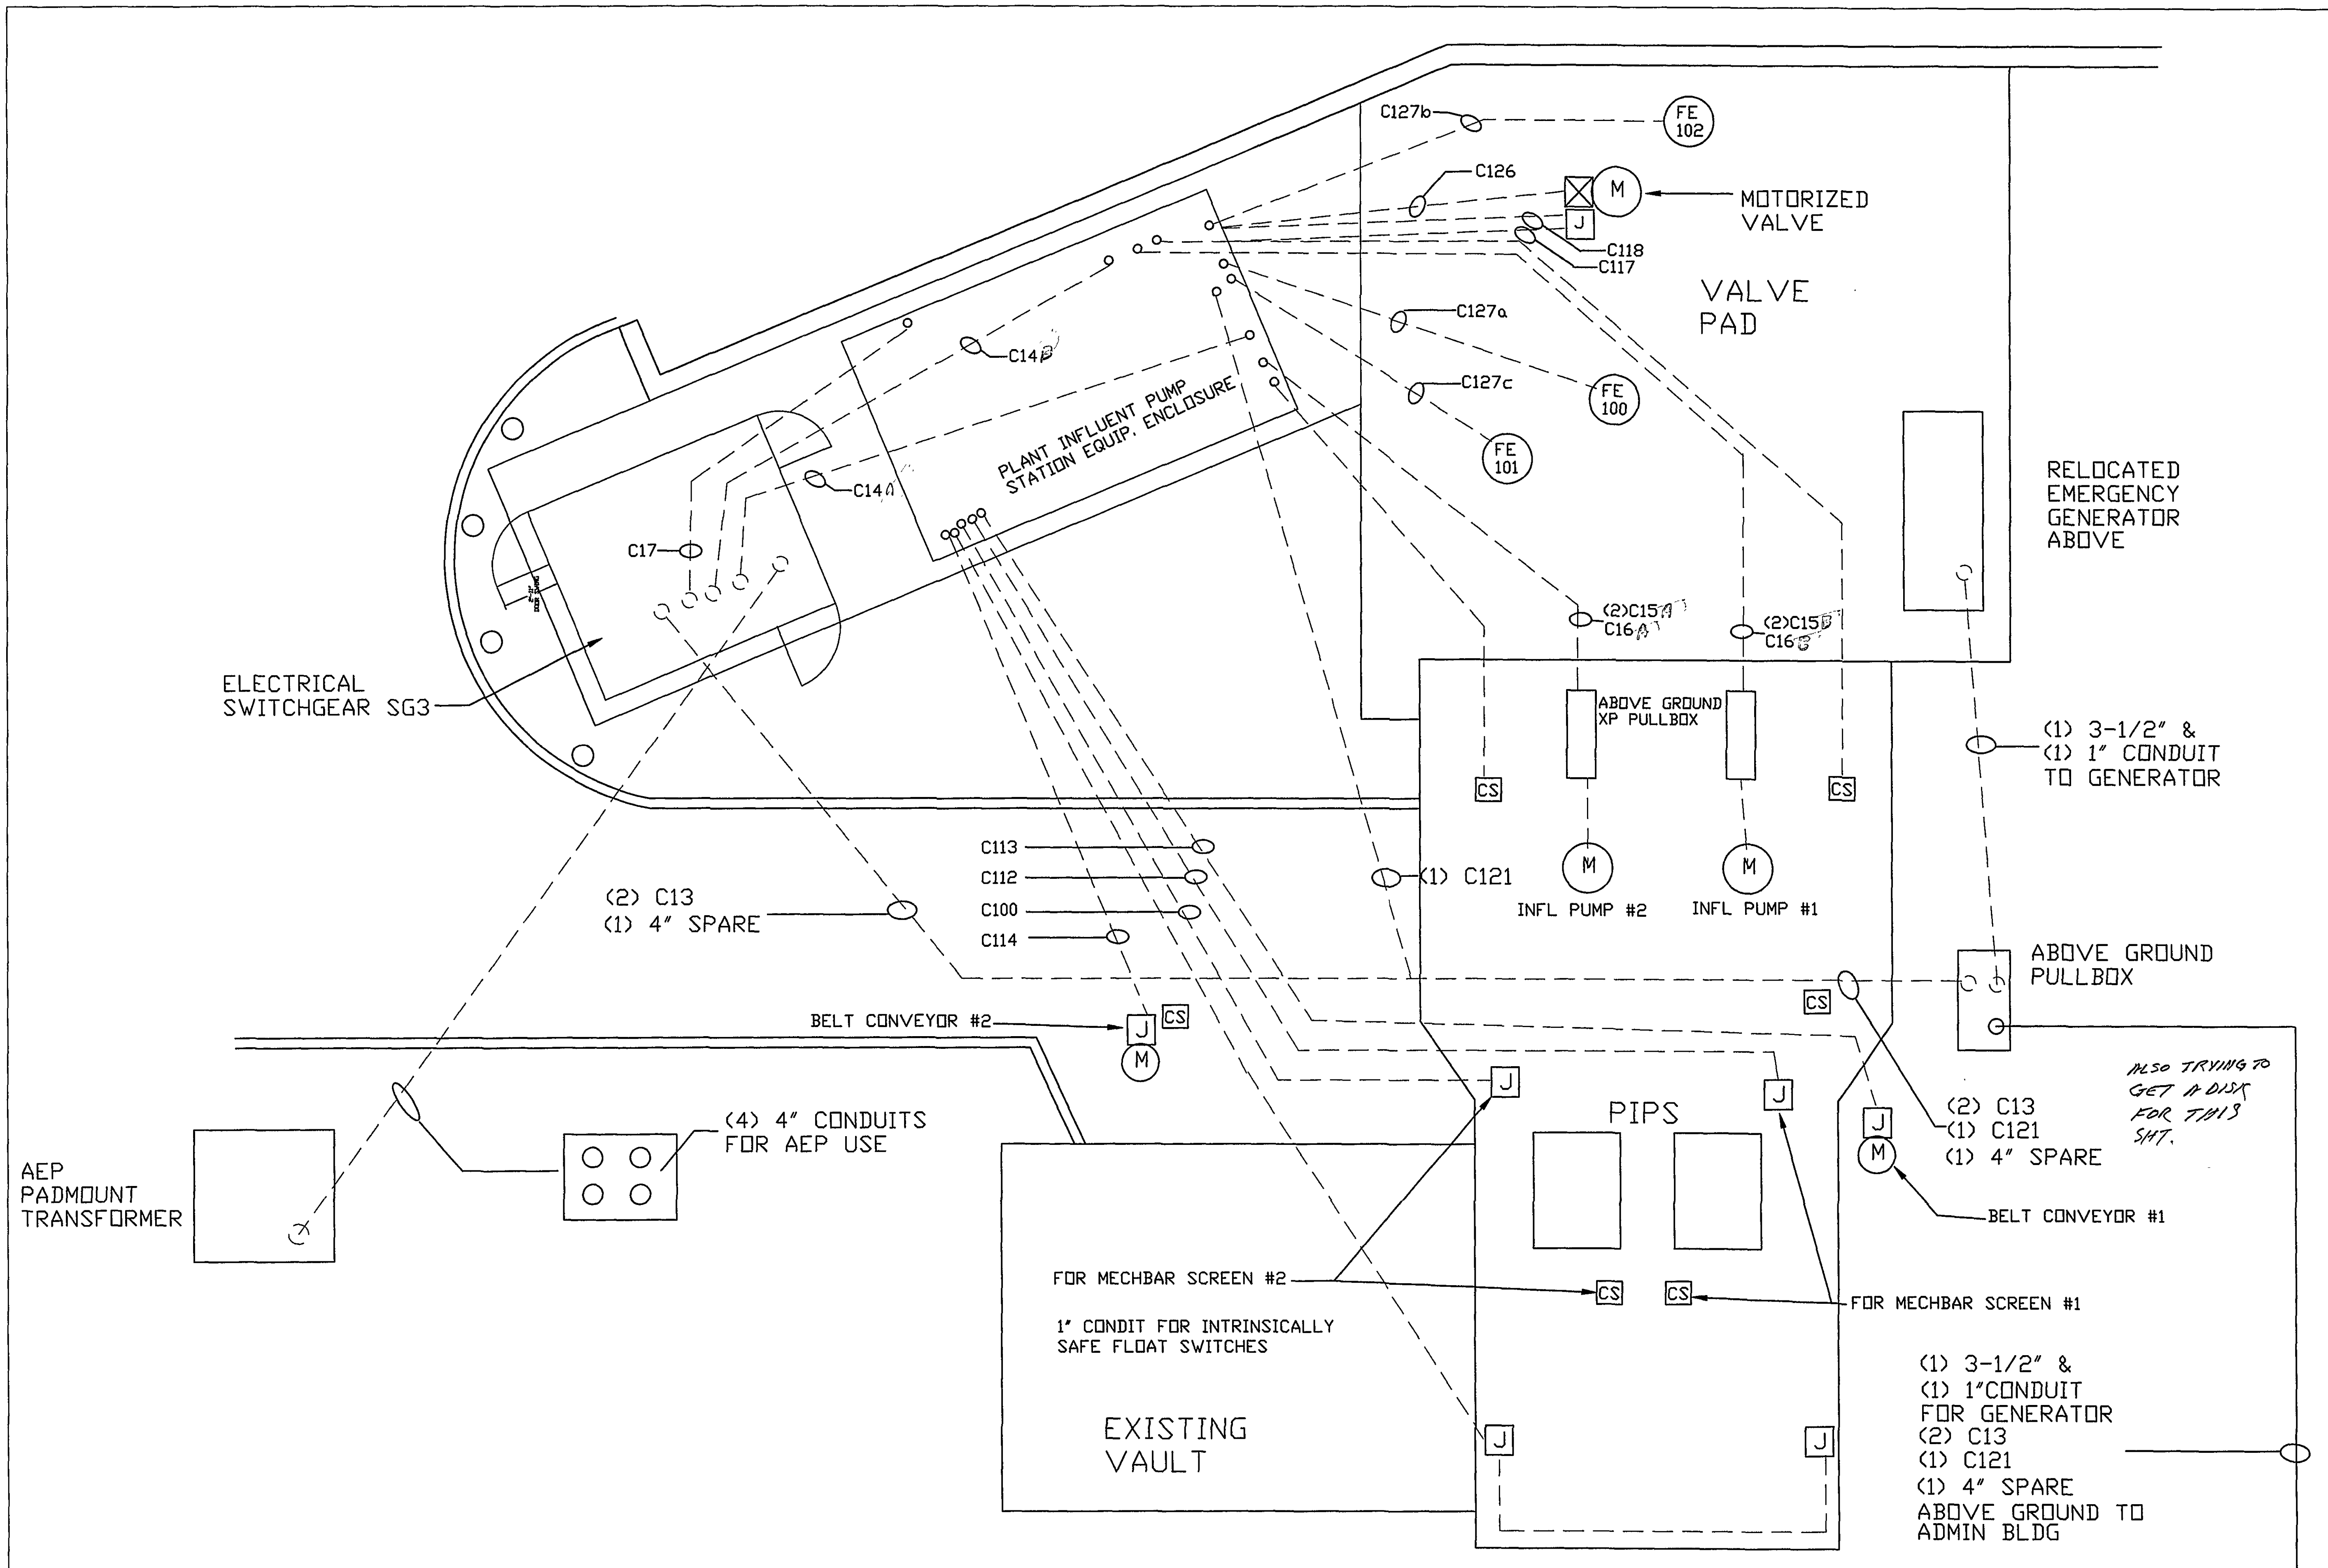

RECORD DRAWINGS


KEY PLAN

NO	DESCRIPTION	DATE

REVISIONS

NOTES

SEAL

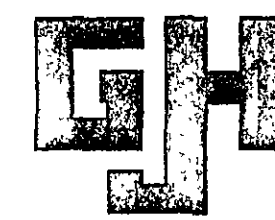

G. J. HOPKINS, INC.

MECHANICAL & ELECTRICAL CONTRACTORS
P.O. BOX 12467
ROANOKE, VIRGINIA 24025
PHONE: 540-982-1873 FAX: 540-982-0655

DESIGNED BY DV	DRAWN BY DV
CHECKED BY DV	APPROVED BY DV

PROJECT

ROANOKE
Water Pollution
Control Plant
Roanoke, VA

DRAWING TITLE

**INFLUENT PUMP STATION
ELECTRICAL PLAN**

JOB NUMBER 377	DATE 1/30/2000
SHEET NUMBER	

E-21A