


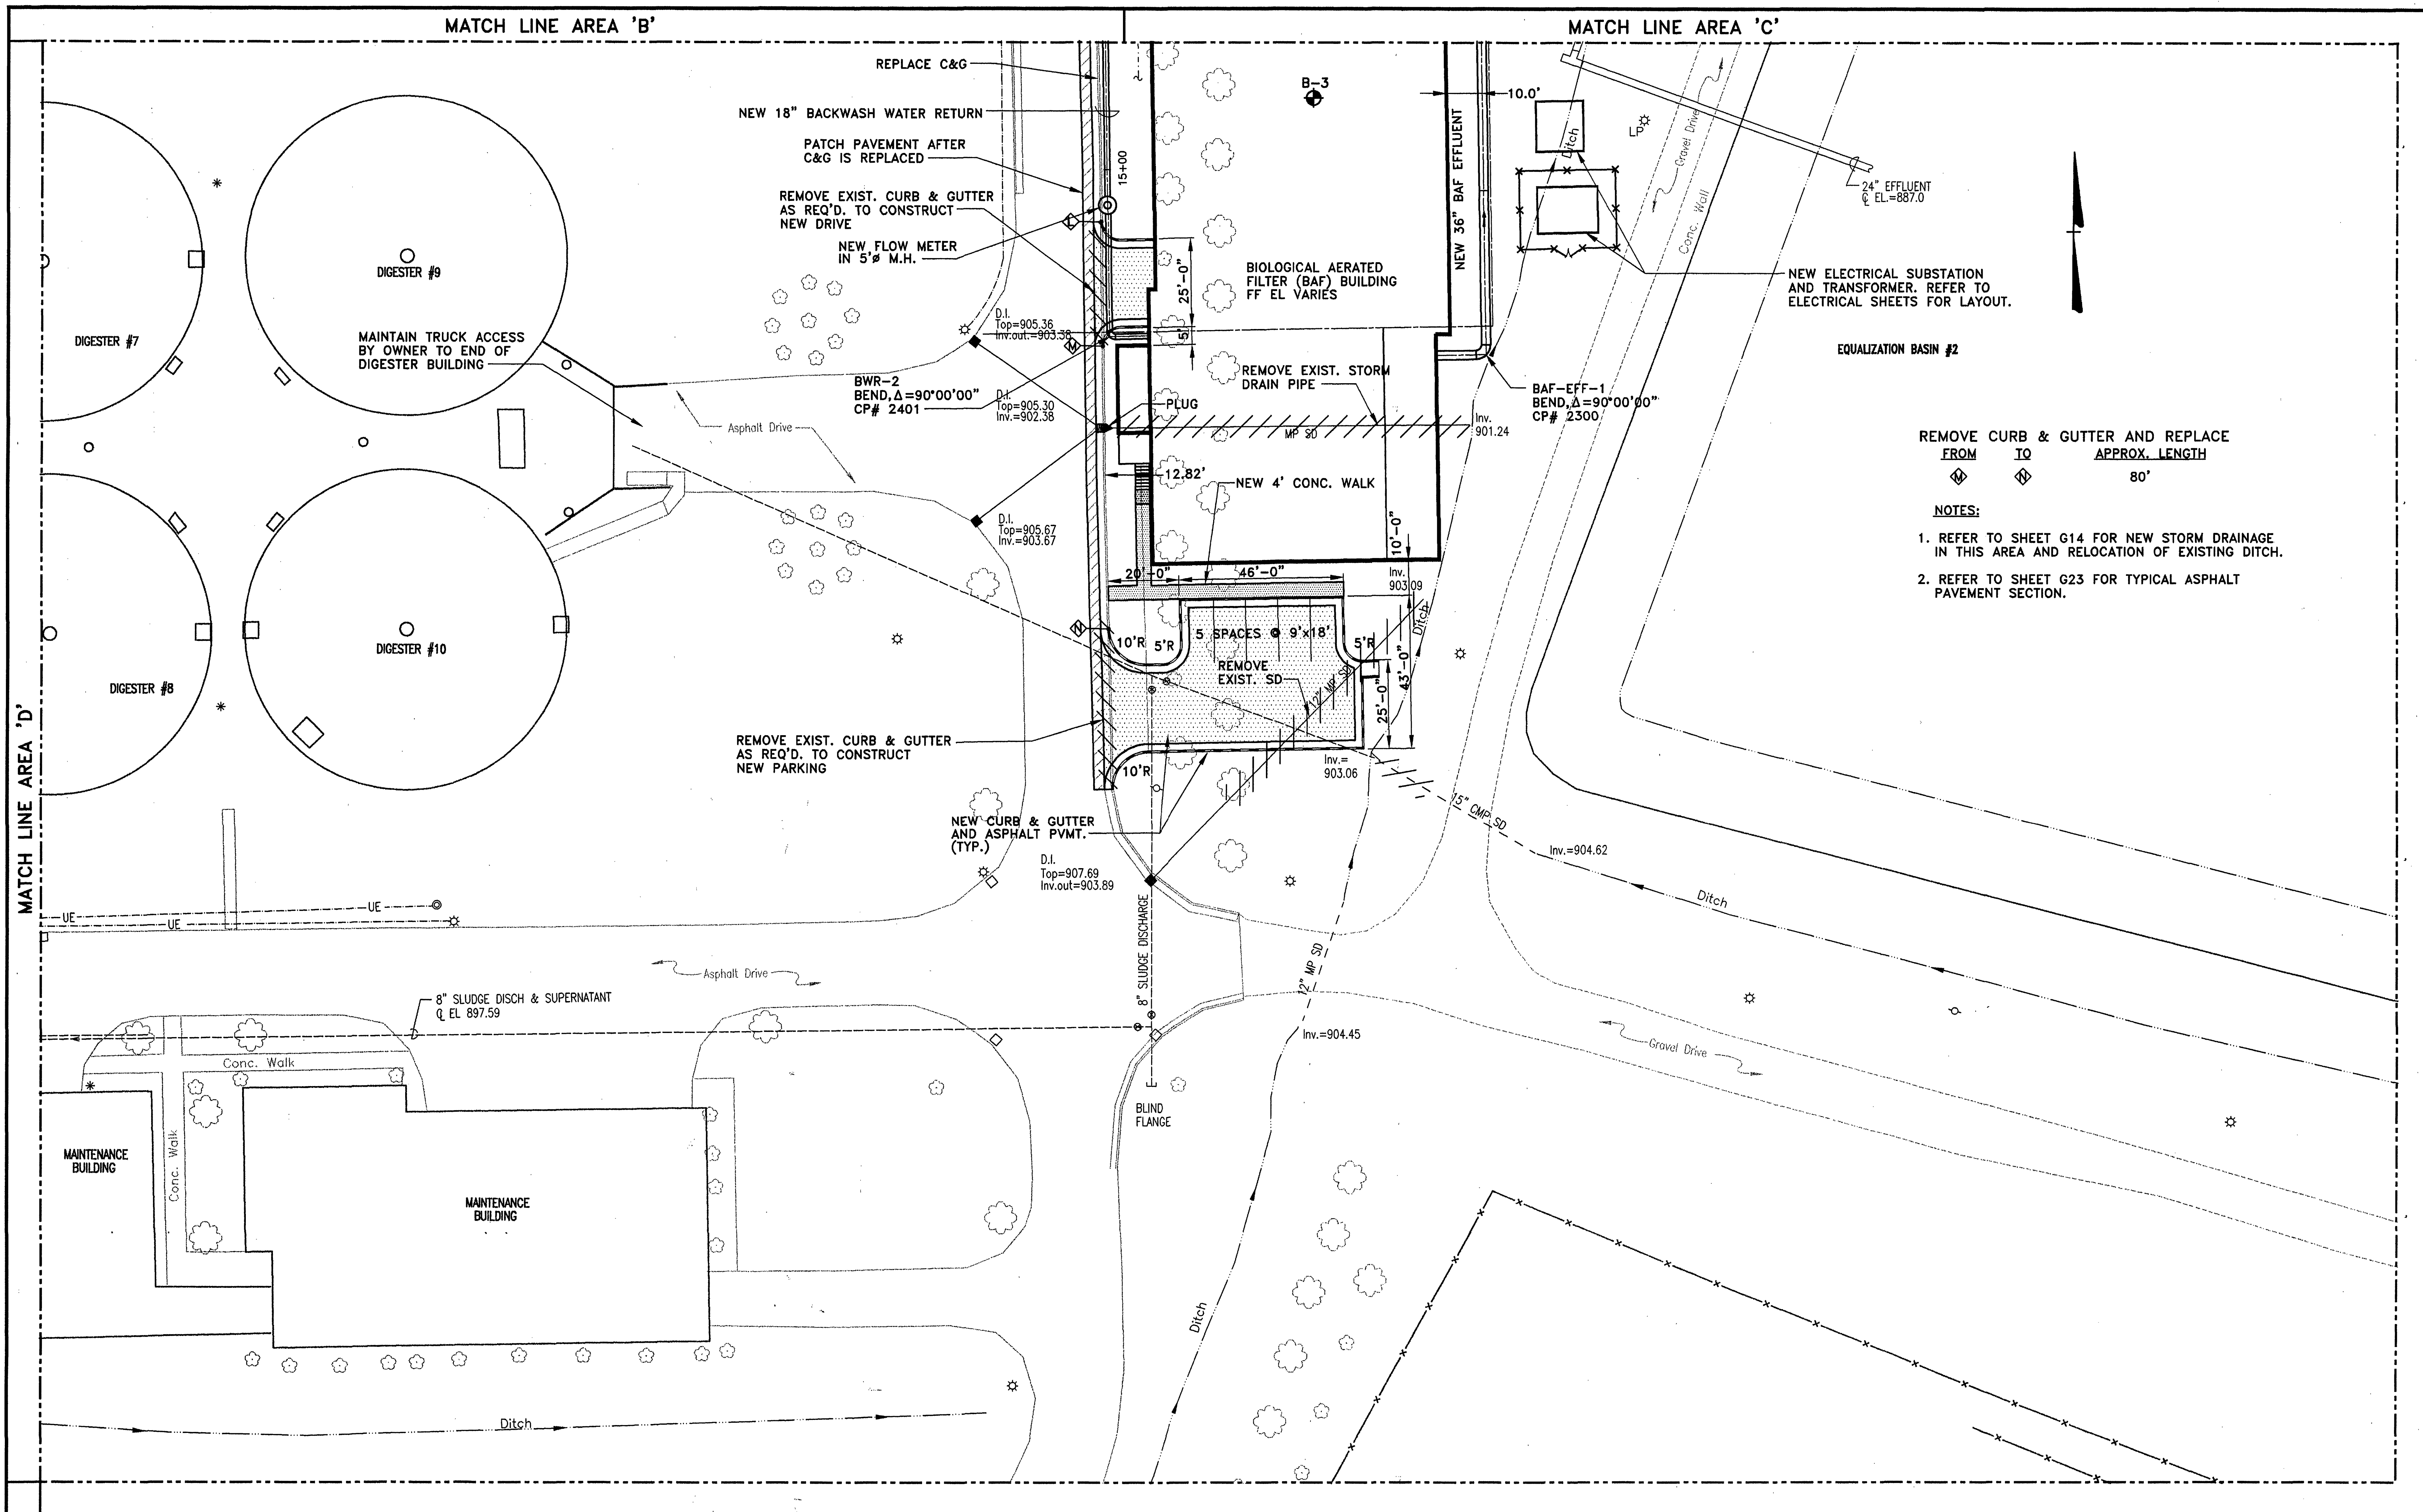

		REVISIONS		DES WTA OWN LDL/ARB CKD SWH		CITY OF ROANOKE, VIRGINIA WATER POLLUTION CONTROL PLANT UPGRADE AND EXPANSION	SITE PLAN LAYOUT, YARD PIPING, AND UTILITIES AREA 'E' 1"=20'	DATE MAY, 1997 G SHEET 8 OF 23 CAD REF. NO. G8.DWG
		NO.	BY					
	1	ARB	JAN. 2000	RECORD DRAWING				

R:\chgs\1385\chgs\081.dwg F:\1 Apr 14 17:48:33 2000