




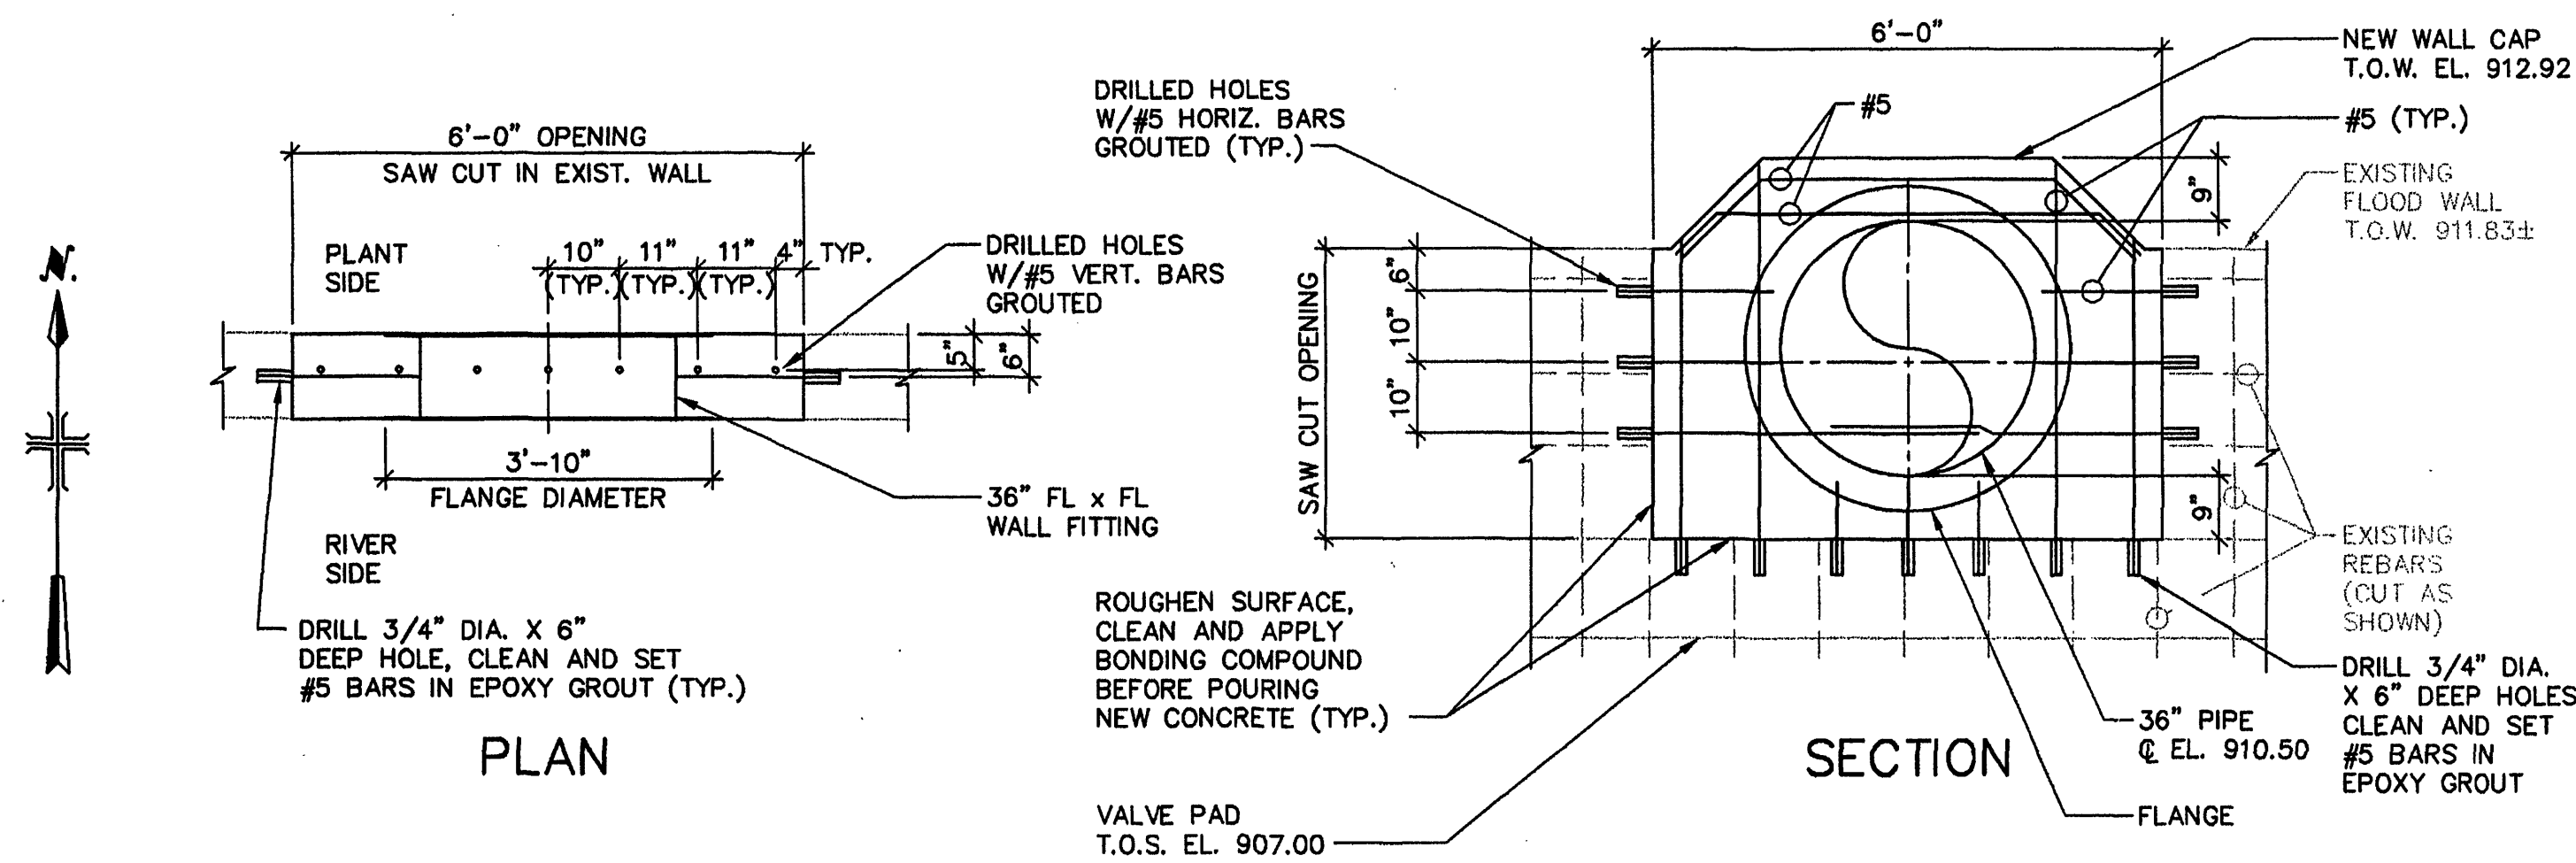


FLOOD WALL PENETRATION DETAIL
SCALE: 1/2" = 1'-0"

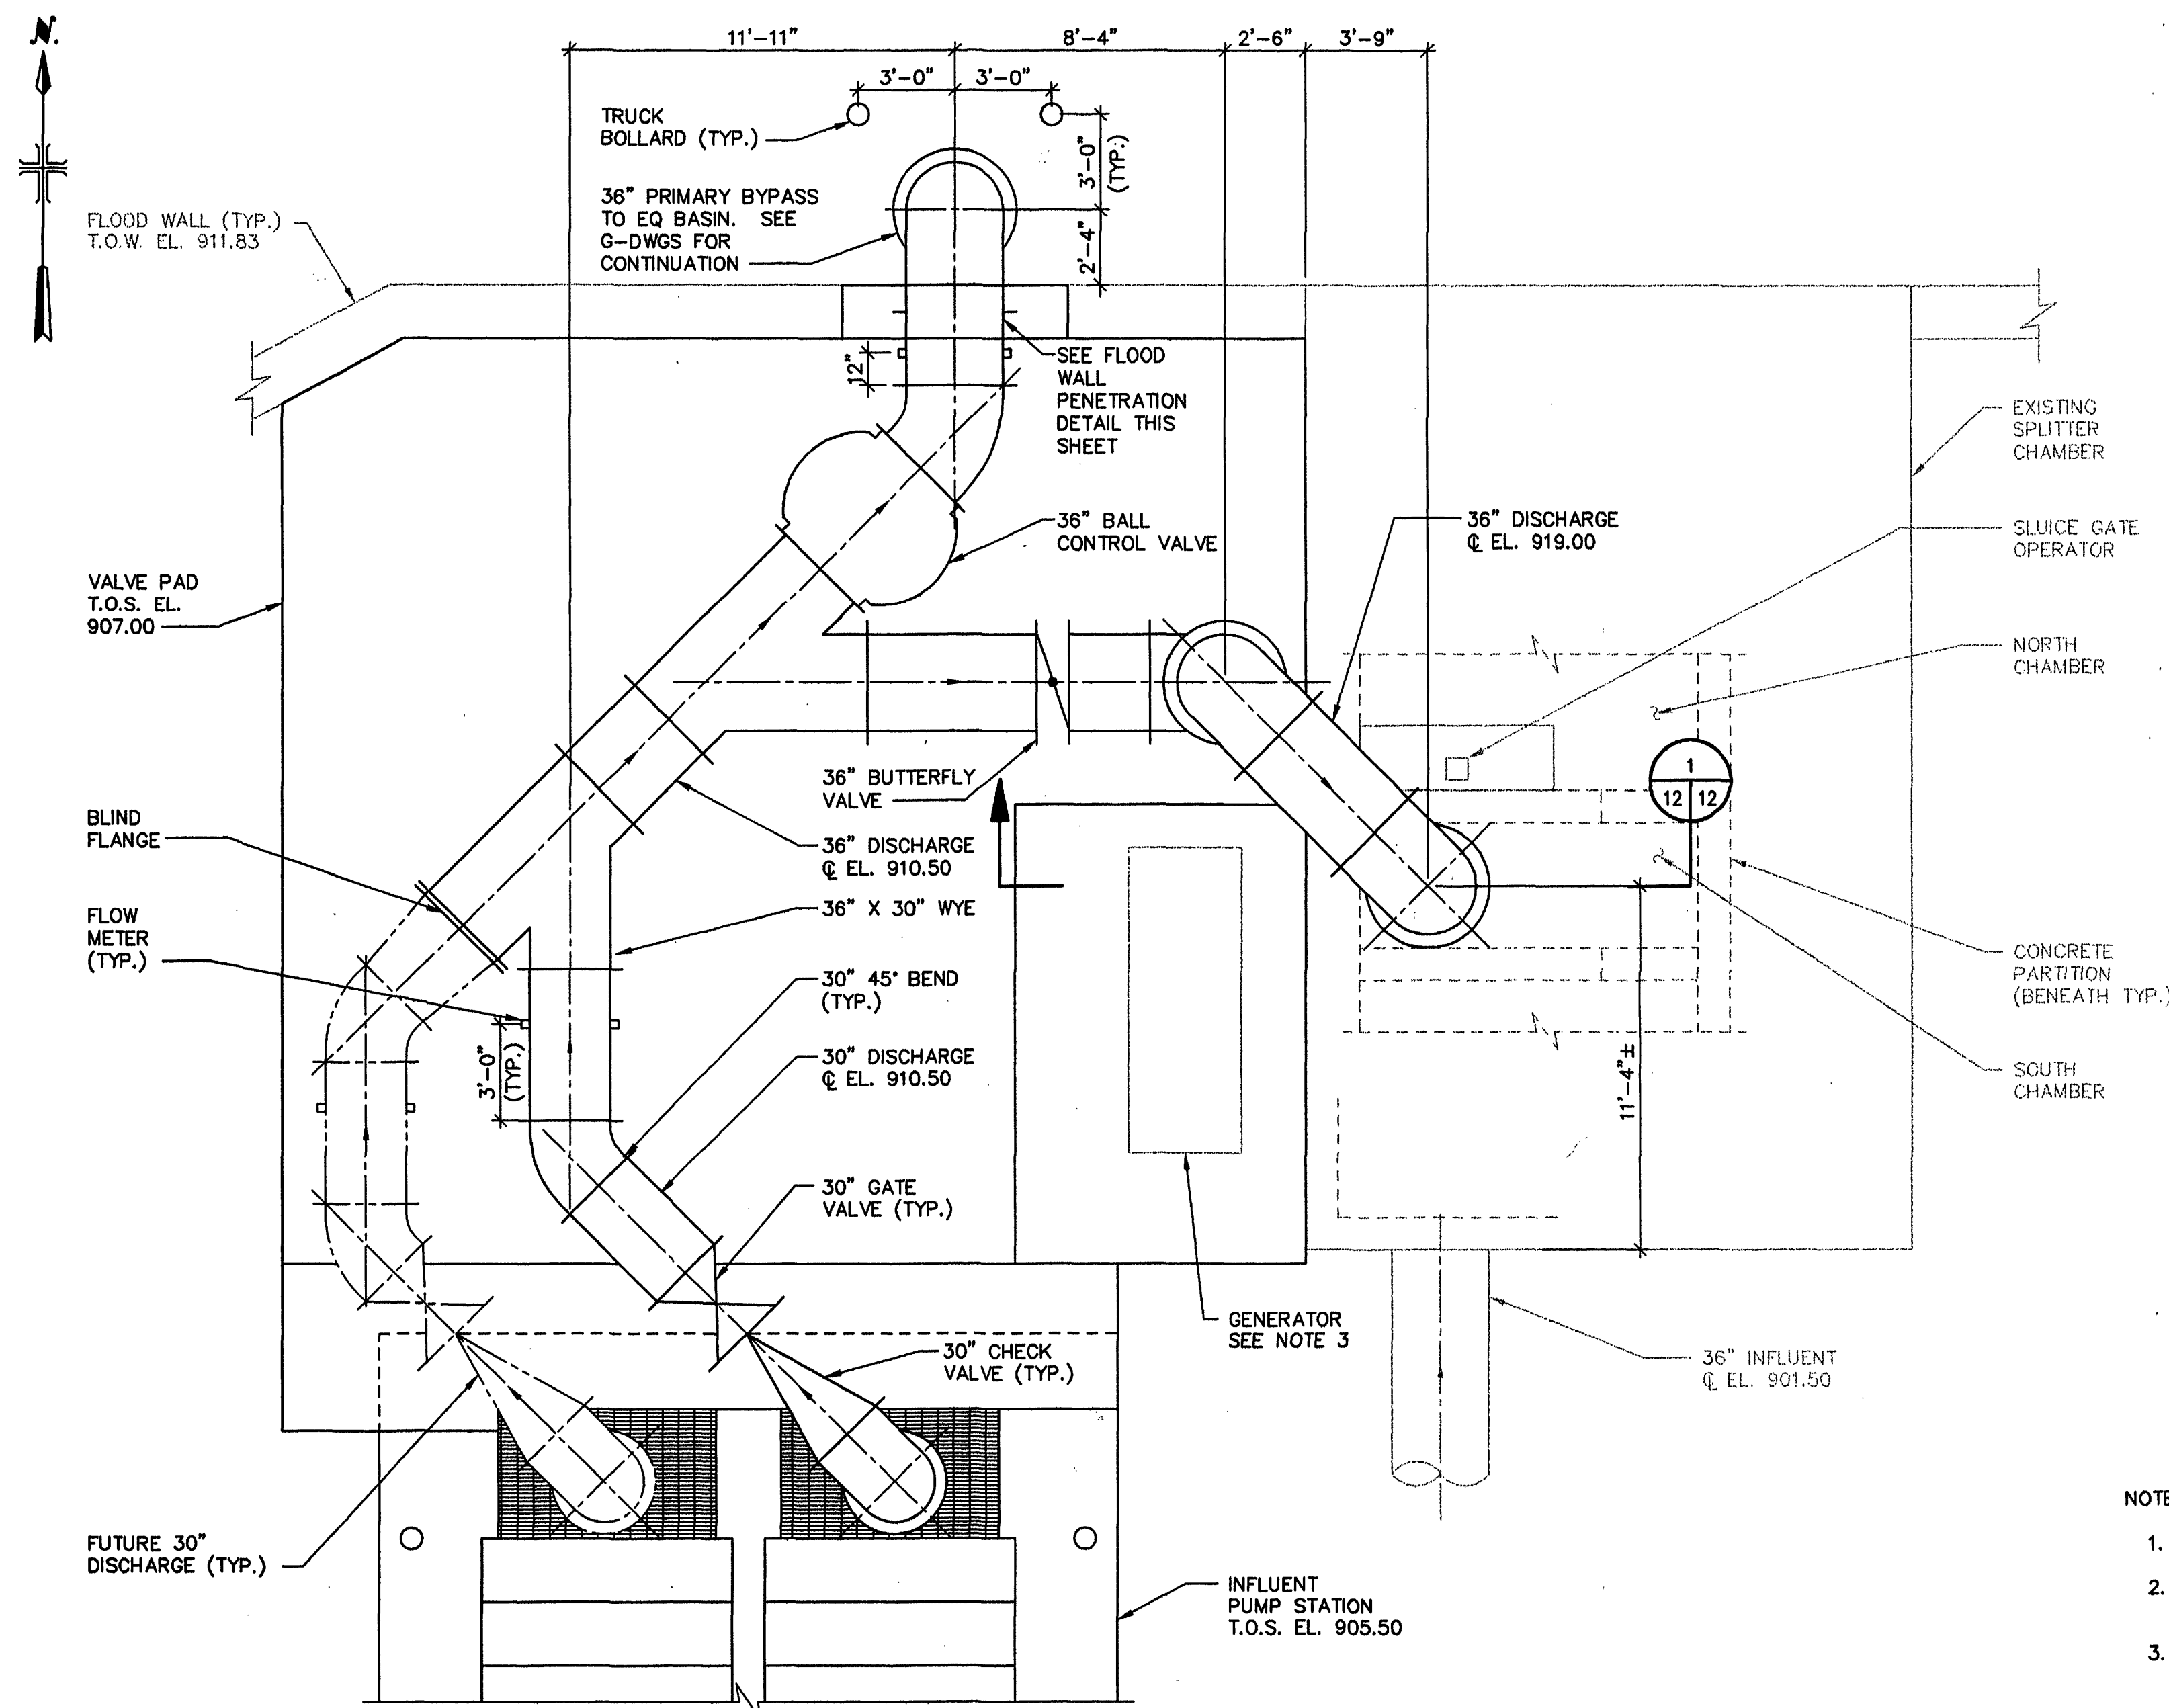

PARTIAL PIPING PLAN @ 905.50

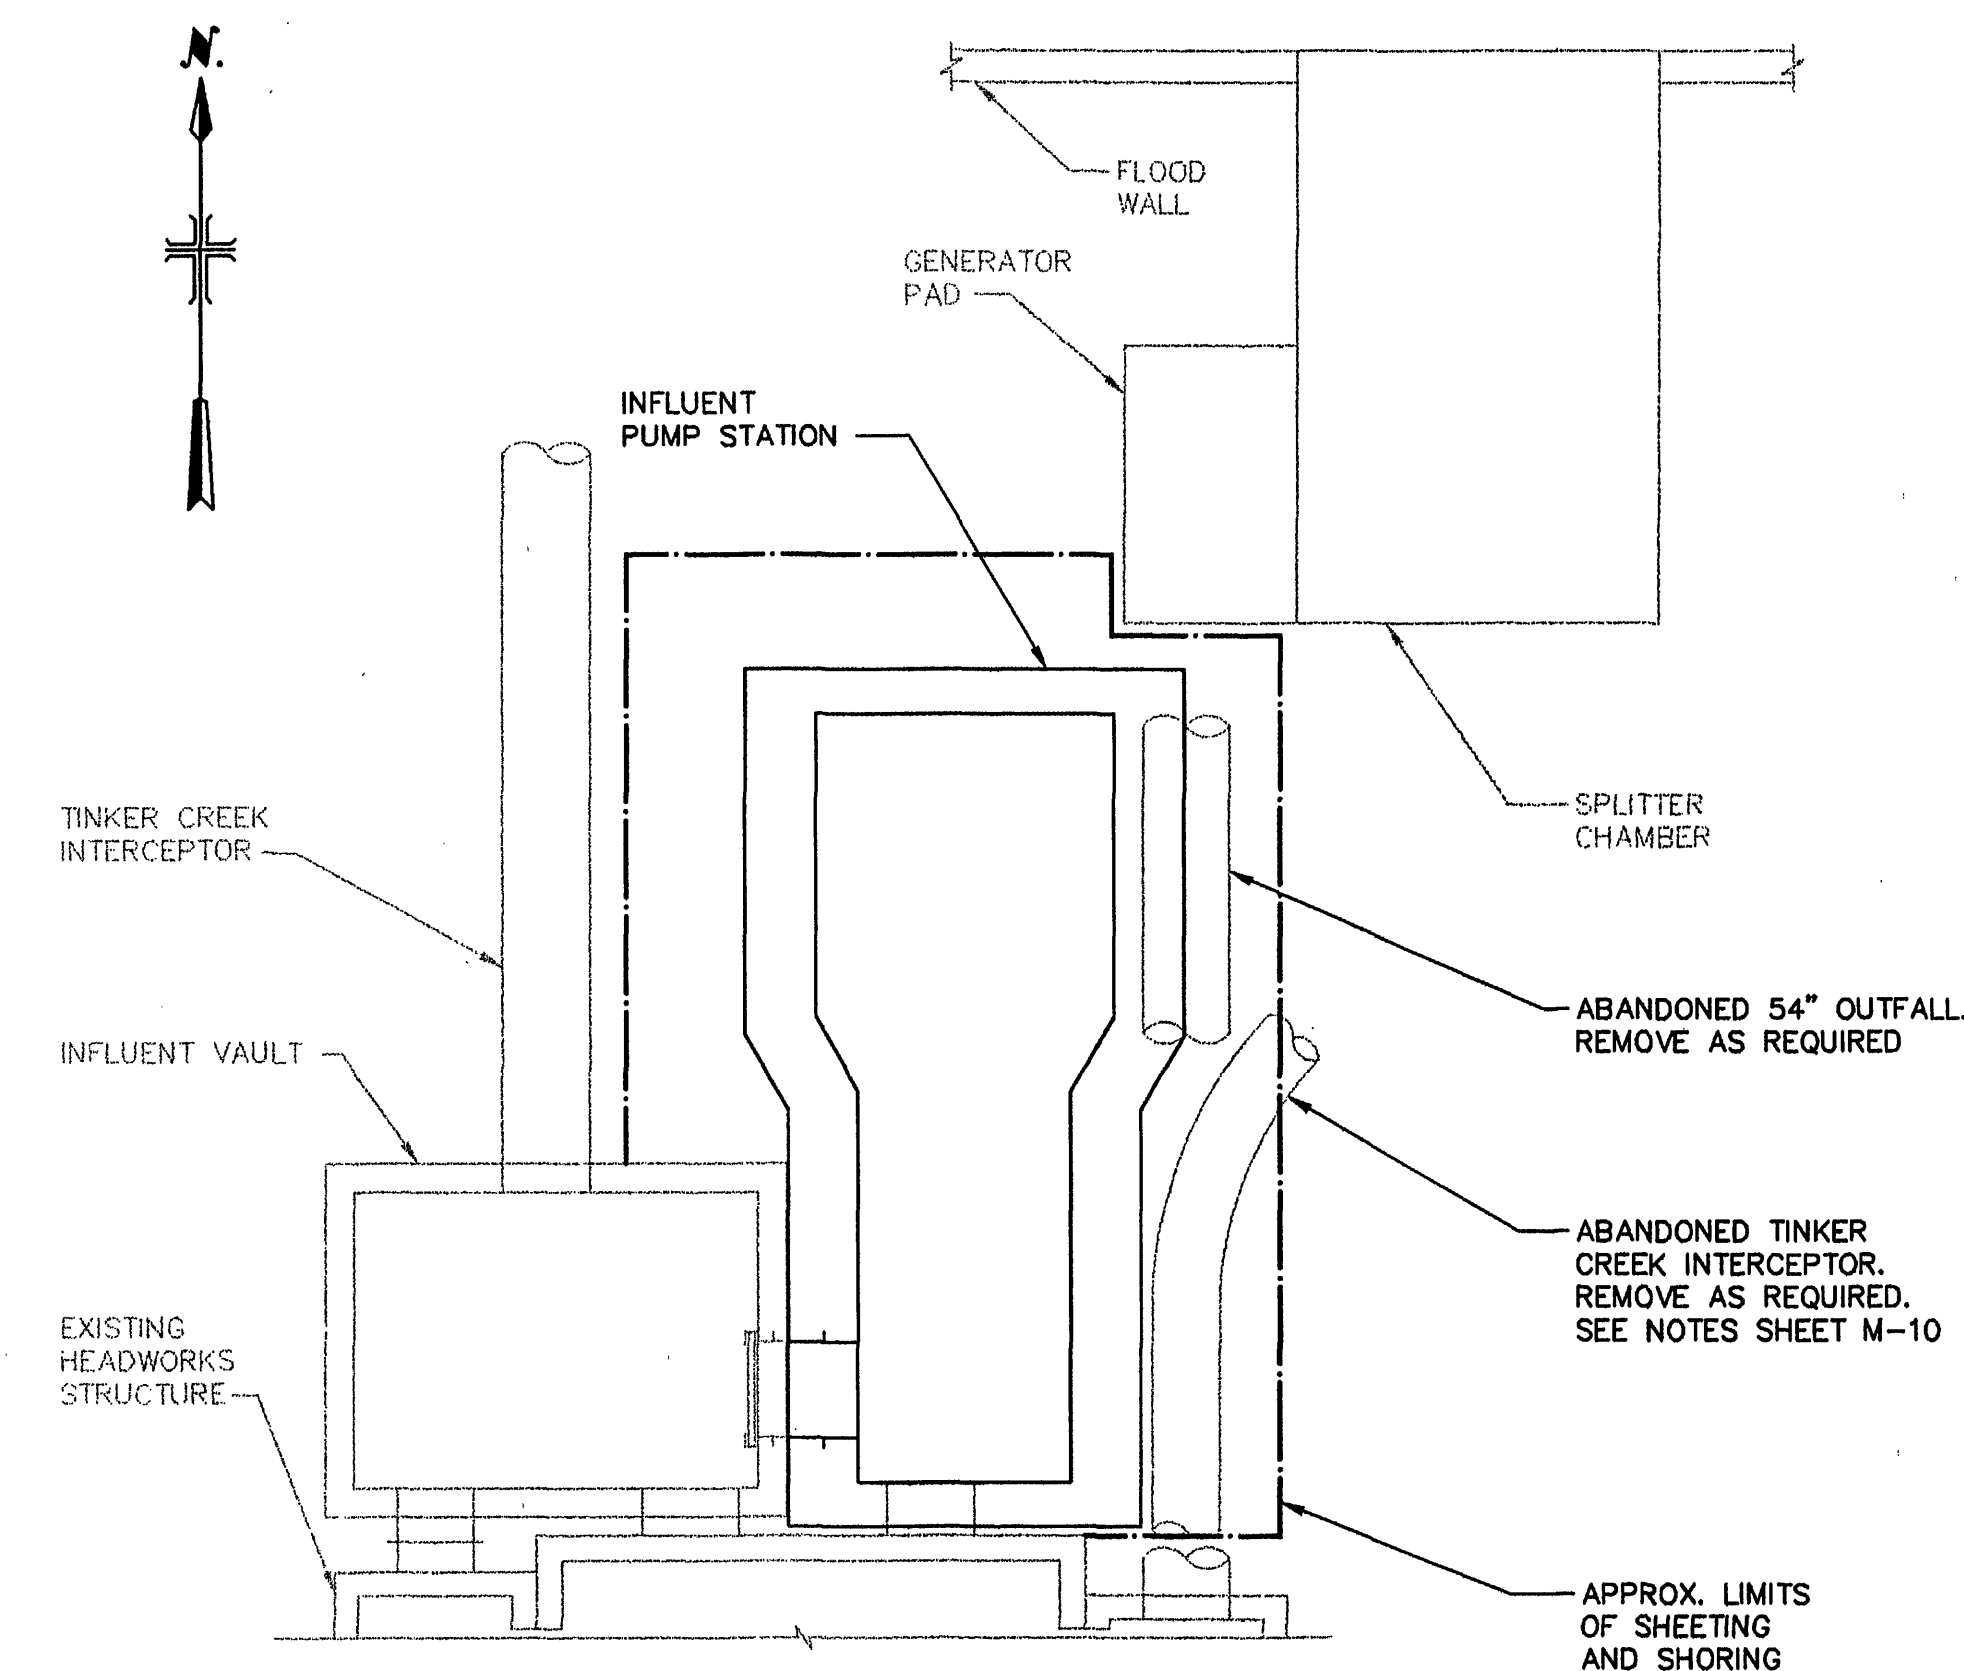

SHEETING AND SHORING PLAN
SCALE: 1" = 10'

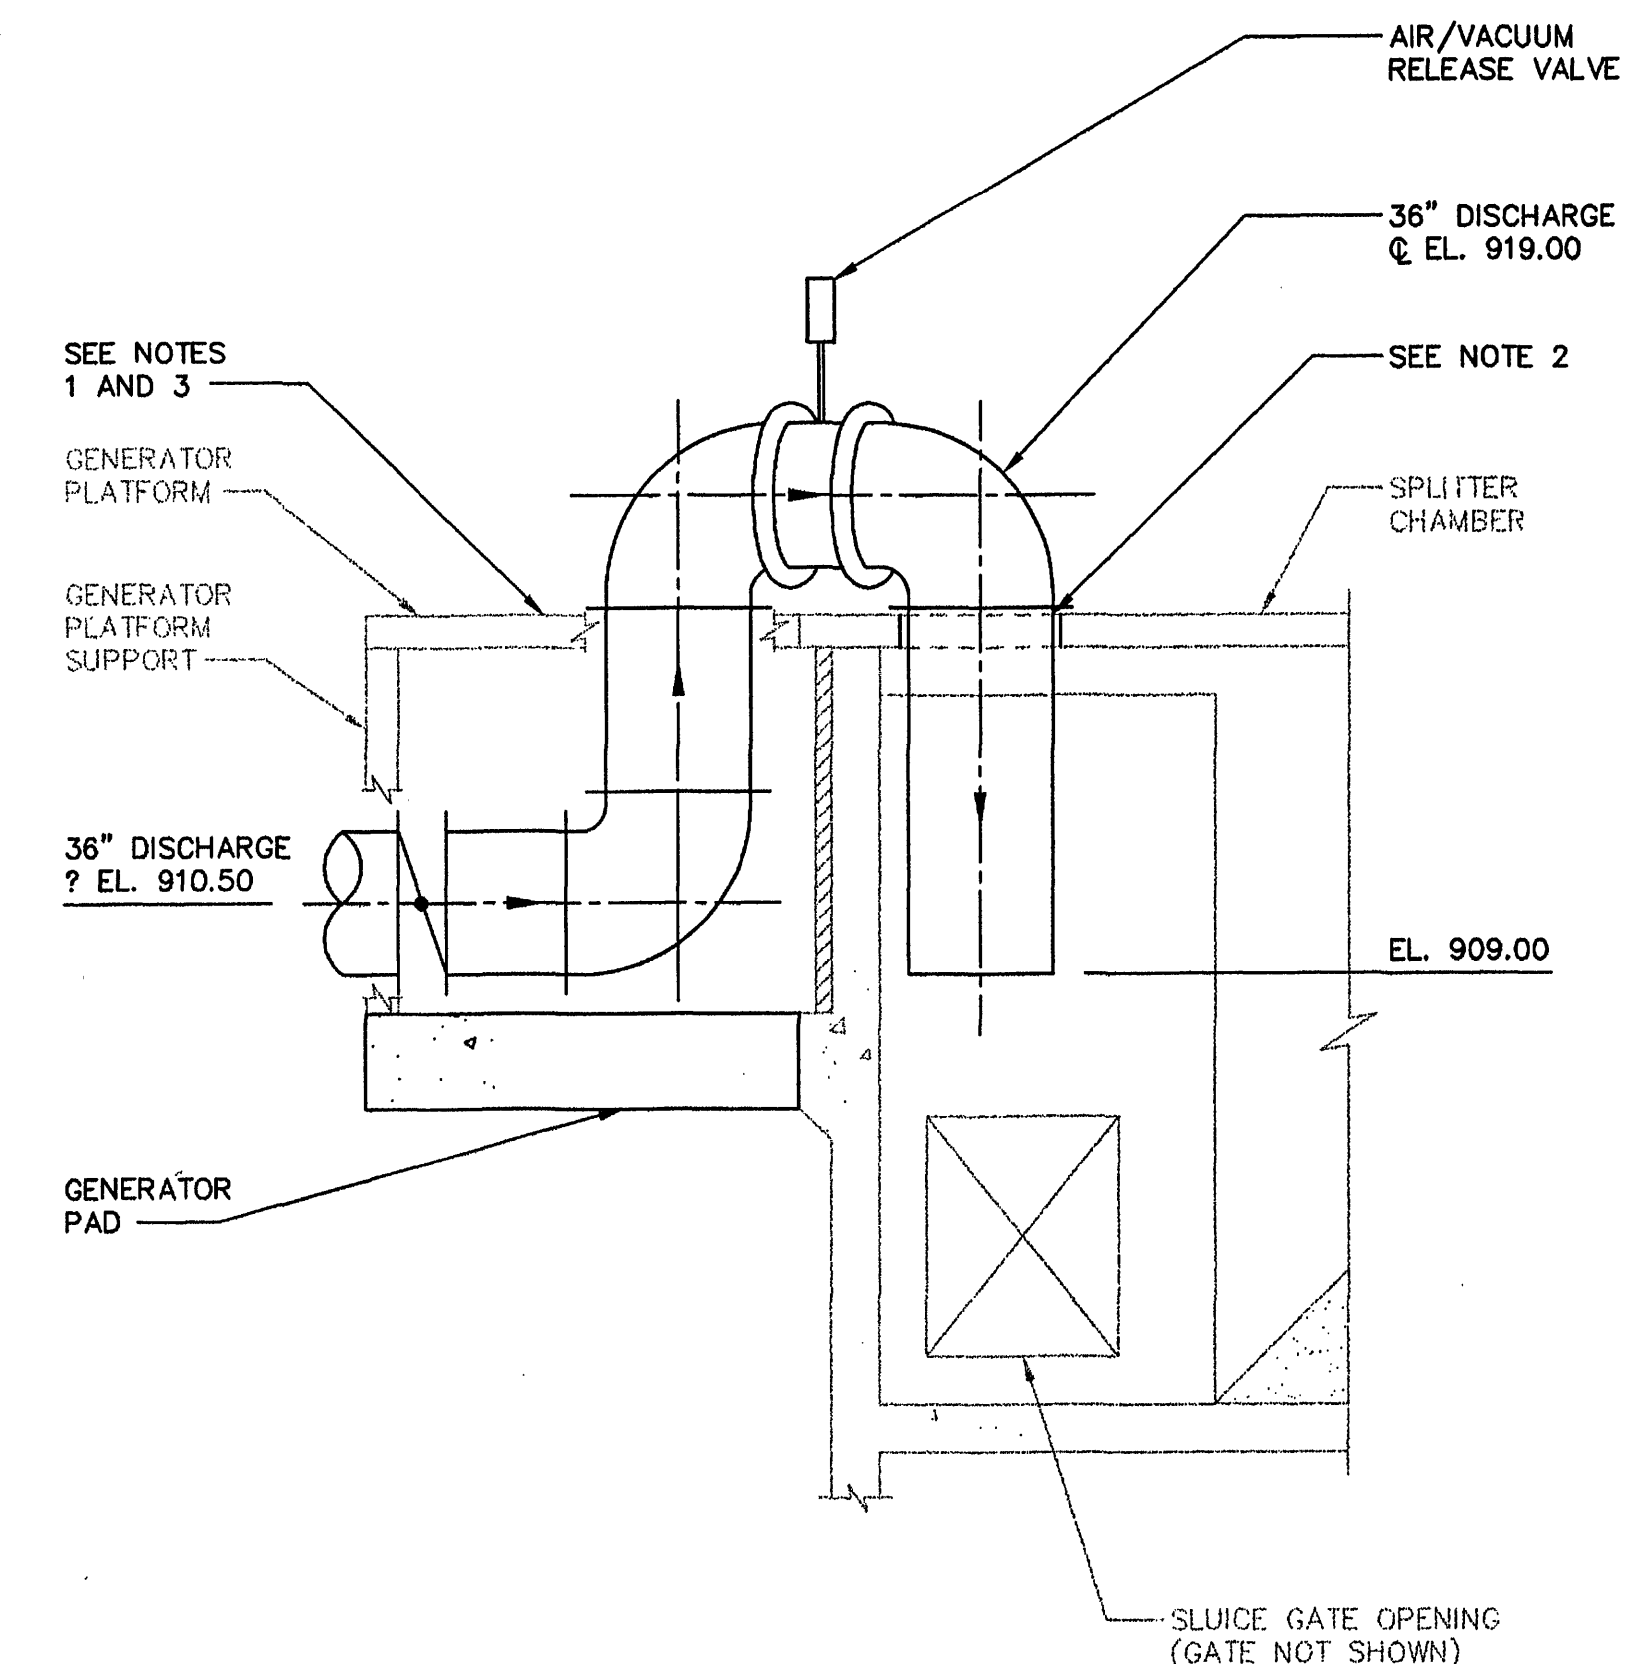

SECTION 1/12

- NOTES:
1. GENERATOR NOT SHOWN FOR CLARITY.
 2. CORE DRILL SLAB AS REQUIRED TO INSTALL 36" DISCHARGE PIPE.
 3. GENERATOR TO BE RELOCATED DURING CONSTRUCTION. GENERATOR PLATFORM SHALL BE REINSTALLED AFTER NEW PAD IS CONSTRUCTED. SEE SPECIFICATION SECTION 01014 FOR DETAILS.

**MALCOLM
PIRNIE**
11832 Rock Landing Drive, Suite 400
Newport News, Virginia, 23606

NO.	BY	DATE	REVISIONS	REMARKS
1	ARB	JAN. 2000	RECORD DRAWING	

DES CWM/DB
DWN CWM/WE
CKD GJJ



CITY OF ROANOKE, VIRGINIA
WATER POLLUTION
CONTROL PLANT
UPGRADE AND EXPANSION

PLANT INFLUENT PUMP STATION
PARTIAL PLANS, SECTION AND DETAIL
SCALE: 1/4" = 1'-0" U.O.N.

COPYRIGHT © 1997
MALCOLM PIRNIE, INC.
DATE MAY 1997
M SHEET 12 OF 30
CAD REF. NO. 0060M012