



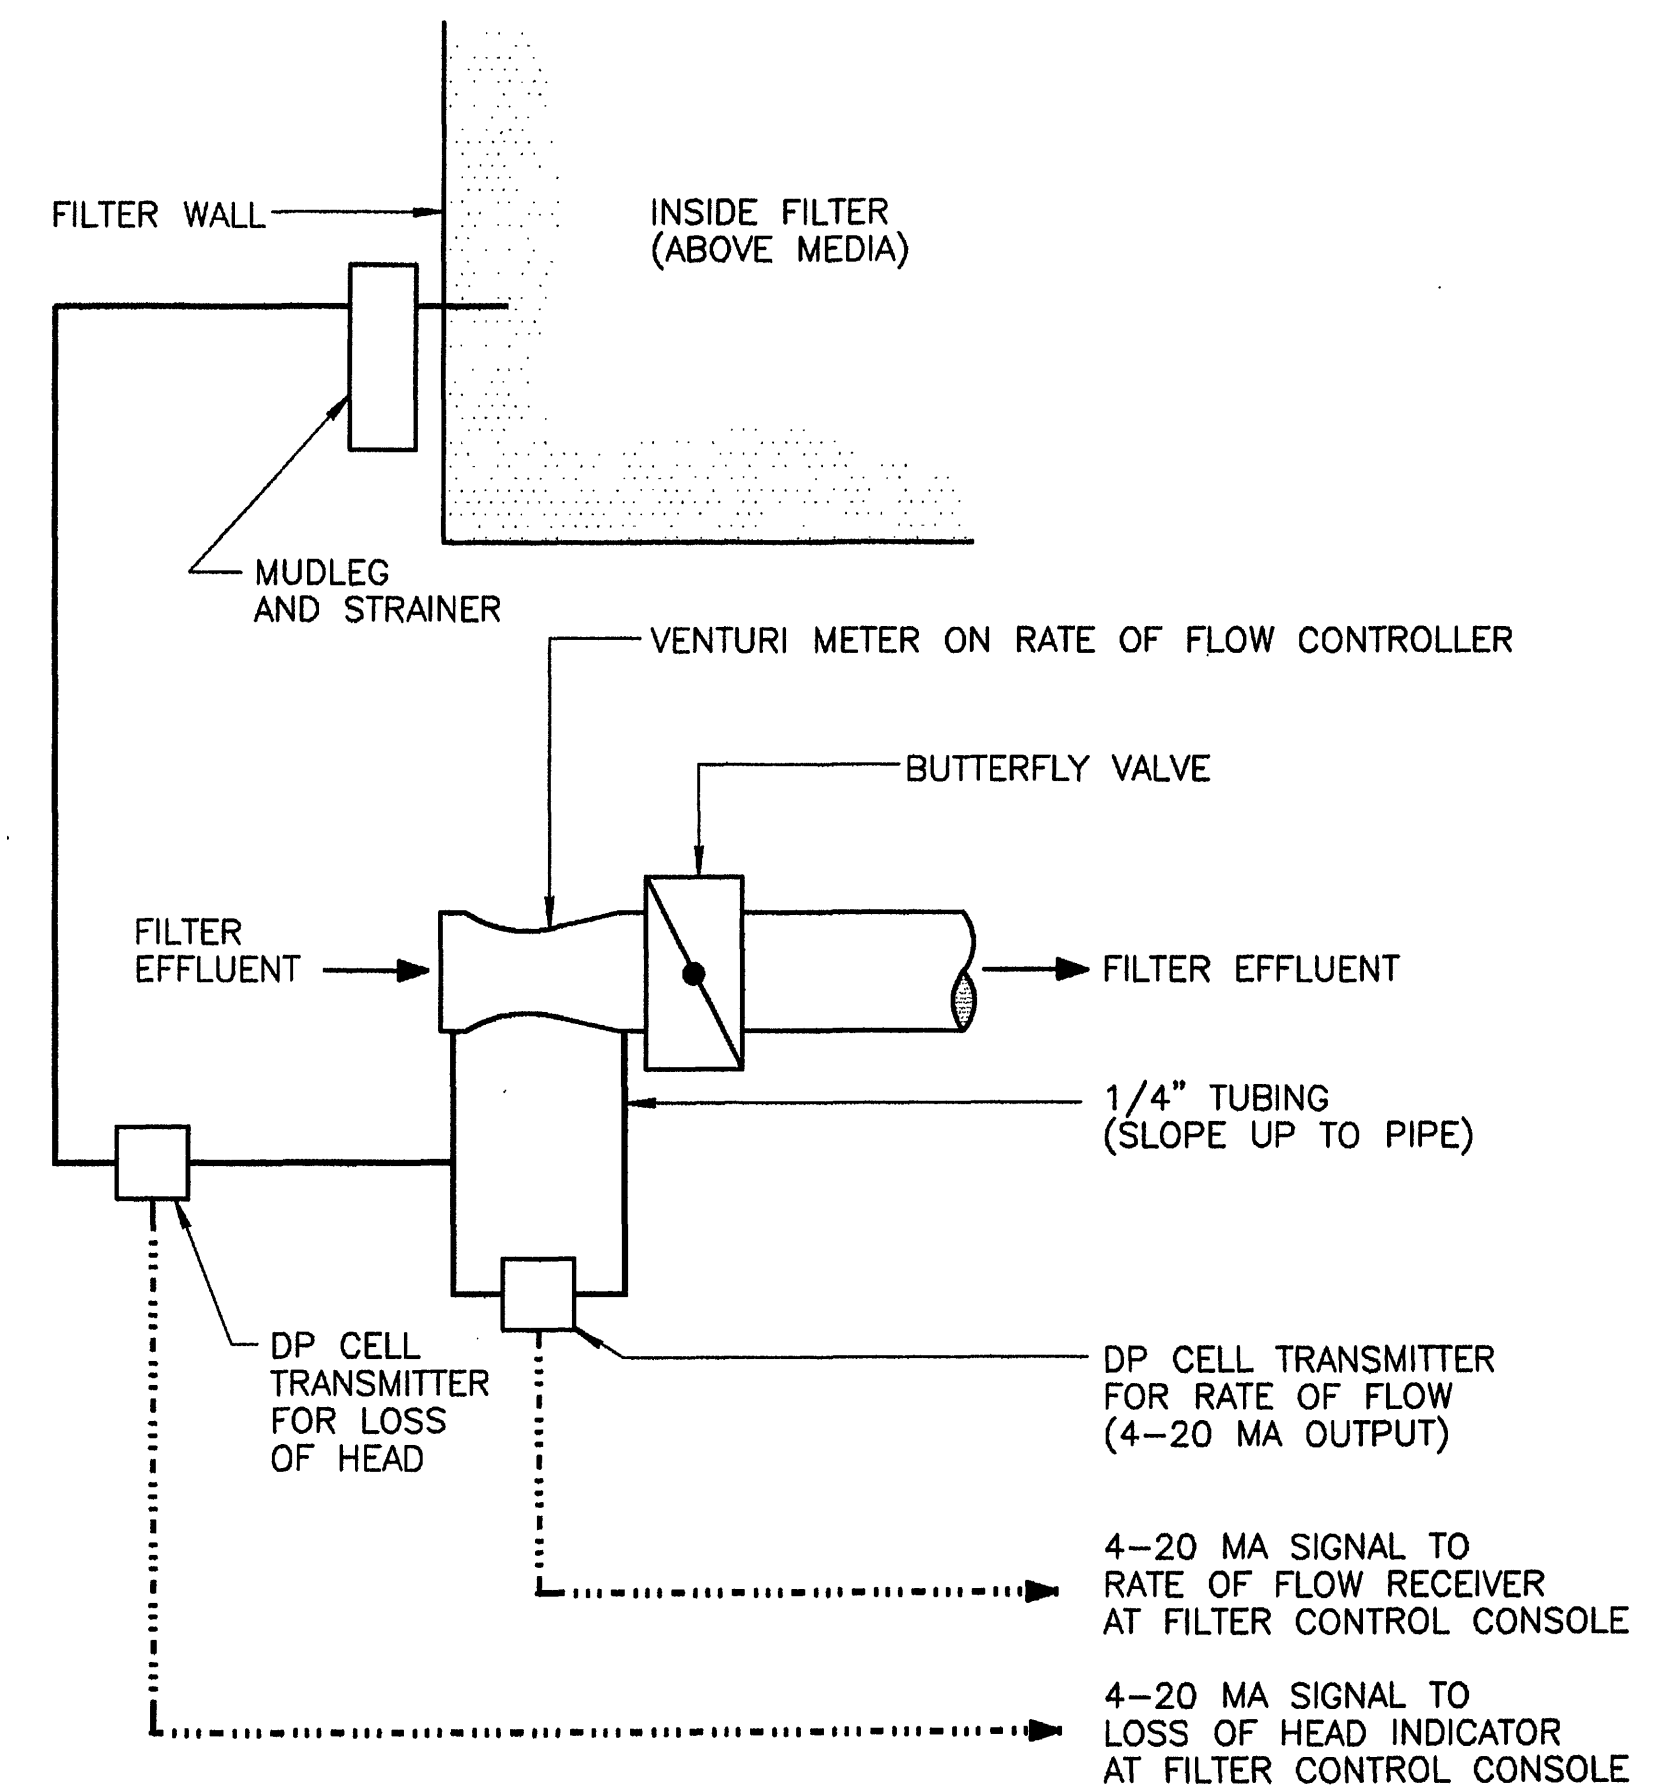


FILTER CONTROLS SCHEMATIC

SCALE: NONE

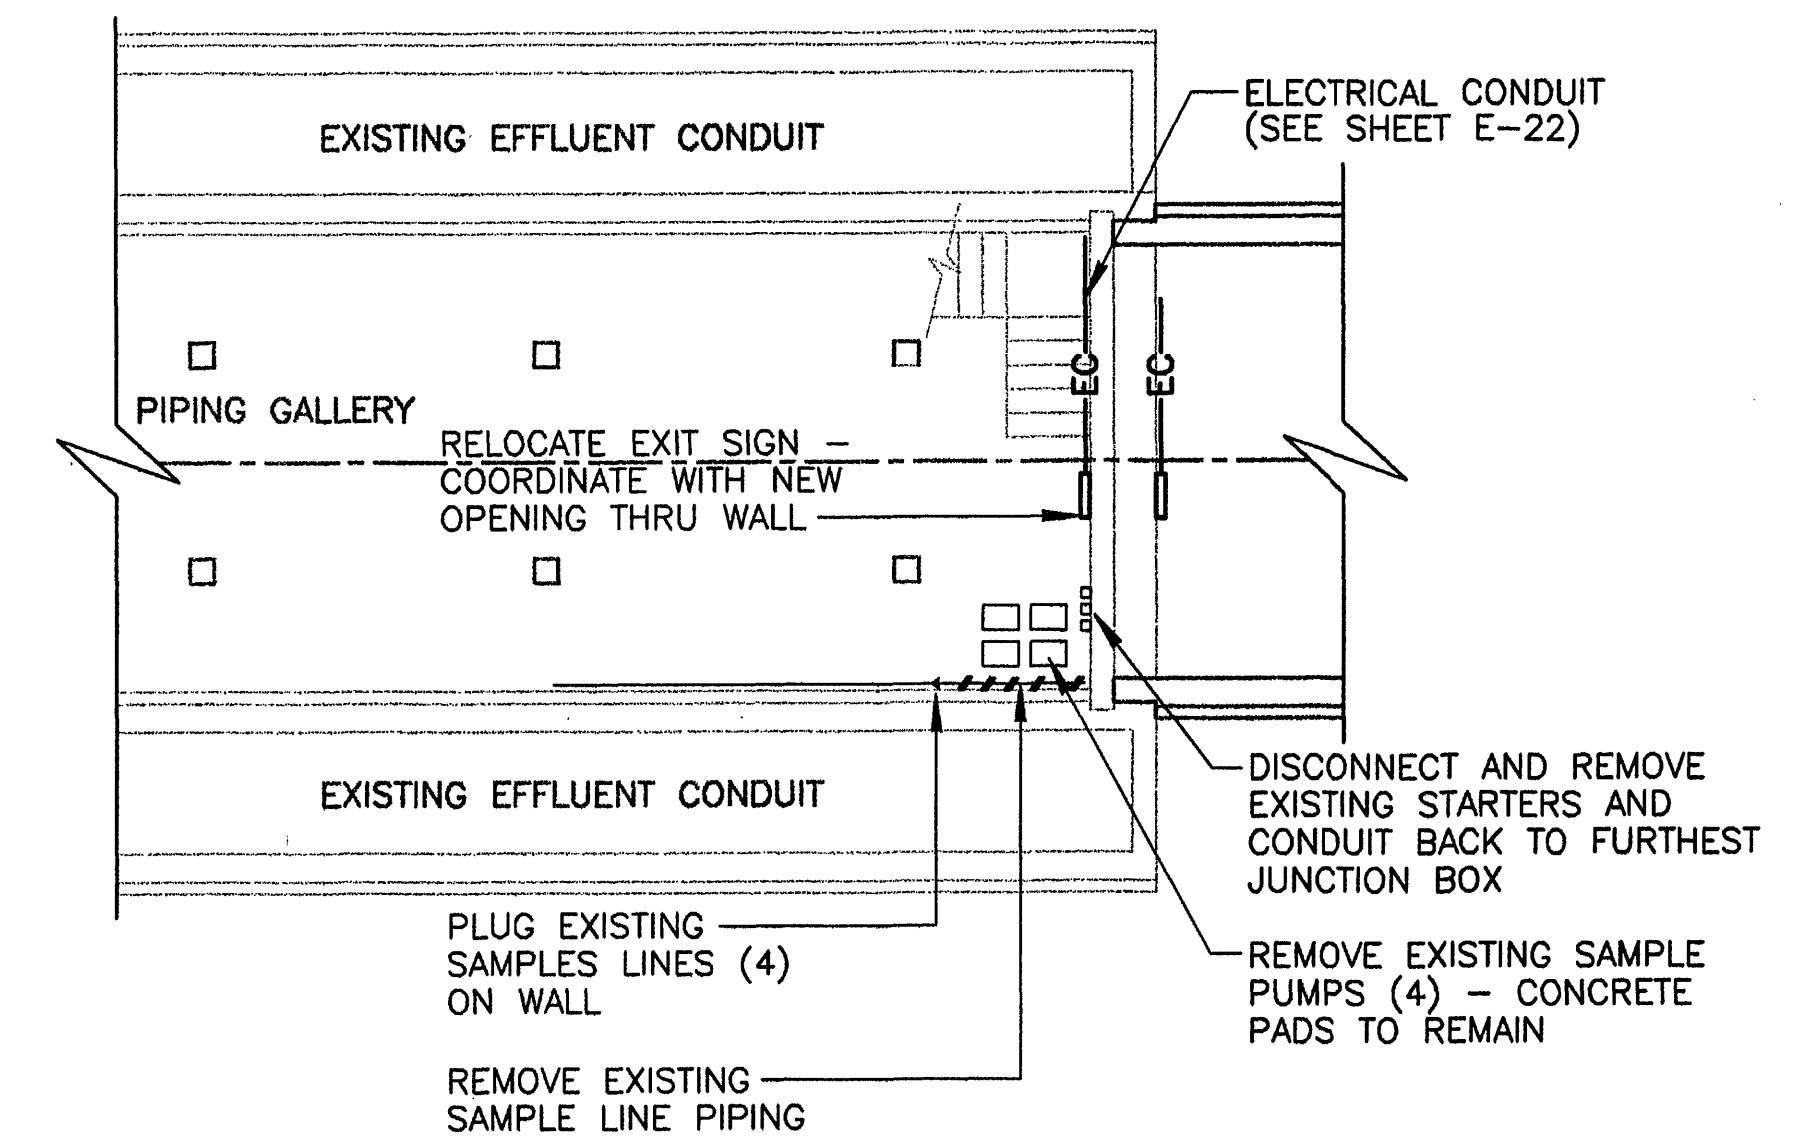

MODIFICATIONS TO SAMPLE PUMPS

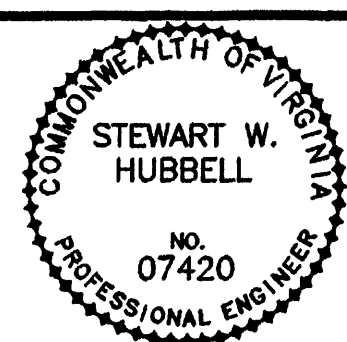

Mattern & Craig, Inc.
CONSULTING ENGINEERS • SURVEYORS
701 FIRST STREET, S.W.
ROANOKE, VIRGINIA 24004
800 545-2666
540 545-2661 FAX

REVISIONS			
NO.	BY	DATE	REMARKS
1	ARB	JAN. 2000	RECORD DRAWING

DES --- WTA
DWN --- LDL, ARB
CKD --- SWH



CITY OF ROANOKE, VIRGINIA
**WATER POLLUTION
CONTROL PLANT
UPGRADE AND EXPANSION**

EFFLUENT FILTERS
MISCELLANEOUS DETAILS
SCALE: AS SHOWN

DATE --- MAY, 1997
M SHEET 20 OF 30
CAD REF. NO. --- M20.DWG