


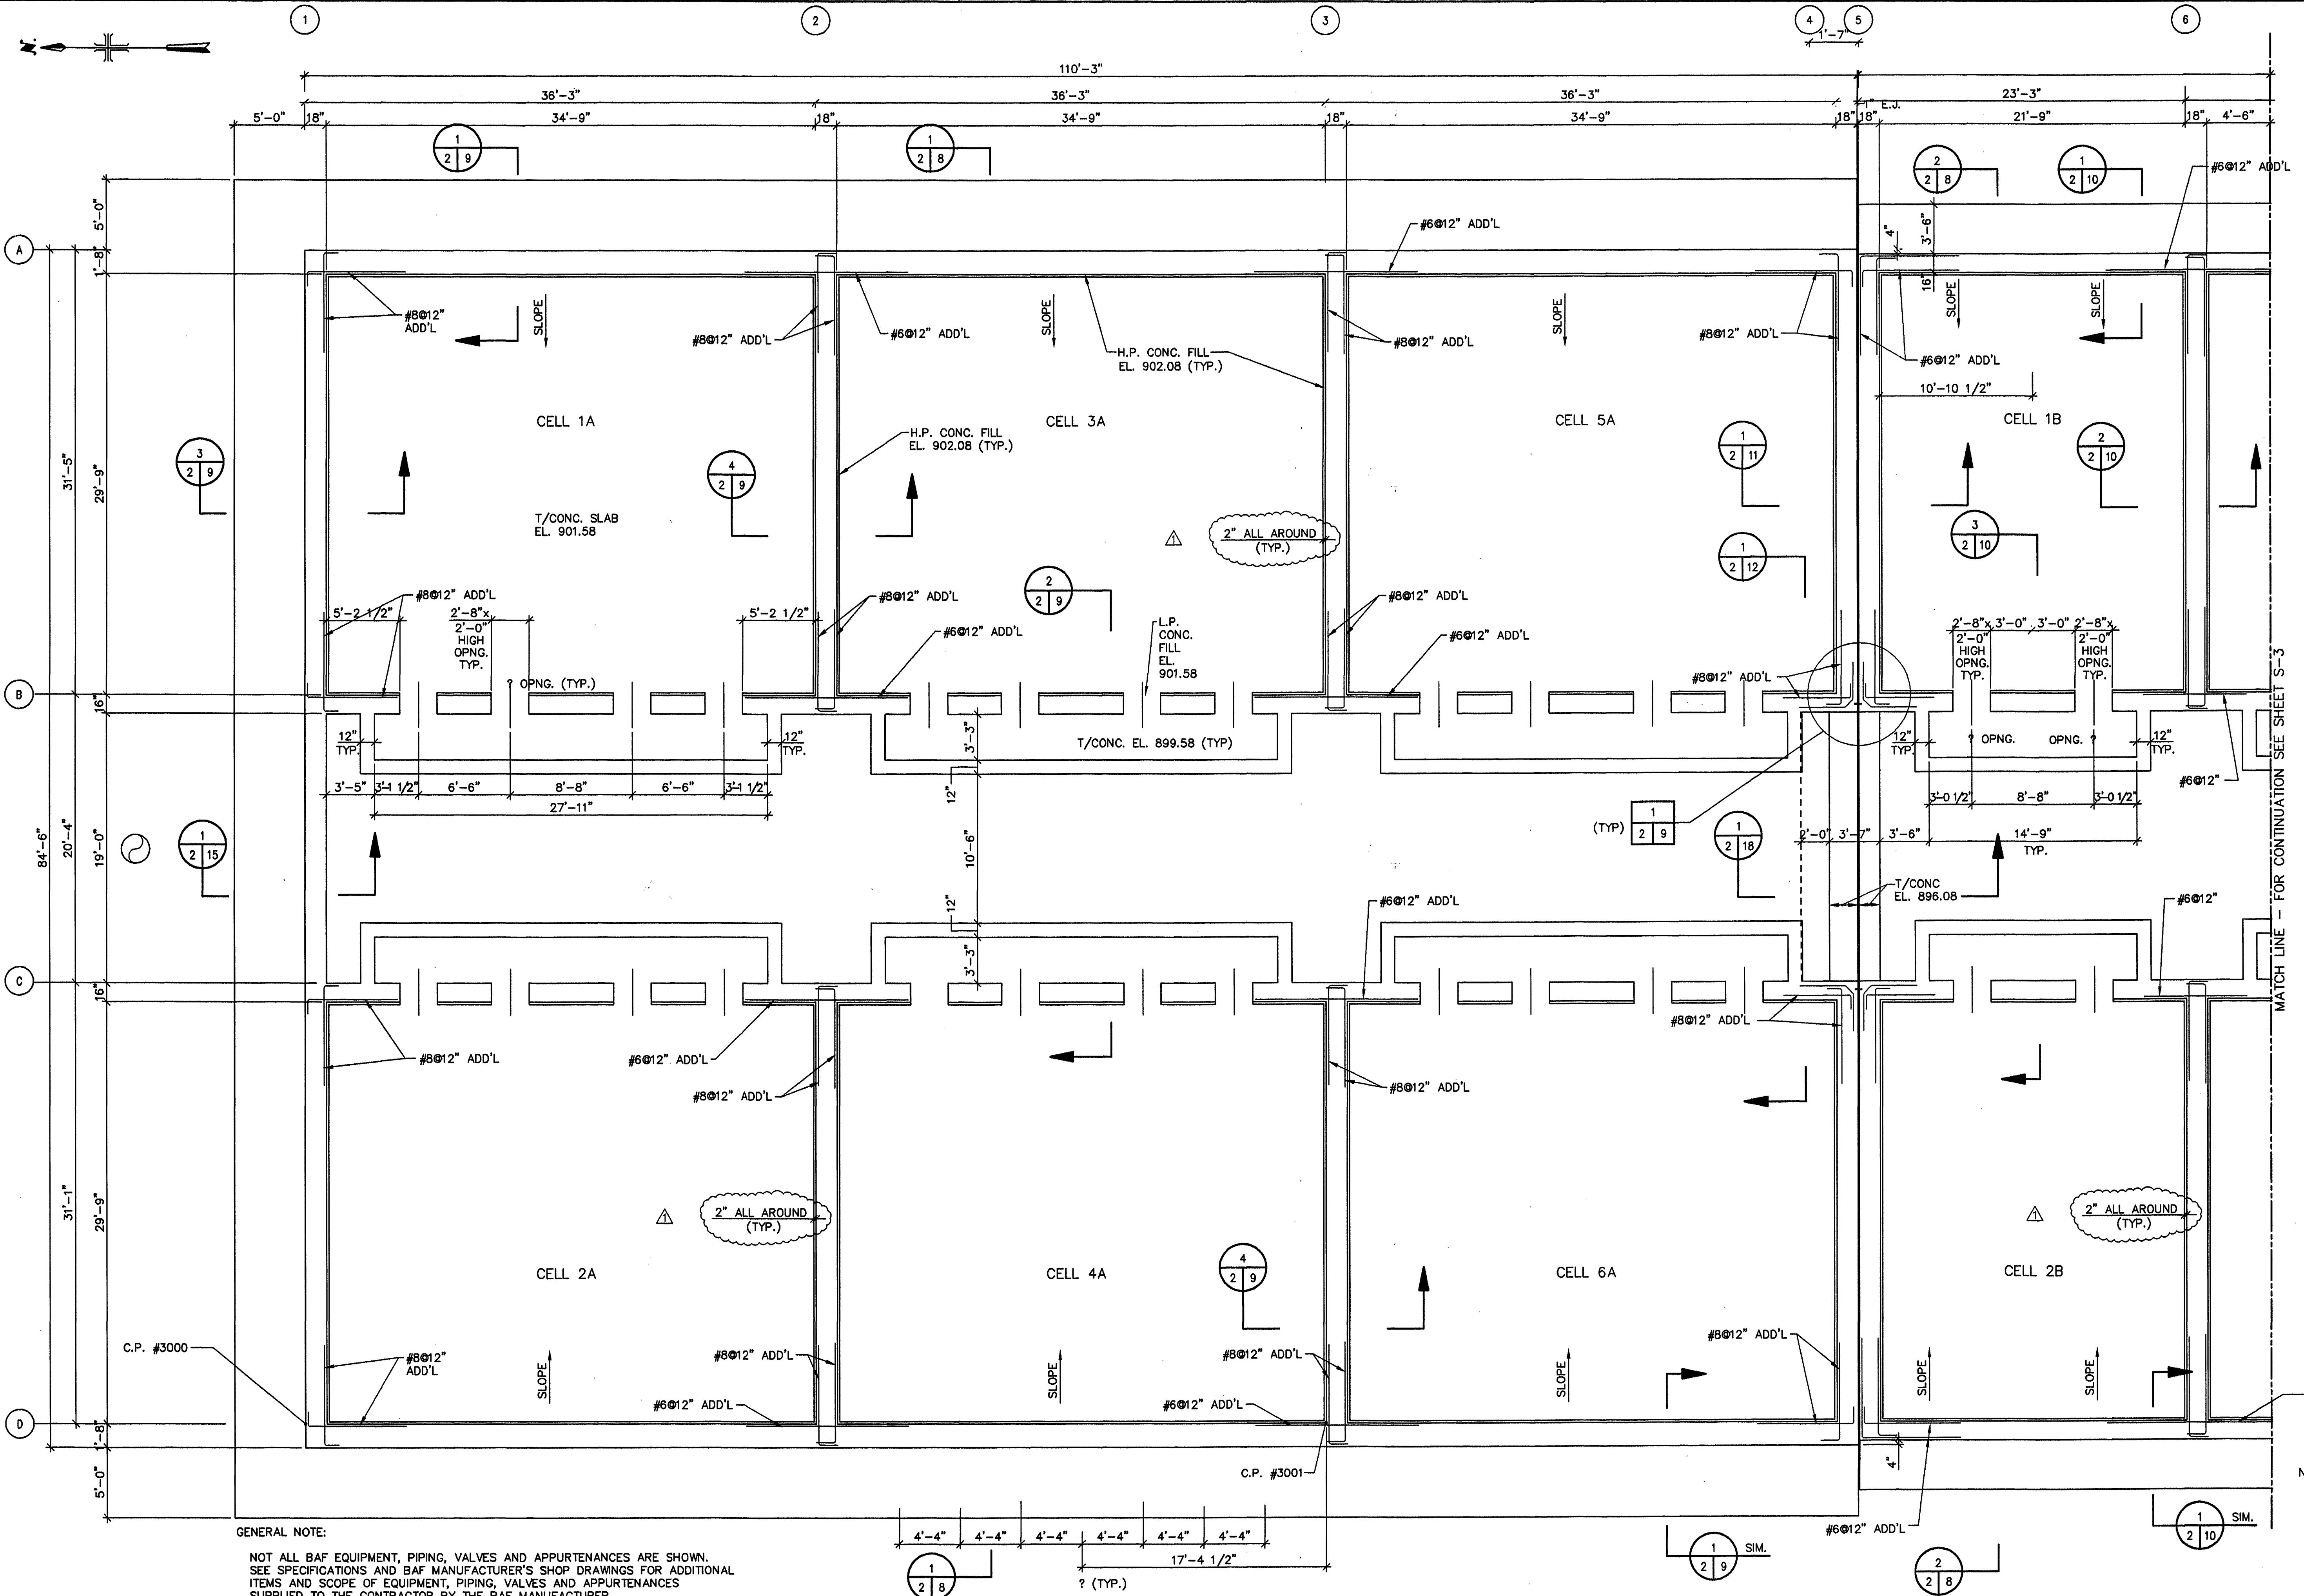

GENERAL NOTE:
NOT ALL BAF EQUIPMENT, PIPING, VALVES AND APPURTENANCES ARE SHOWN.
SEE SPECIFICATIONS AND BAF MANUFACTURER'S SHOP DRAWINGS FOR ADDITIONAL
ITEMS AND SCOPE OF EQUIPMENT, PIPING, VALVES AND APPURTENANCES
SUPPLIED TO THE CONTRACTOR BY THE BAF MANUFACTURER.

NOTE: FOR NOTES SEE
SHEET S-3

**MALCOLM
PIRNIE**
11832 Rock Landing Drive, Suite 400
Newport News, Virginia 23606

REVISIONS				REMARKS
NO.	BY	DATE		
1	ARB	JAN. 2000		RECORD DRAWING

DES --- MZ ---
DWN --- CBM ---
CKD --- DB ---



CITY OF ROANOKE, VIRGINIA
**WATER POLLUTION
CONTROL PLANT
UPGRADE AND EXPANSION**

**BIOLOGICAL AERATED FILTER
FOUNDATION PLAN
SHEET 1**
SCALE: 3/16"=1'-0"

COPYRIGHT © 1997
MALCOLM PIRNIE, INC.
DATE --- MAY 1997 ---
S SHEET 2 OF 44
CAD REF. NO. 00603352

4873 0060028592 I:\CAD\PROJ\00600285\00605352 Scale: 1:11 Date: 05/01/1997 Time: 08:31