



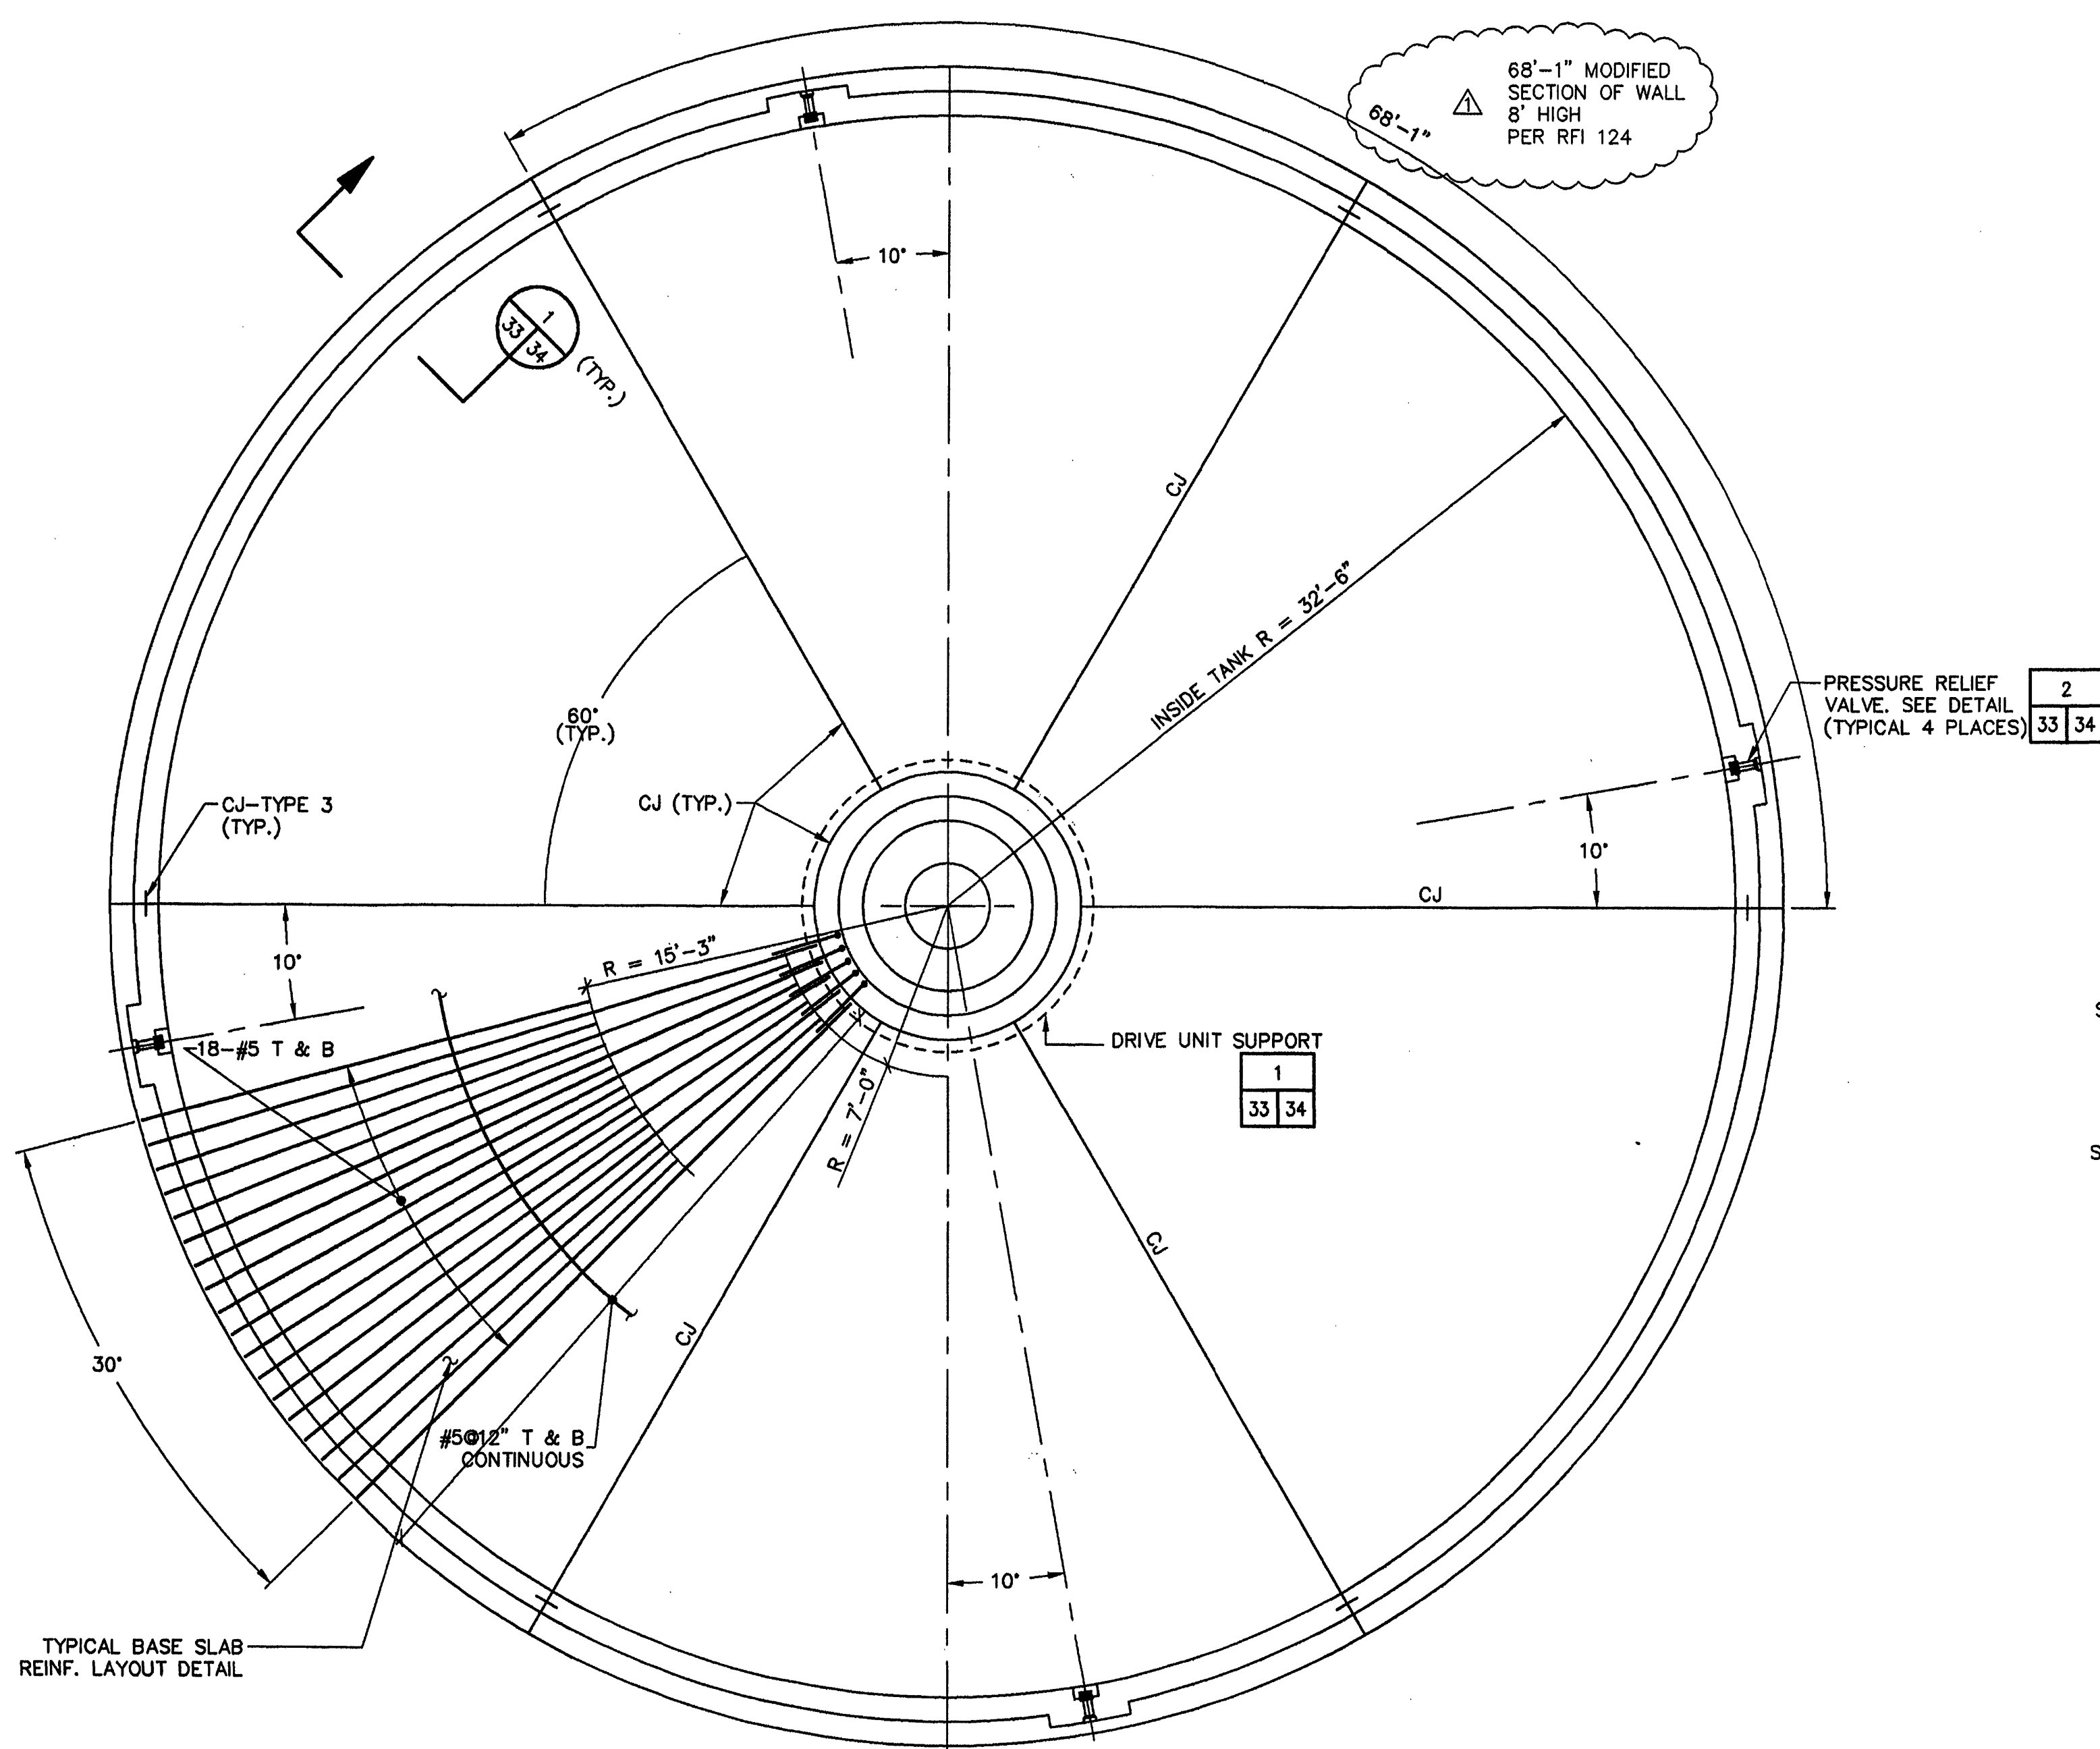

FOUNDATION PLAN  
SCALE: 3/16"=1'-0"

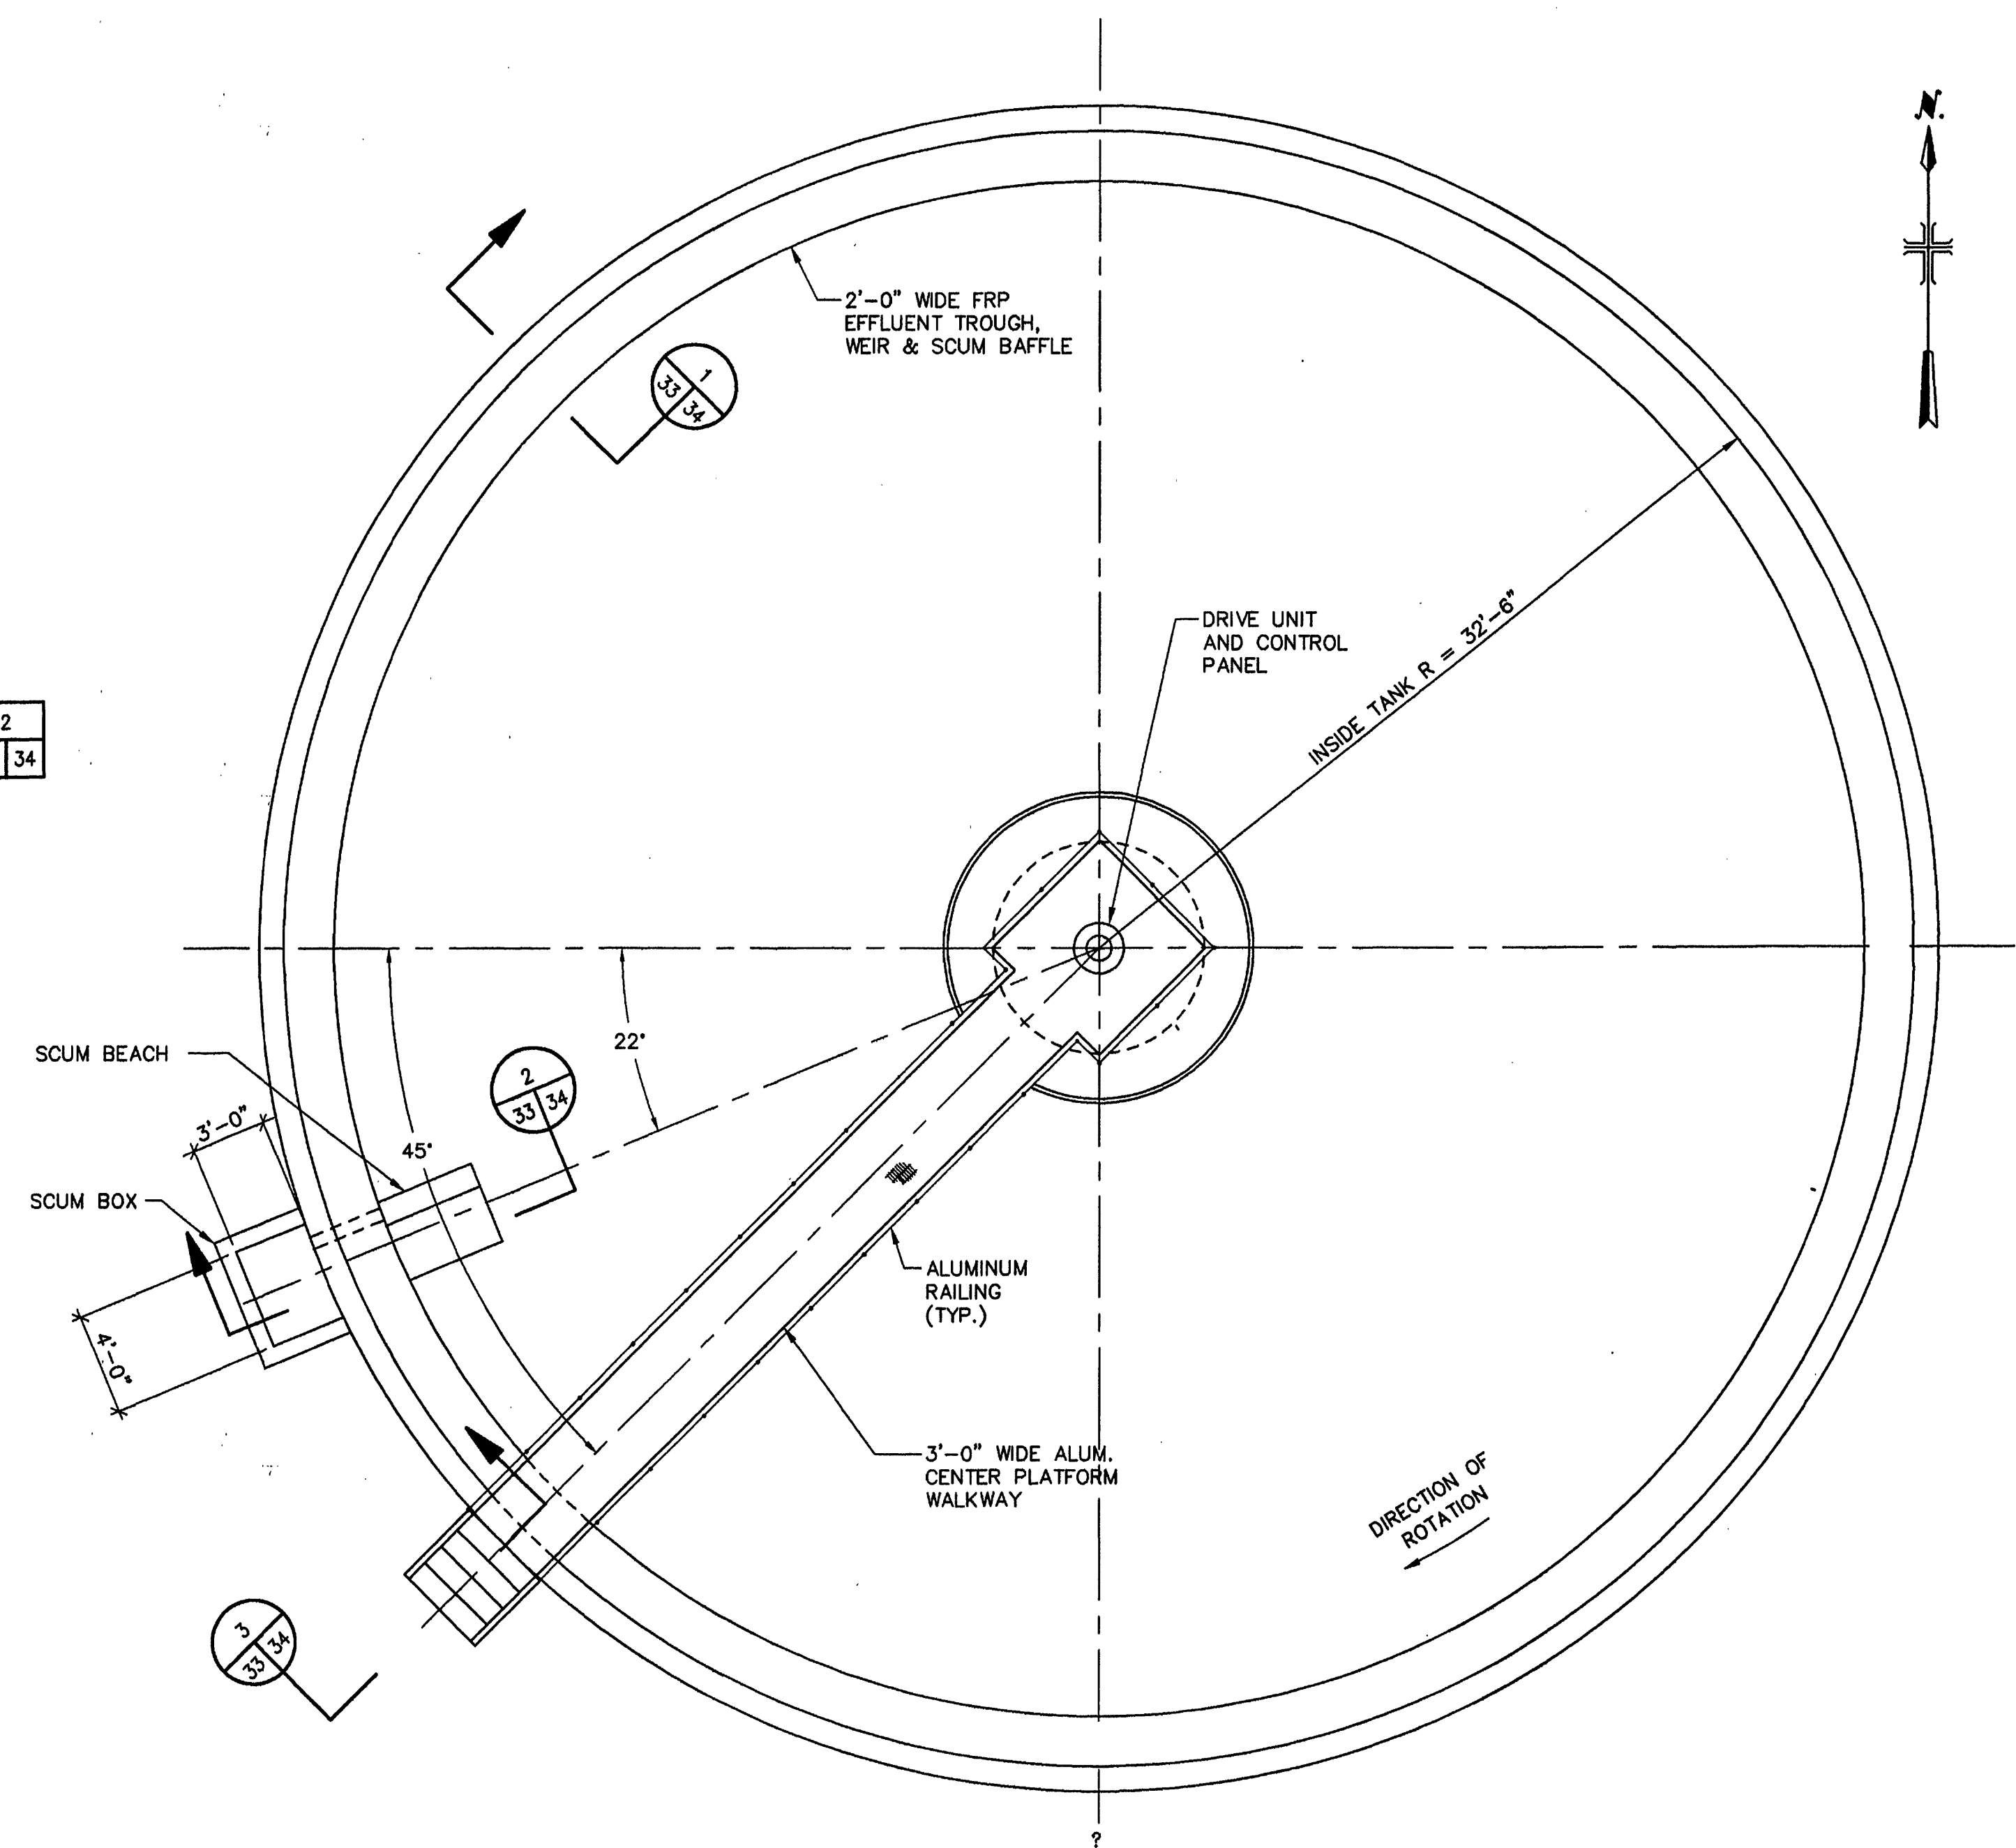

TOP PLAN  
SCALE: 3/16"=1'-0"

**MALCOLM  
PIRNIE**  
11832 Rock Landing Drive, Suite 400  
Newport News, Virginia 23606

| REVISIONS |     |           |                | REMARKS |  |
|-----------|-----|-----------|----------------|---------|--|
| NO.       | BY  | DATE      | REVISIONS      | REMARKS |  |
| 1         | ARB | JAN. 2000 | RECORD DRAWING |         |  |
|           |     |           |                |         |  |
|           |     |           |                |         |  |
|           |     |           |                |         |  |
|           |     |           |                |         |  |

DES -- EDC  
DWN -- EDC  
CKD -- HLC



CITY OF ROANOKE, VIRGINIA  
WATER POLLUTION  
CONTROL PLANT  
UPGRADE AND EXPANSION

GRAVITY THICKENER  
PLANS AND SECTIONS  
AS NOTED

COPYRIGHT © 1997  
MALCOLM PIRNIE, INC.  
DATE MAY 1997  
S SHEET 33 OF 44  
CAD REF. NO. 0060S370