




NORTH ELEVATION
SCALE: 3/16"=1'-0"

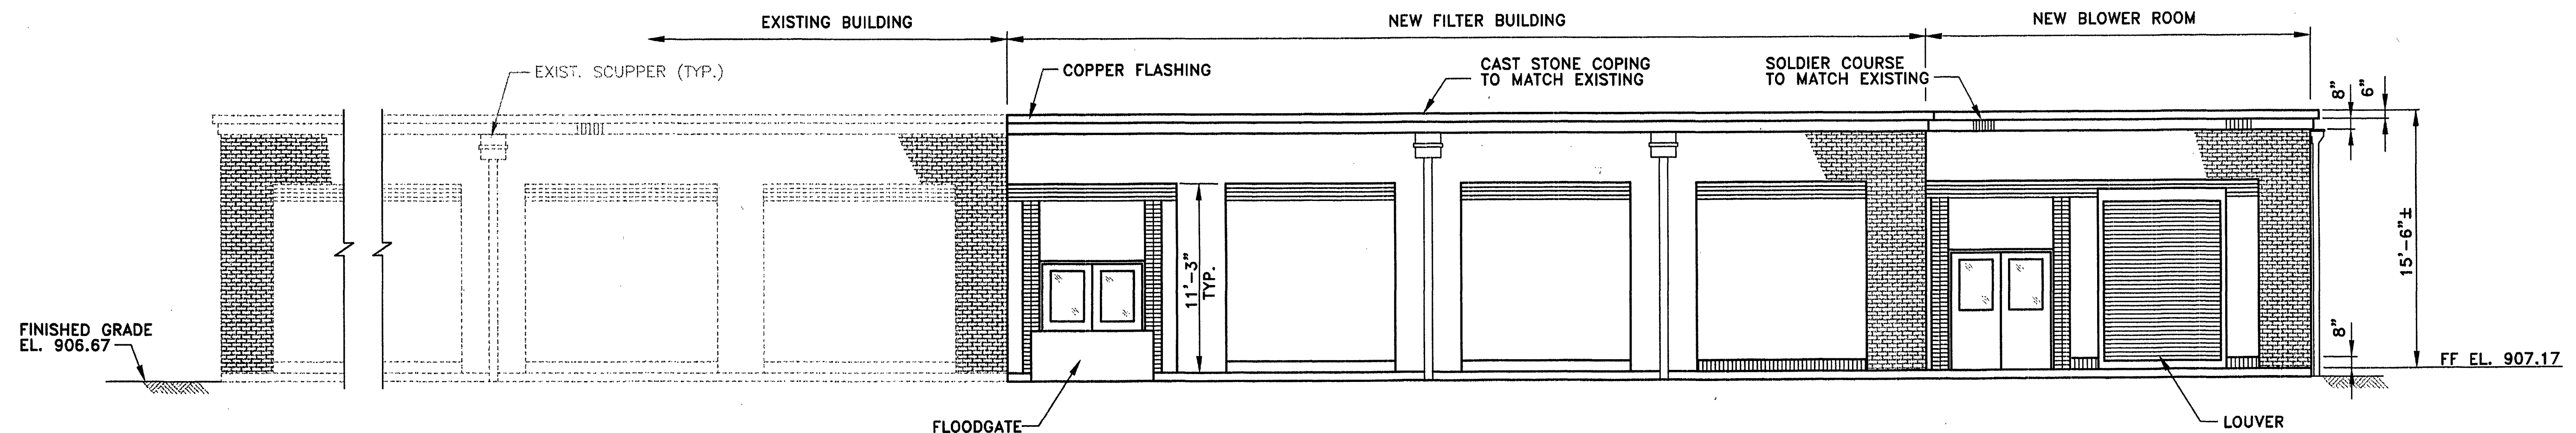


SOUTH ELEVATION
SCALE: 3/16"=1'-0"

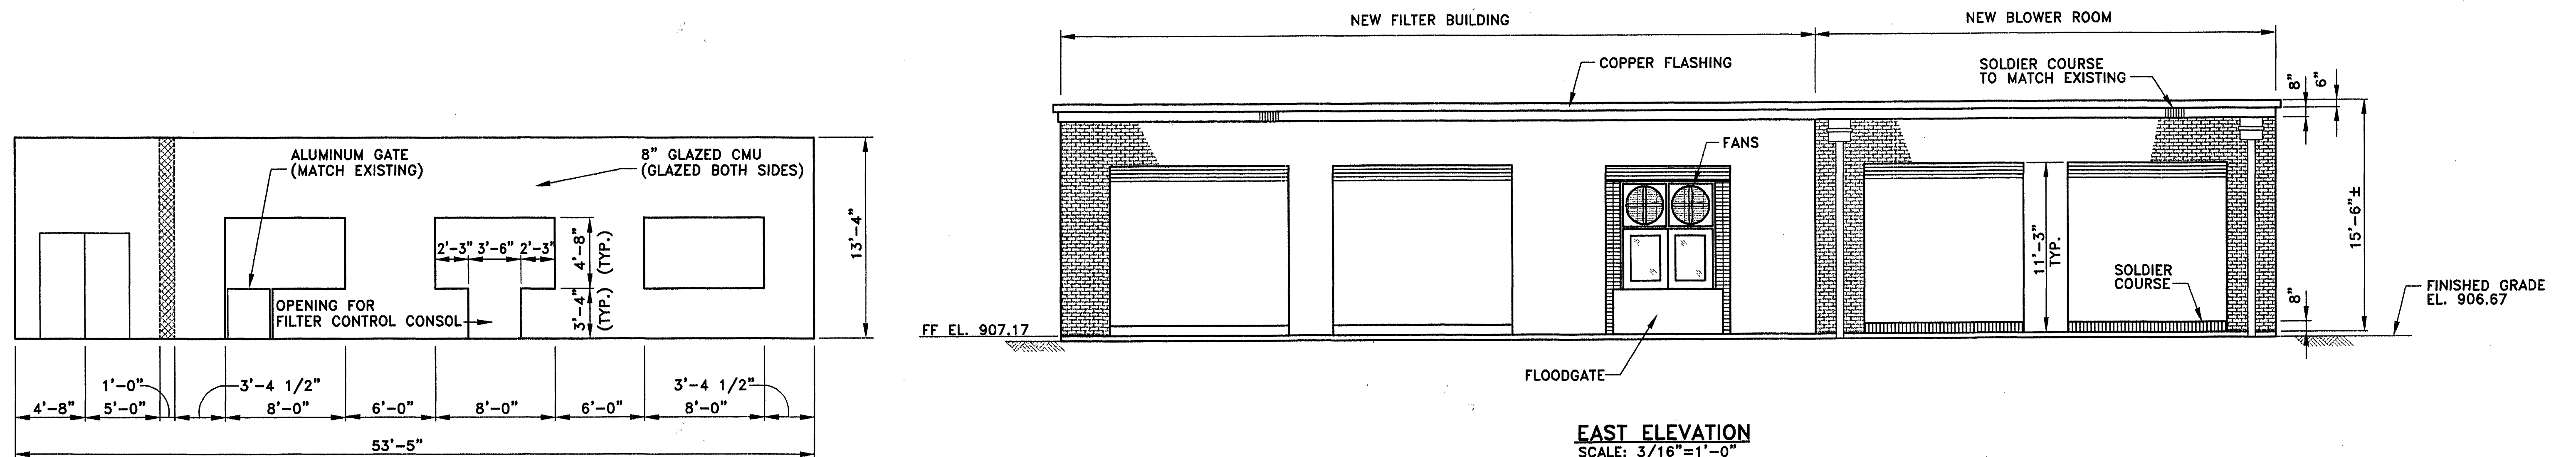

EAST ELEVATION
SCALE: 3/16"=1'-0"

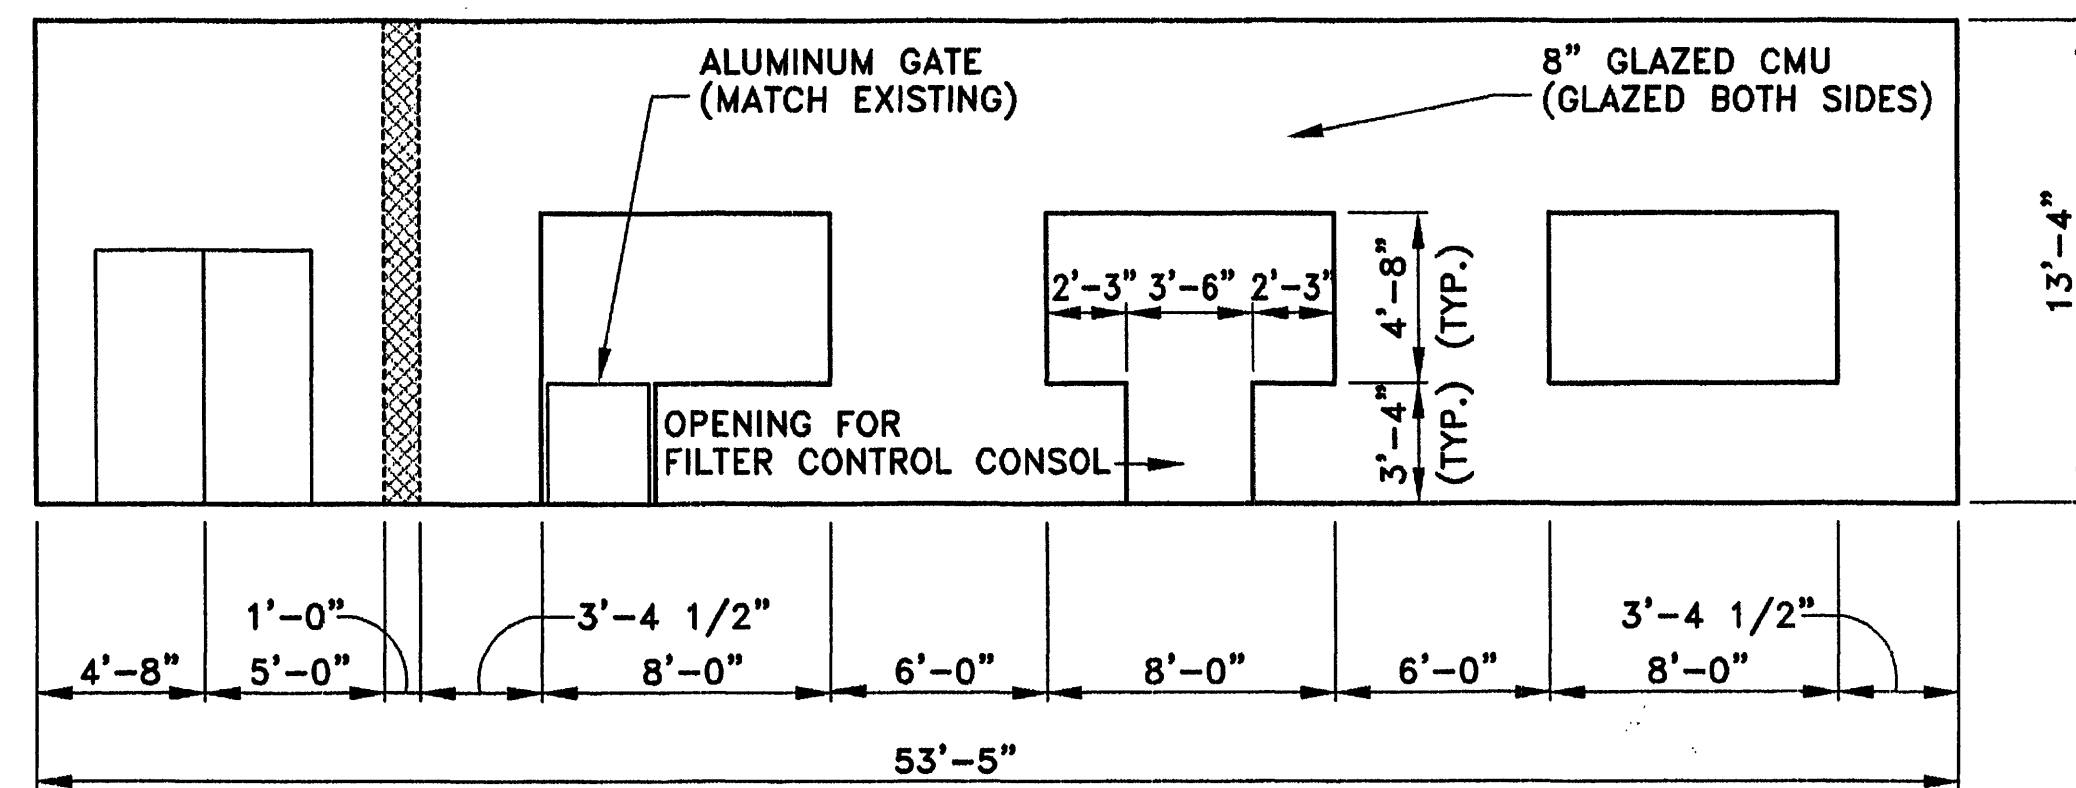

(LOOKING NORTH)
INTERIOR WALL ELEVATION ALONG MAIN CORRIDOR
SCALE: 3/16"=1'-0"

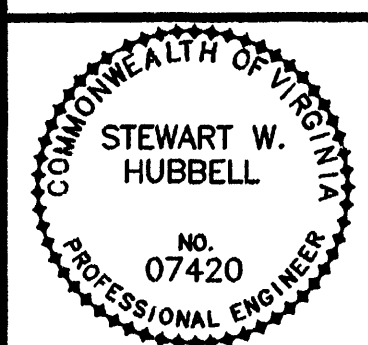

Mattern & Craig, Inc.
CONSULTING ENGINEERS - SURVEYORS
101 FIRST FLOOR, S.W.
ROANOKE, VIRGINIA 24004
(804) 548-4444
(804) 548-7001 FAX

REVISIONS				
NO.	BY	DATE	REVISIONS	REMARKS
1	ARB	JAN. 2000	RECORD DRAWING	

DES: BCC
OWN: ARB, LDL
CKD: SWH



CITY OF ROANOKE, VIRGINIA
**WATER POLLUTION
CONTROL PLANT
UPGRADE AND EXPANSION**

EFFLUENT FILTERS

ELEVATIONS
SCALE: AS SHOWN

DATE: MAY, 1997
A SHEET 2 OF 5
CAD REF. NO. A2.DWG