




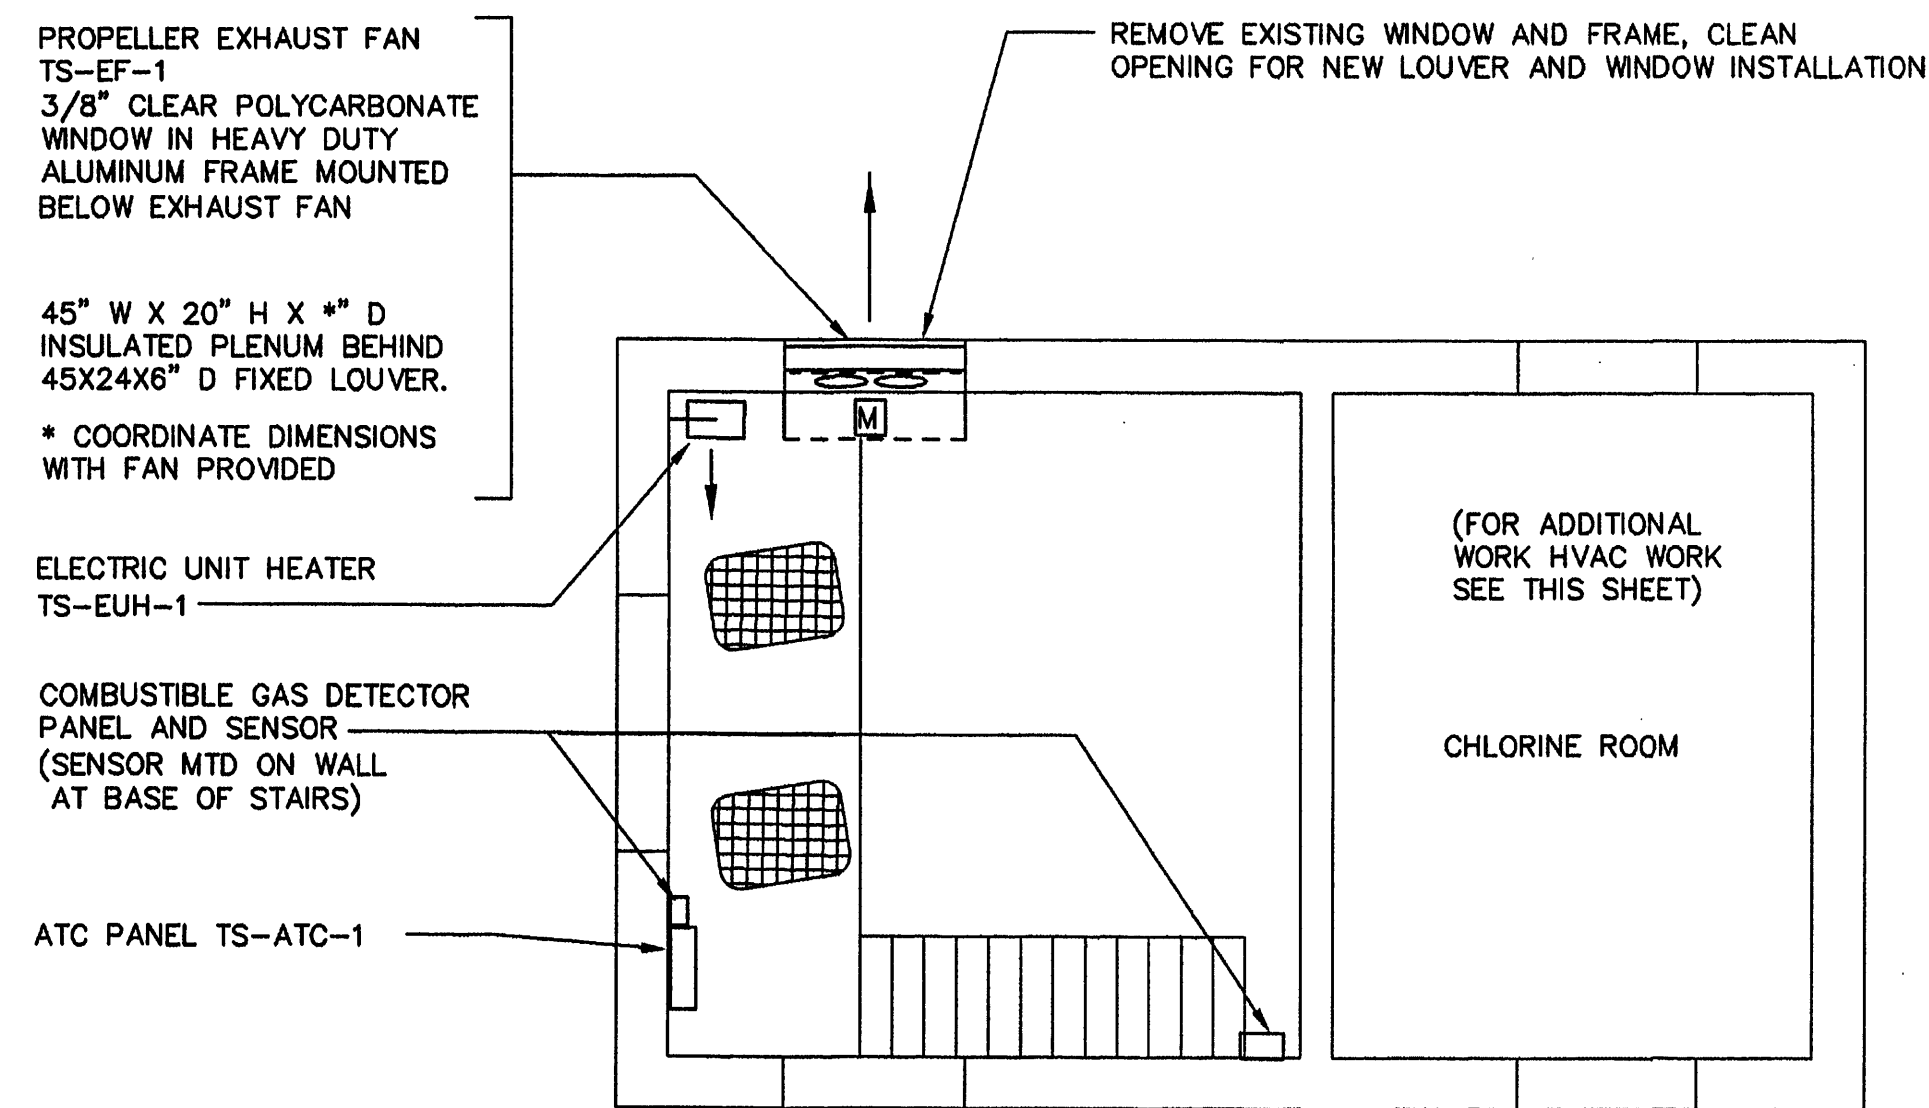


PLAN AT EL. 980.5
SCALE: 1/4" = 1'-0"

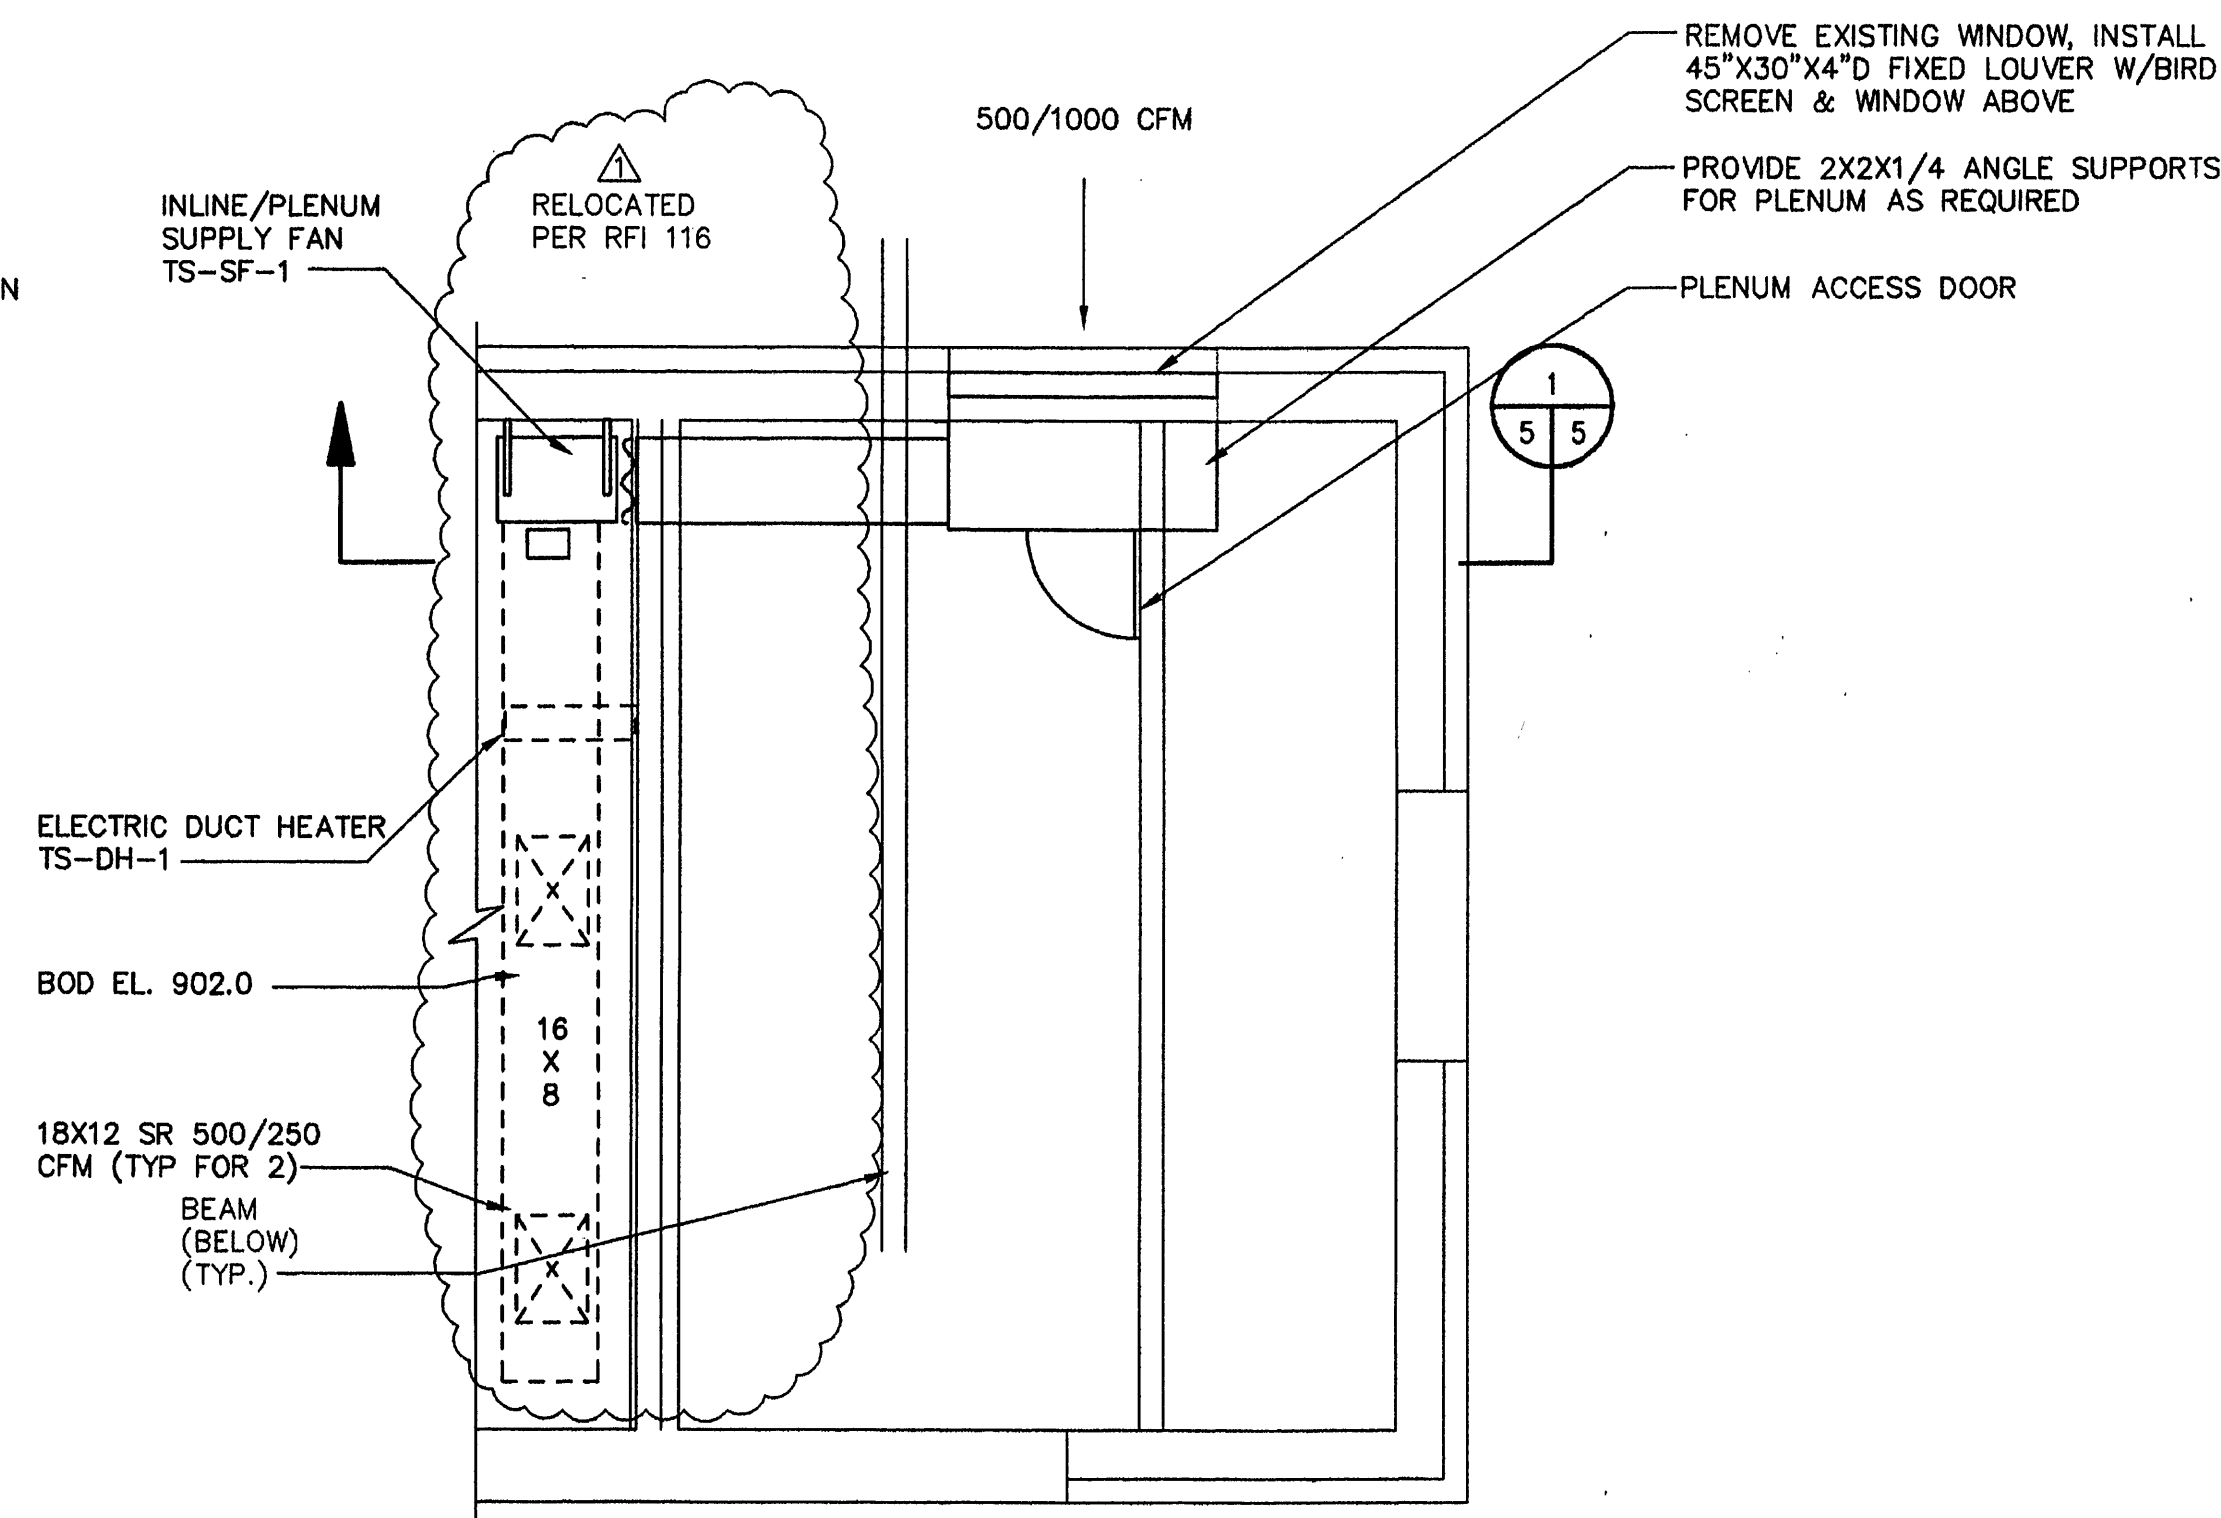


PARTIAL PLAN @ EL. 903.50
SCALE: 3/8" = 1'-0"

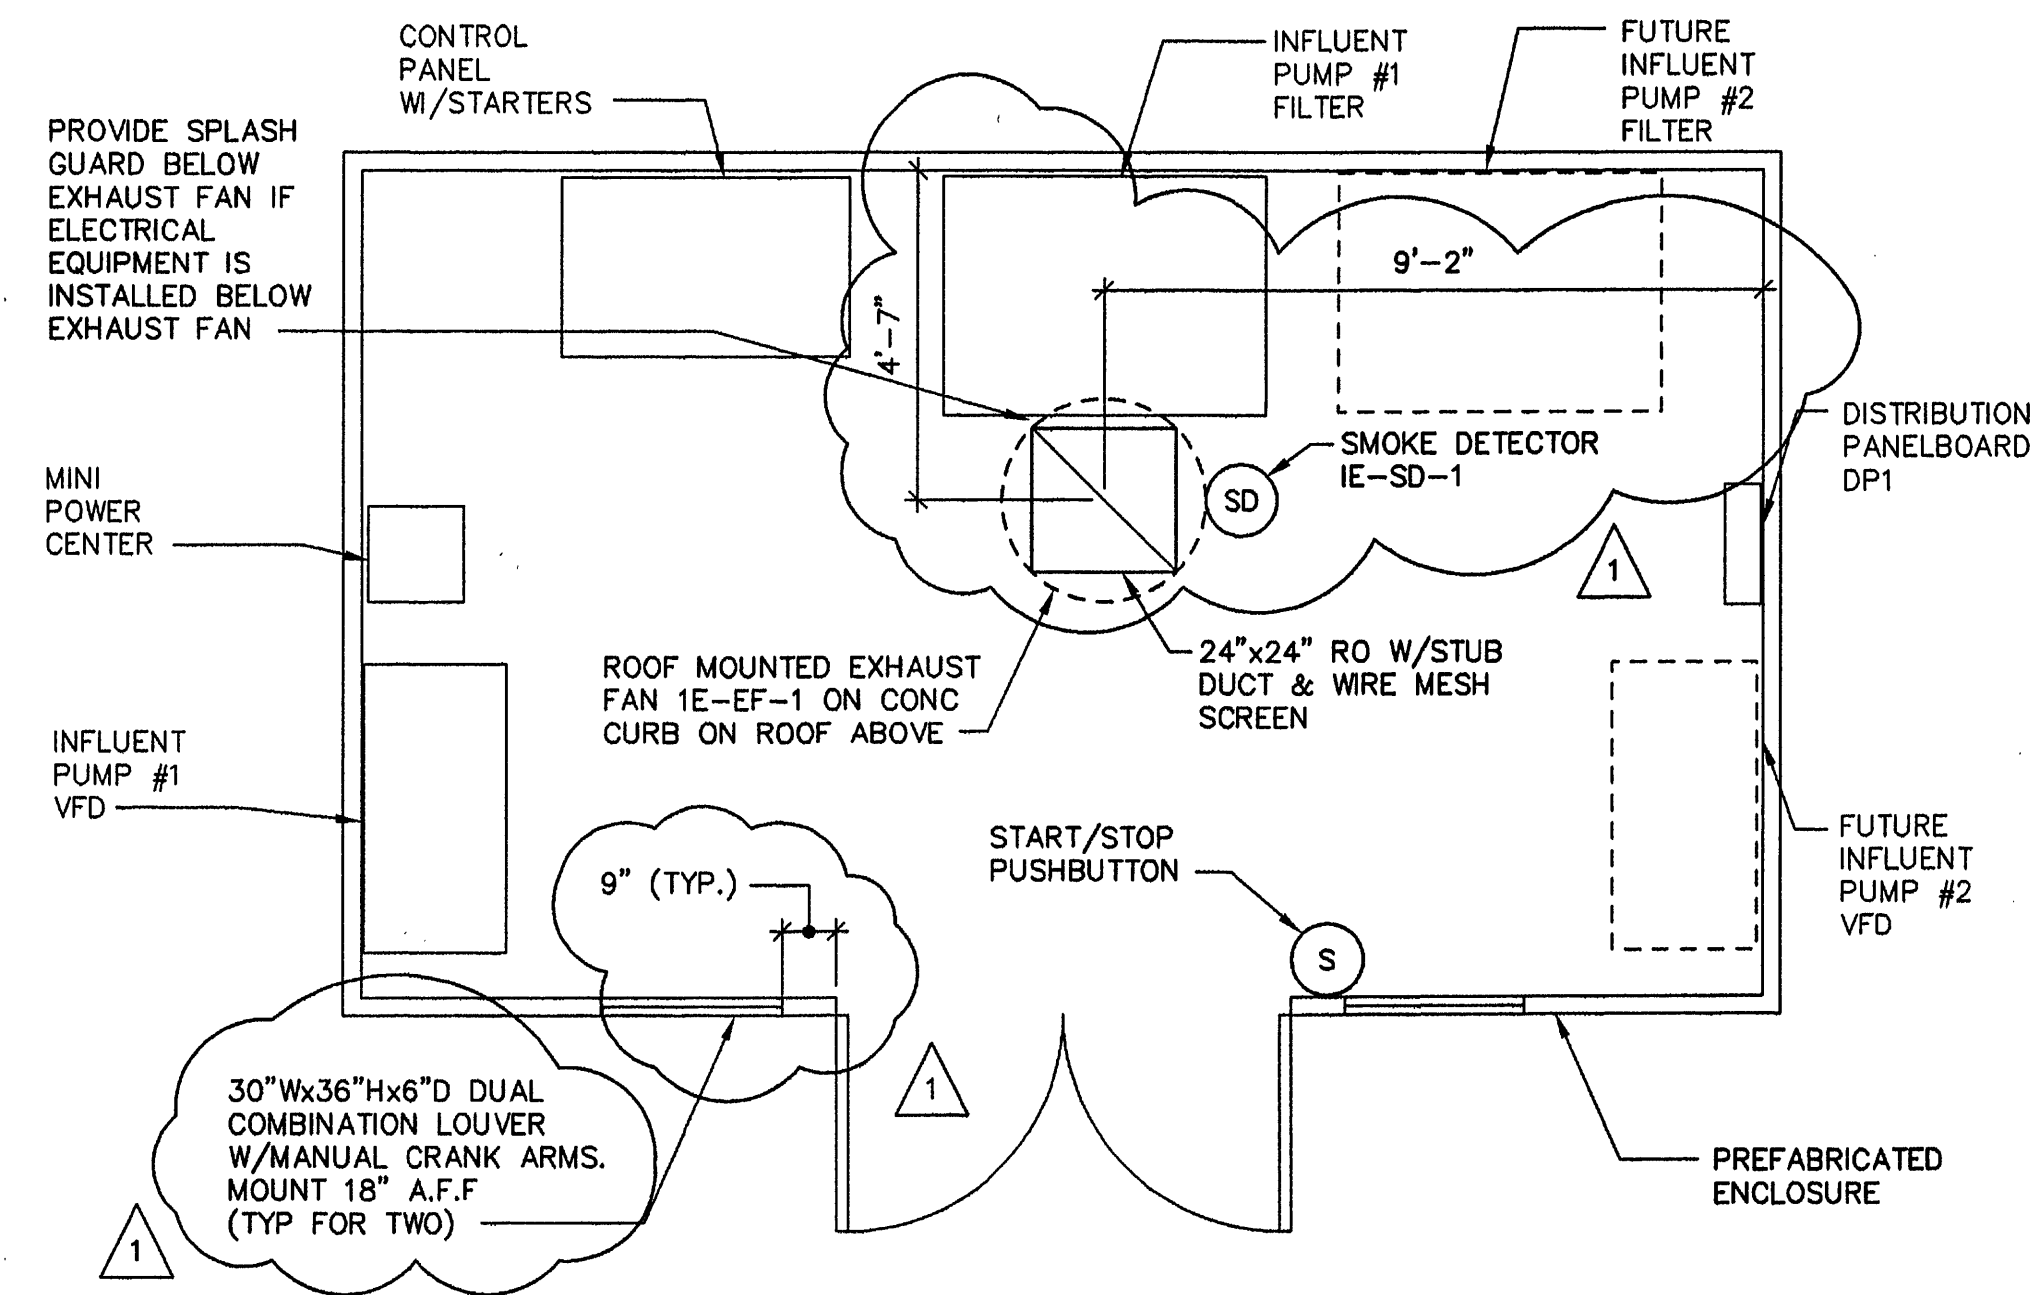


PLAN

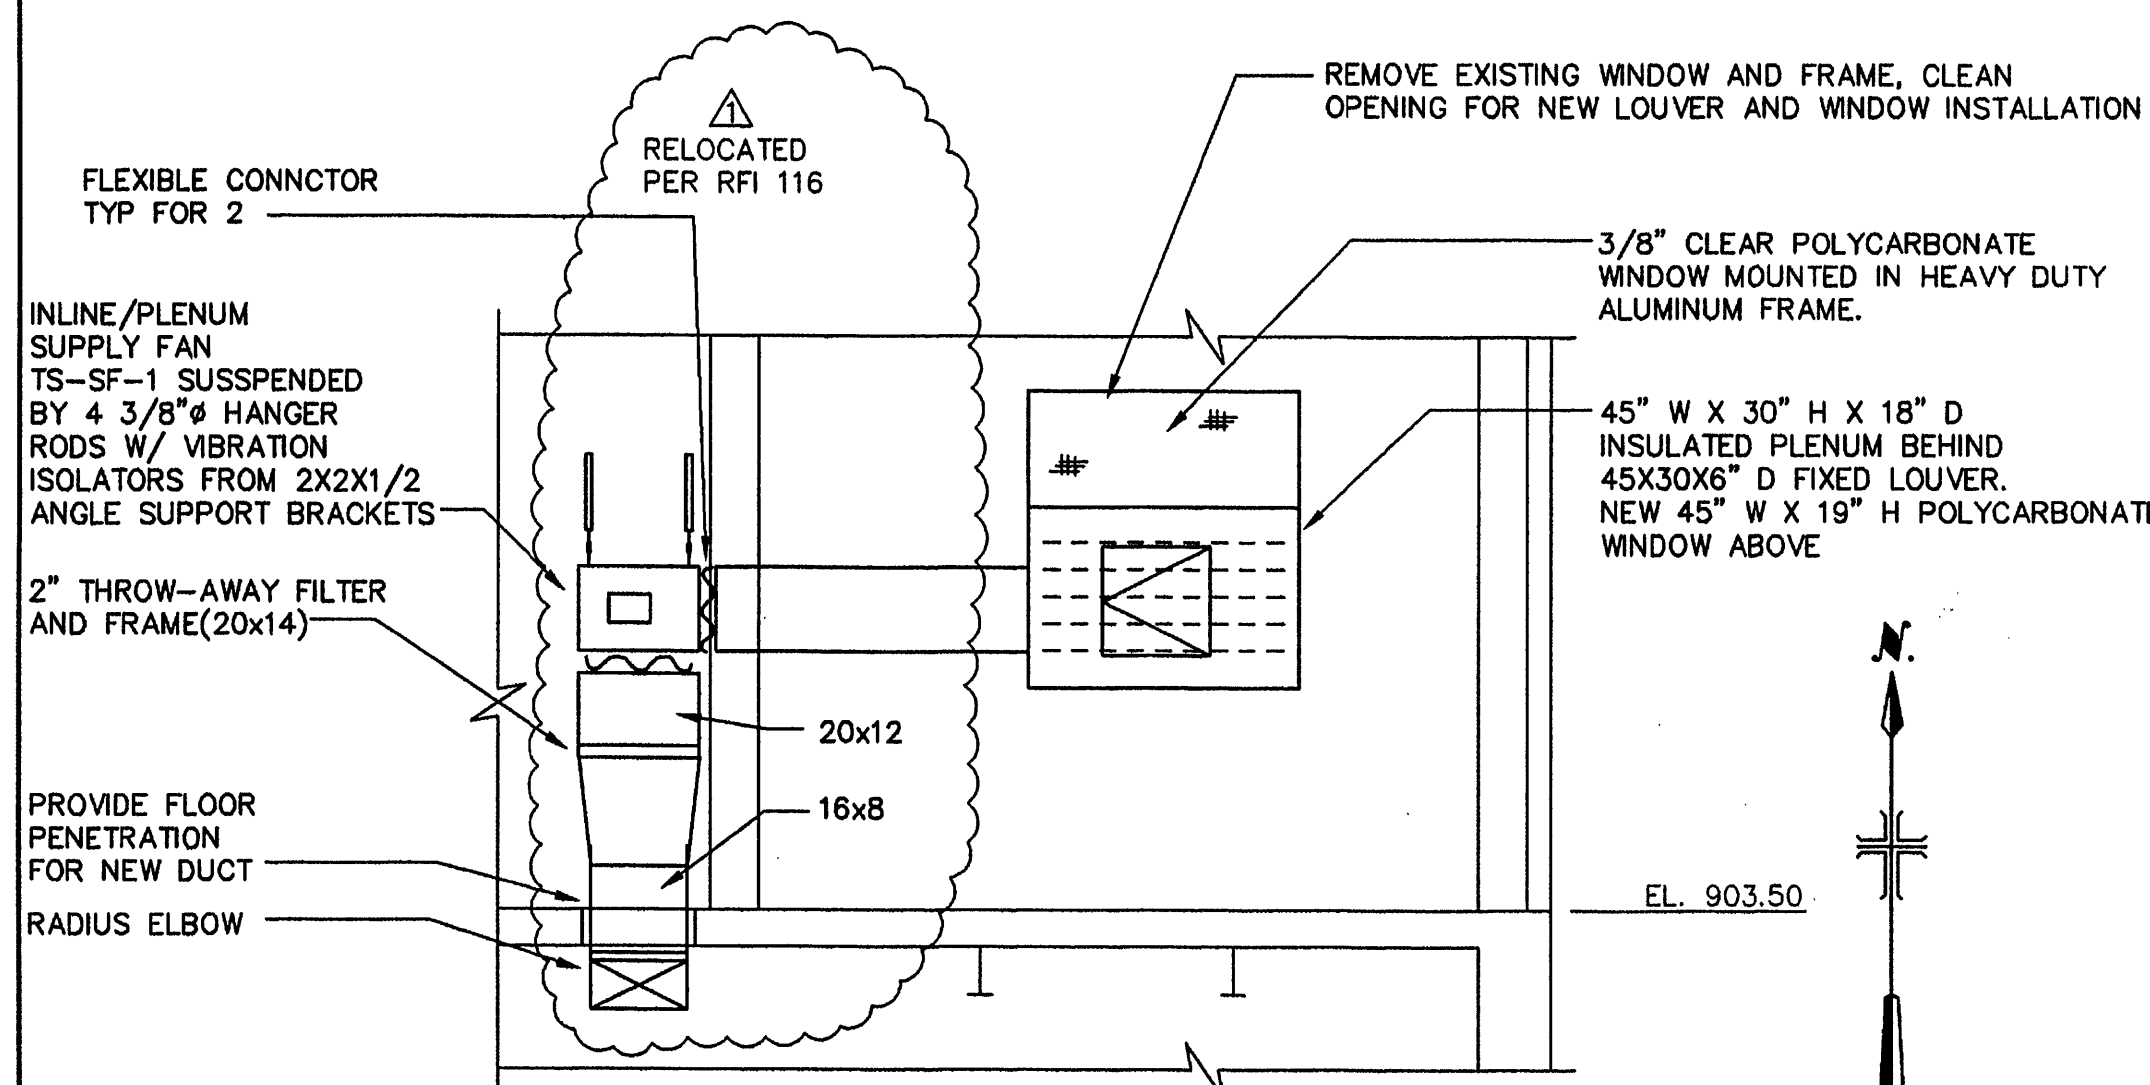

SECTION 3/25/25
SCALE: 3/8" = 1'-0"

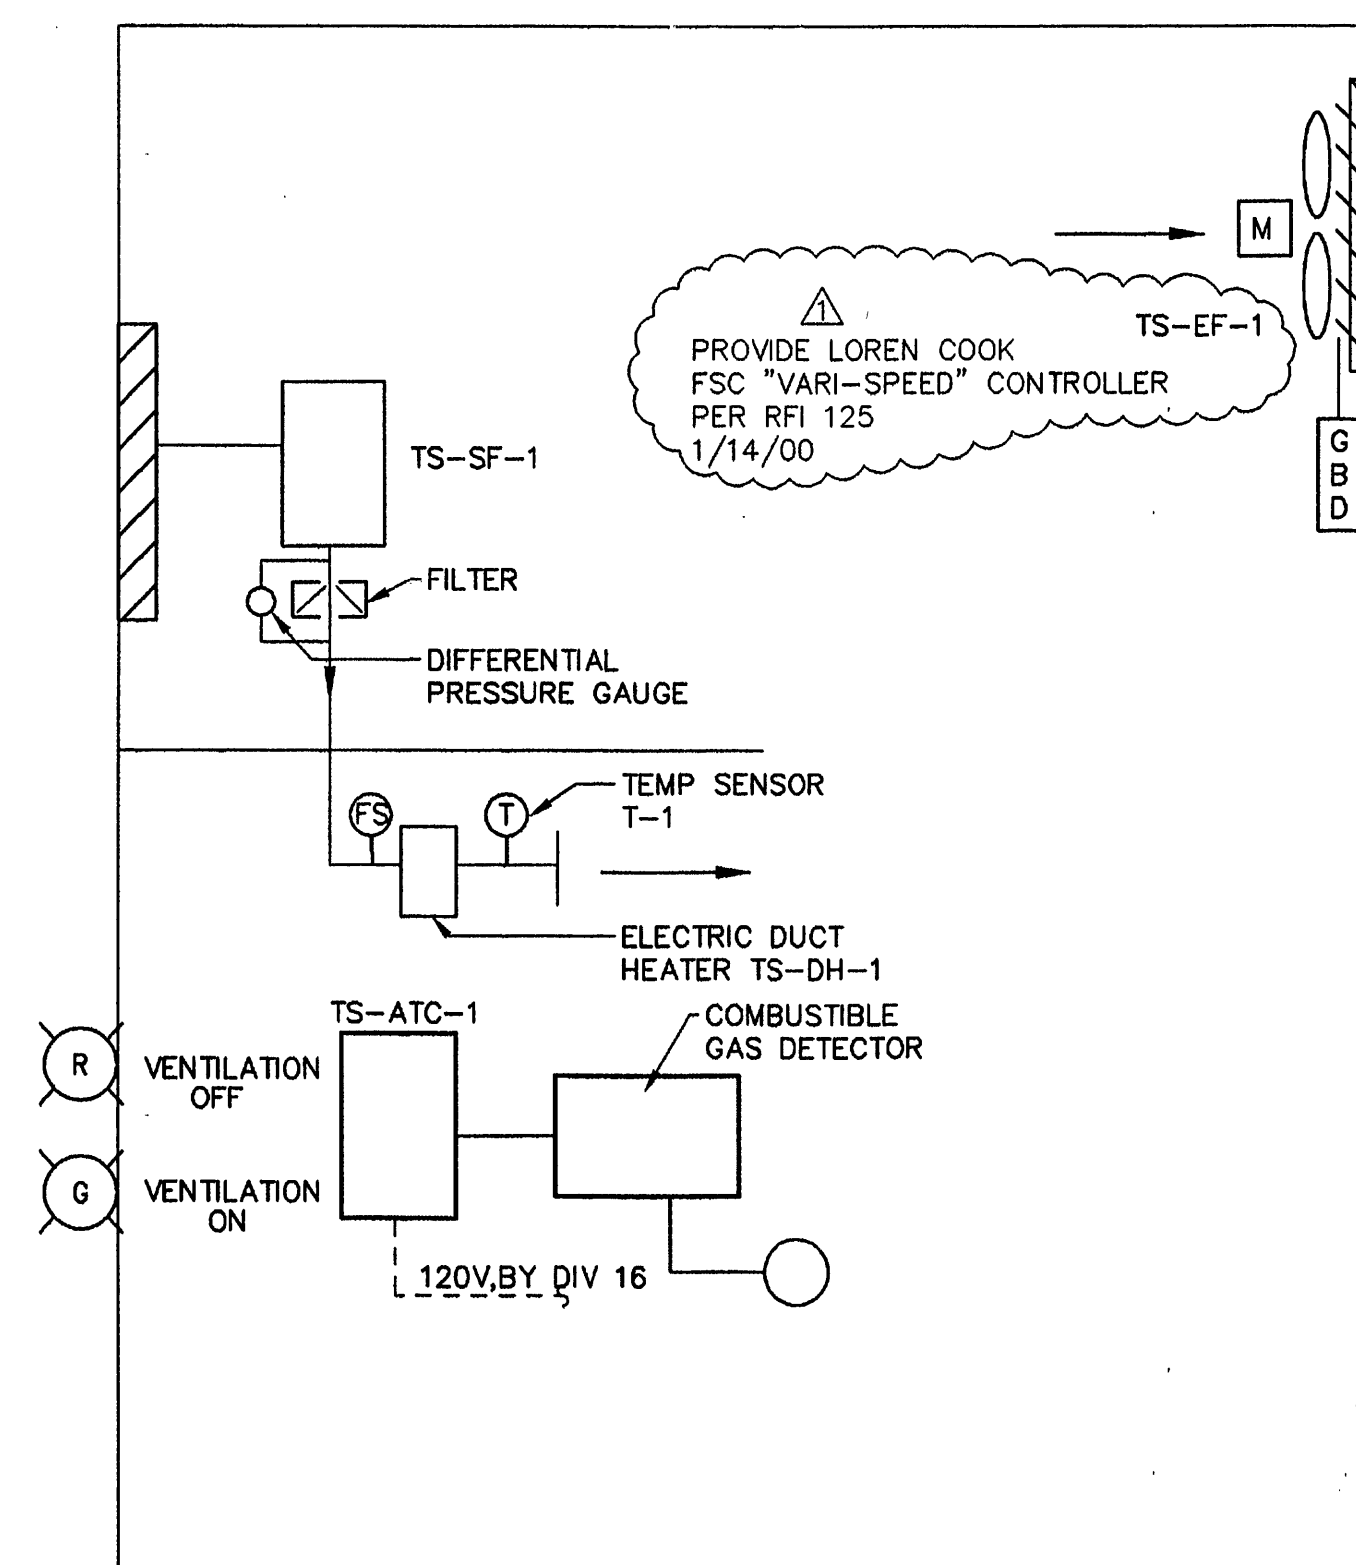

HVAC CONTROL SCHEMATIC

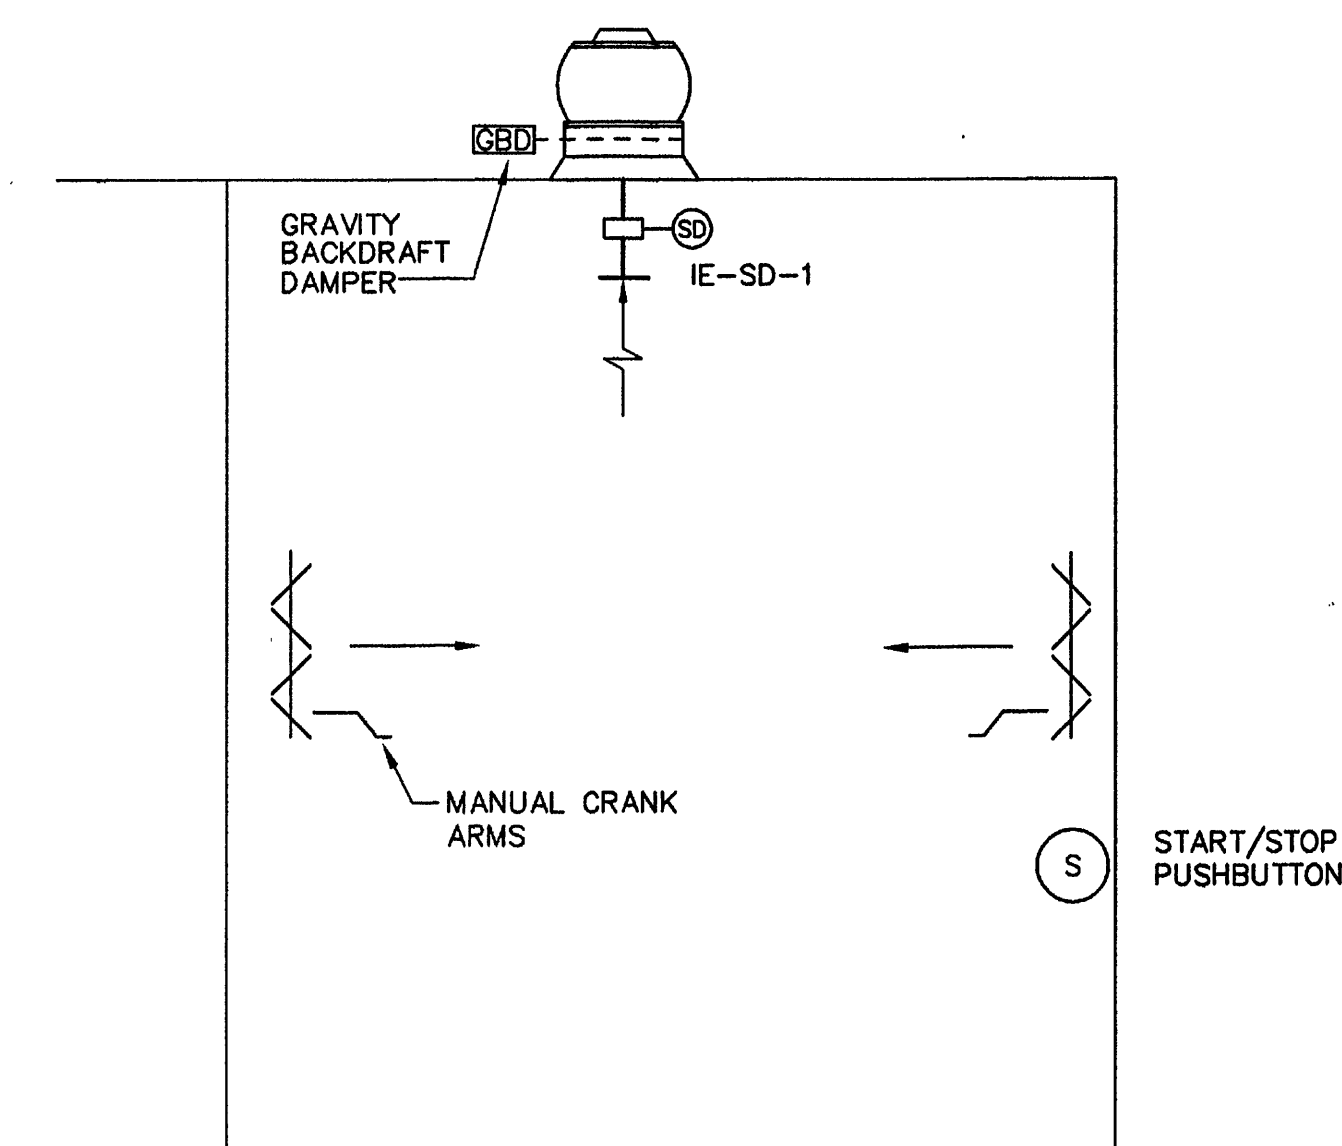

HVAC CONTROL SCHEMATIC

THICKENED SLUDGE PUMP STATION

PLANT INFLUENT PUMP STATION

4595 ADMIN E:\ACAD\PROJ\00600283\0060H505 Scale: 1:321 Date: 05/01/1997 Time: 11:02

**MALCOLM
PIRNIE**
11832 Rock Landing Drive, Suite 400
Newport News, Virginia 23606

REVISIONS				REMARKS
NO.	BY	DATE		
1	ARB	JAN. 2000	RECORD DRAWING	

DES -- JMC --
DWN -- CPS --
OKD -- JMC --



CITY OF ROANOKE, VIRGINIA
WATER POLLUTION
CONTROL PLANT
UPGRADE AND EXPANSION

PLANT INFLUENT & THICKENED SLUDGE PUMP STATIONS
PLANS AND CONTROL SCHEMATIC

SCALE: 3/8" = 1'-0"

COPYRIGHT © 1997
MALCOLM PIRNIE, INC.
DATE -- MAY 1997 --
H SHEET 5 OF 6 --
CAD REF. NO. 0060H505