




- NOTES:
1. AREA CLASSIFICATION:
- a. THE ENTIRE LOWER LEVEL IS CONSIDERED A WET LOCATION. ALL MATERIALS, EQUIPMENT AND INCIDENTALS SHALL MEET NEMA 4X REQUIREMENTS. ALL EXPOSED CONDUITS SHALL BE PVC COATED RIGID STEEL.

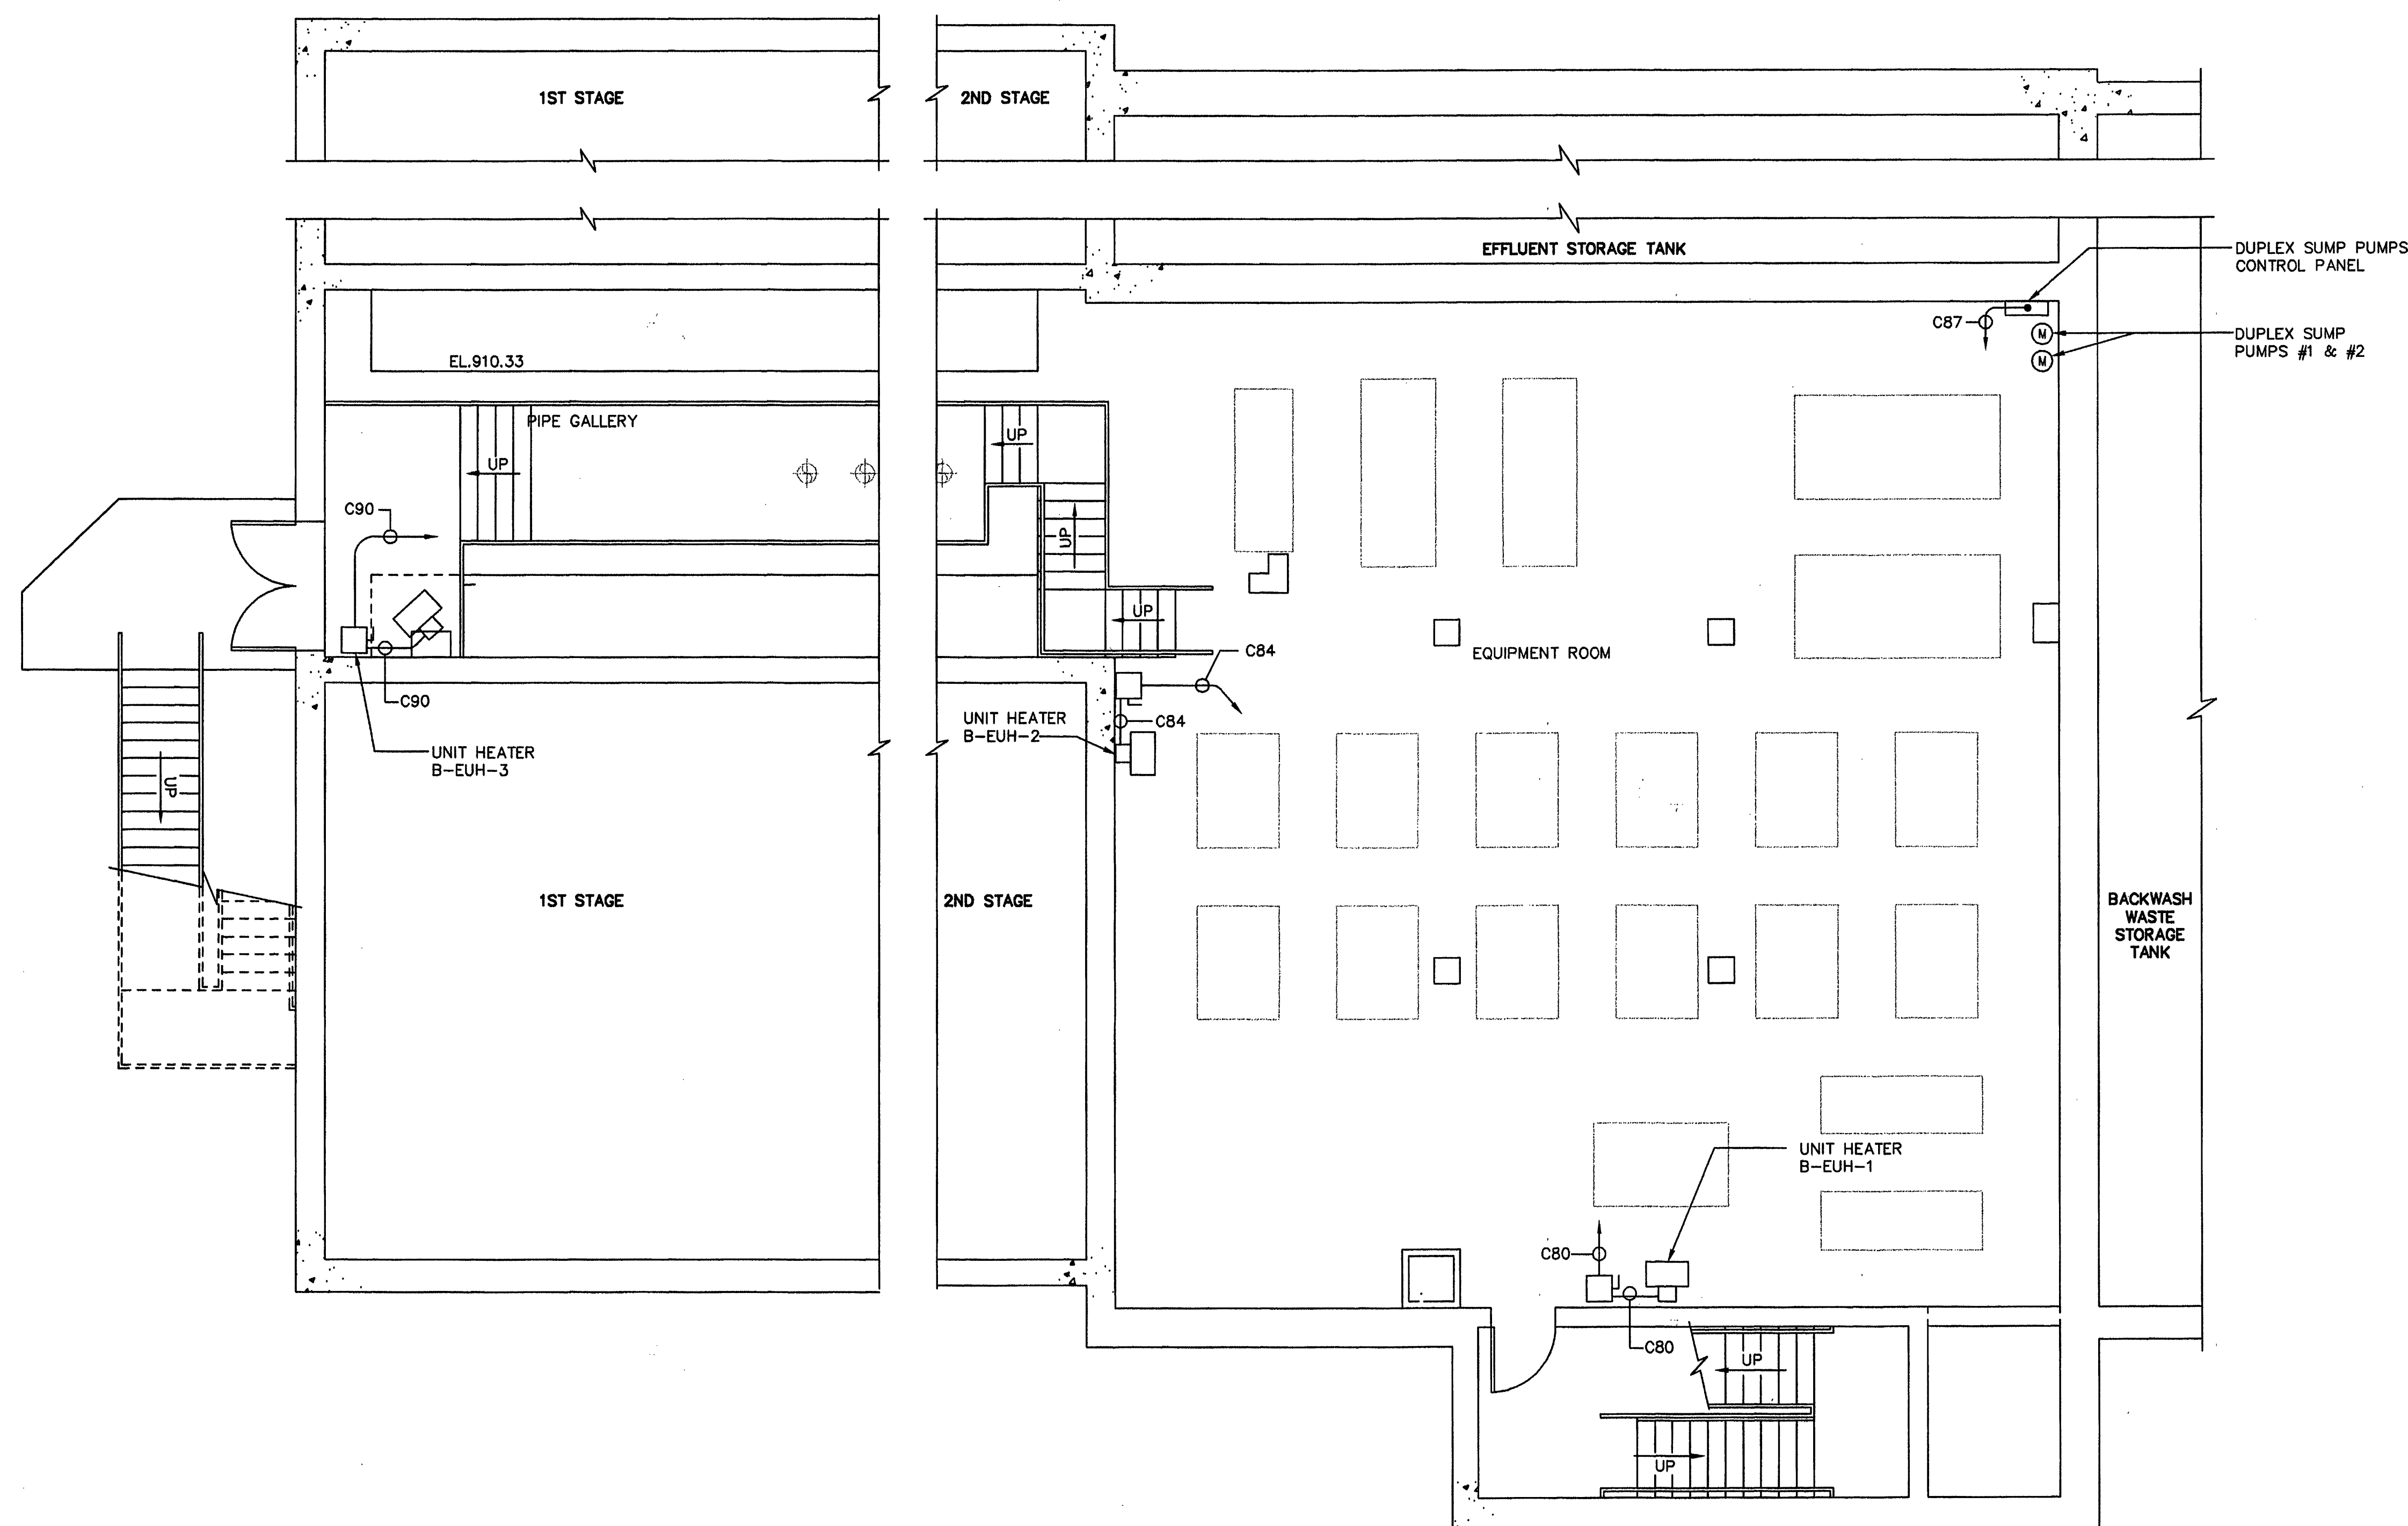

PLAN

**MALCOLM
PIRNIE**

11832 Rock Landing Drive, Suite 400
Newport News, Virginia 23606

REVISIONS				REMARKS
NO.	BY	DATE	DESCRIPTION	
1	ARB	JAN. 2000	RECORD DRAWING	

DES --- GJM
DWN --- GJM
CKD --- TK



CITY OF ROANOKE, VIRGINIA
**WATER POLLUTION
CONTROL PLANT
UPGRADE AND EXPANSION**

**BIOLOGICAL AERATED FILTER
LOWER LEVEL POWER PLAN**

SCALE: 3/16"=1'-0"

COPYRIGHT © 1997
MALCOLM PIRNIE, INC.
DATE --- MAY 1997 ---
E SHEET 15 OF 36
CAD REF. NO. 0060E690