




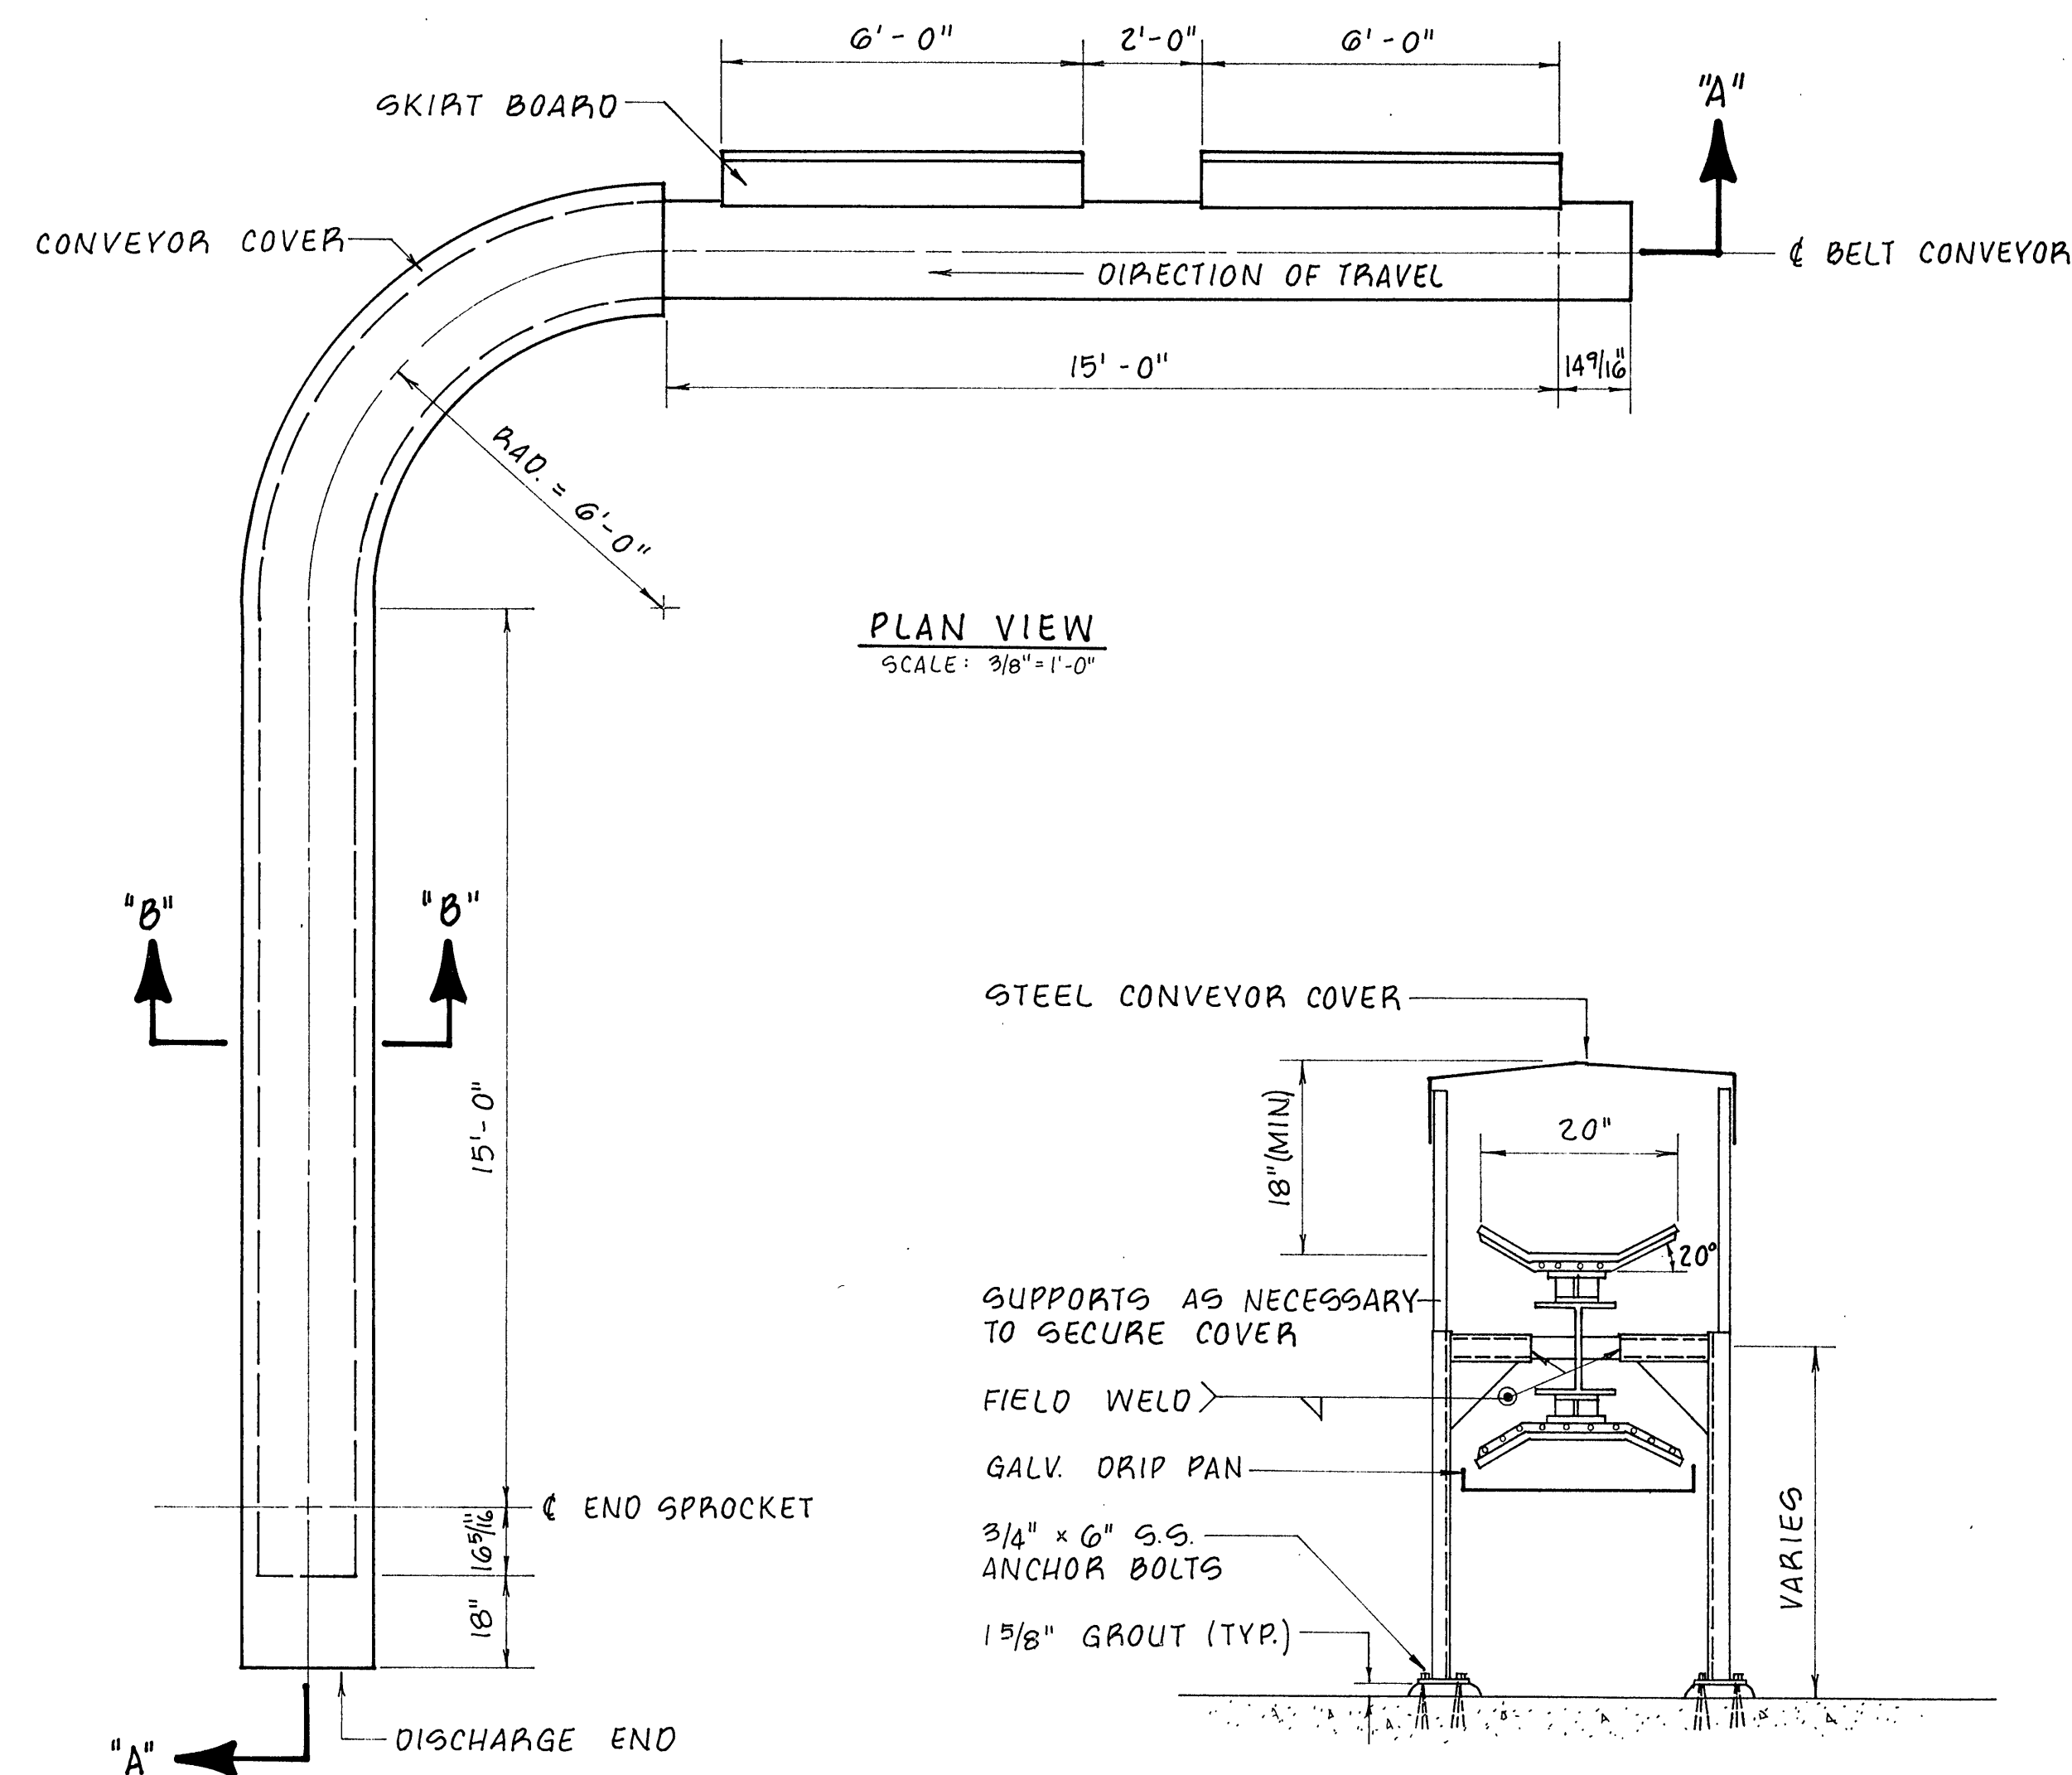


SERPENTINE BELT CONVEYOR

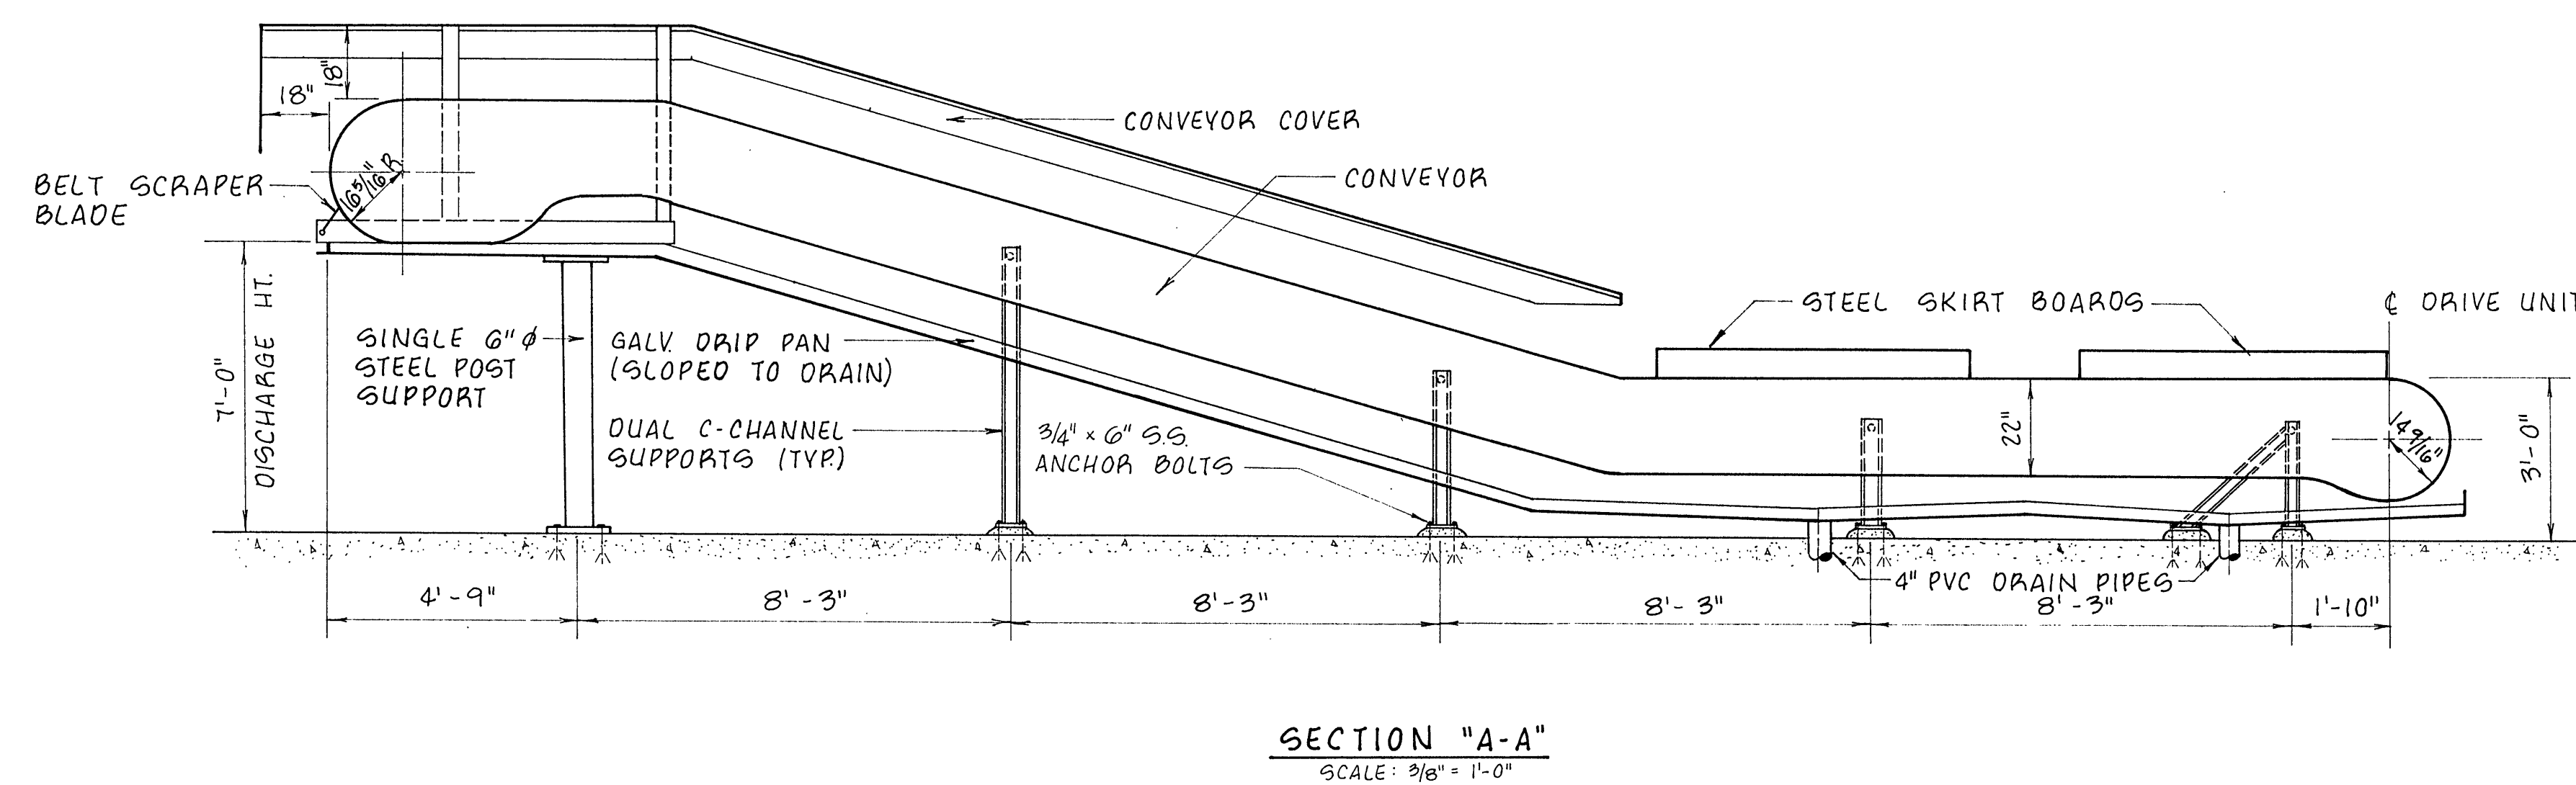

SECTION "A-A"
SCALE: 3/16" = 1'-0"

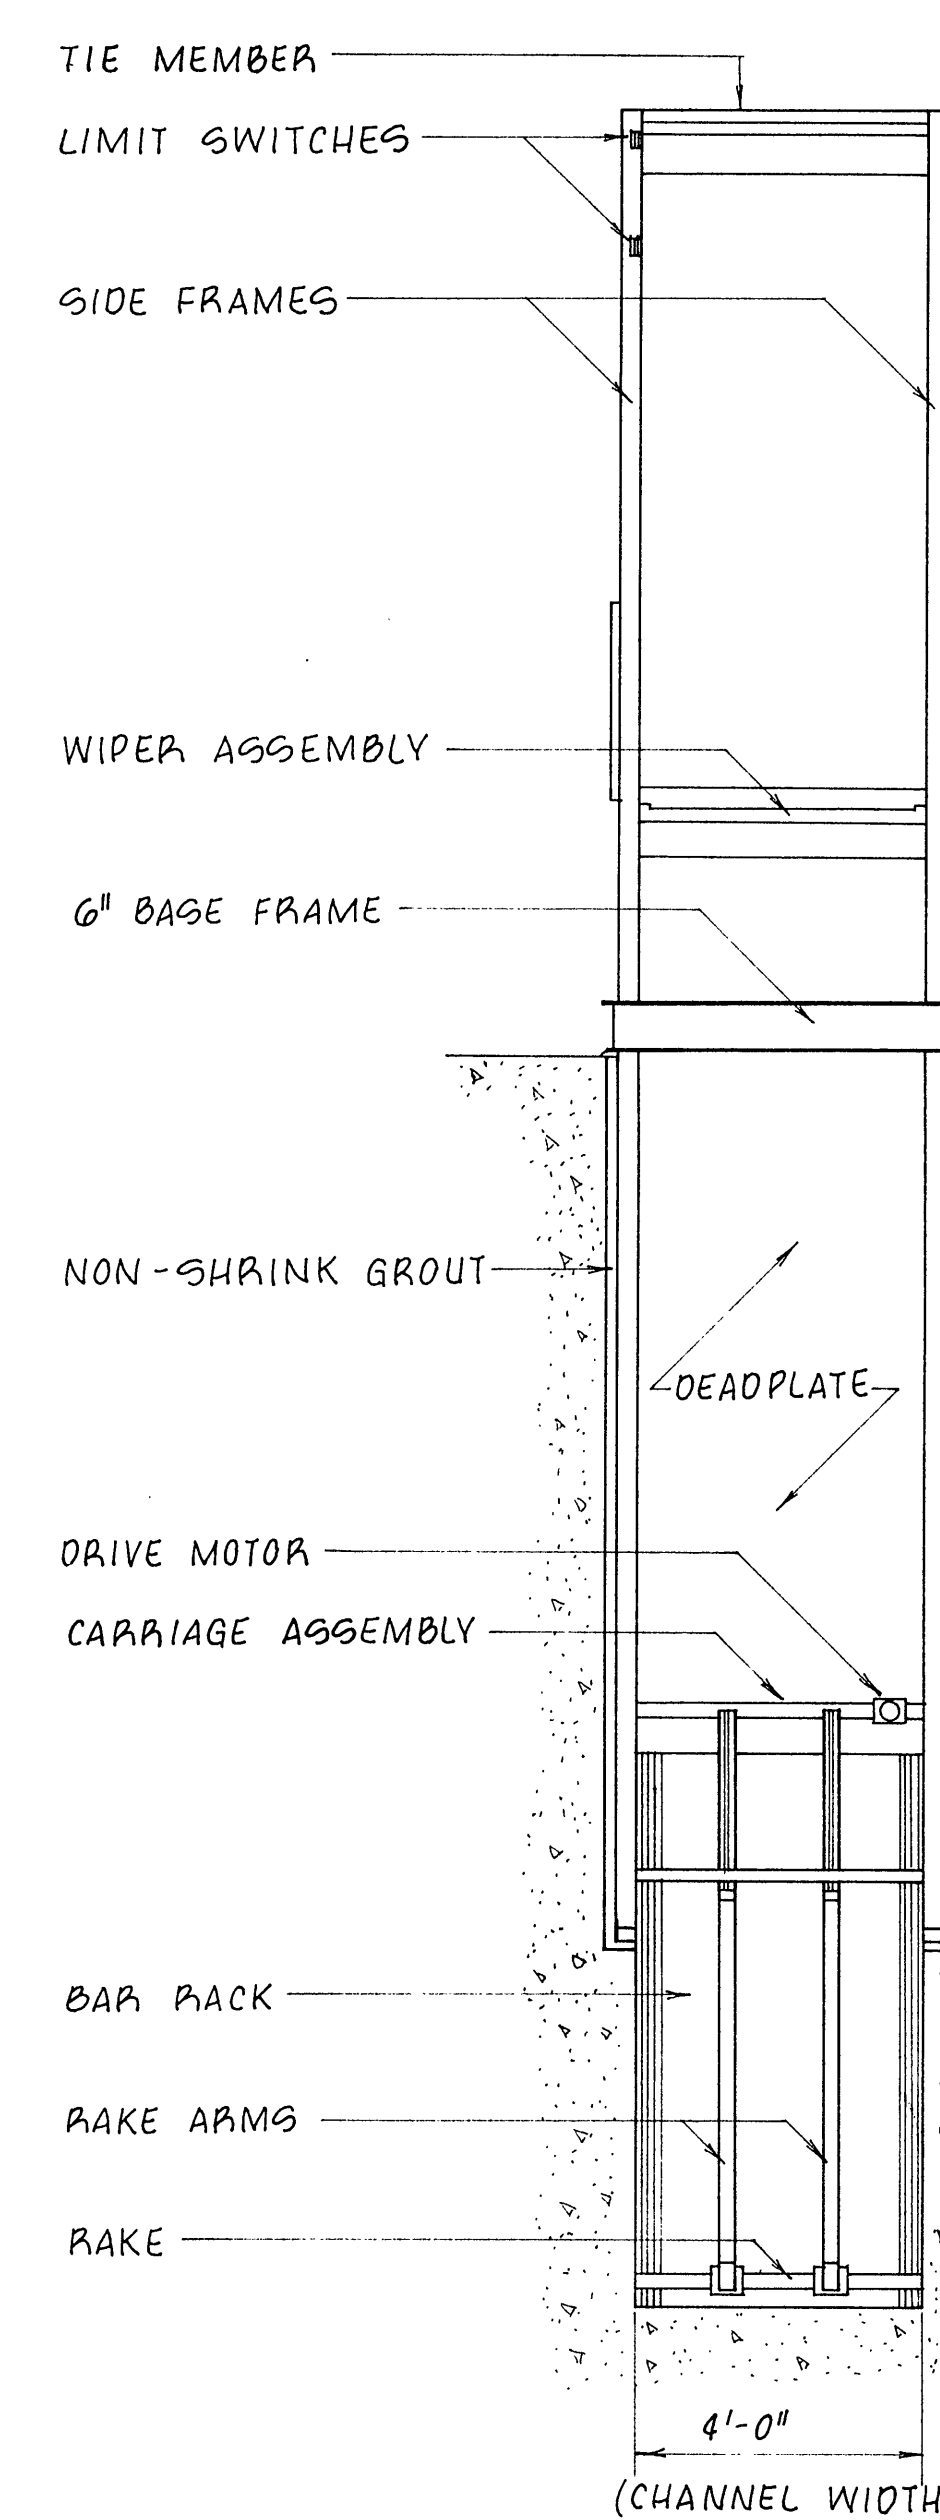


FRONT ELEVATION

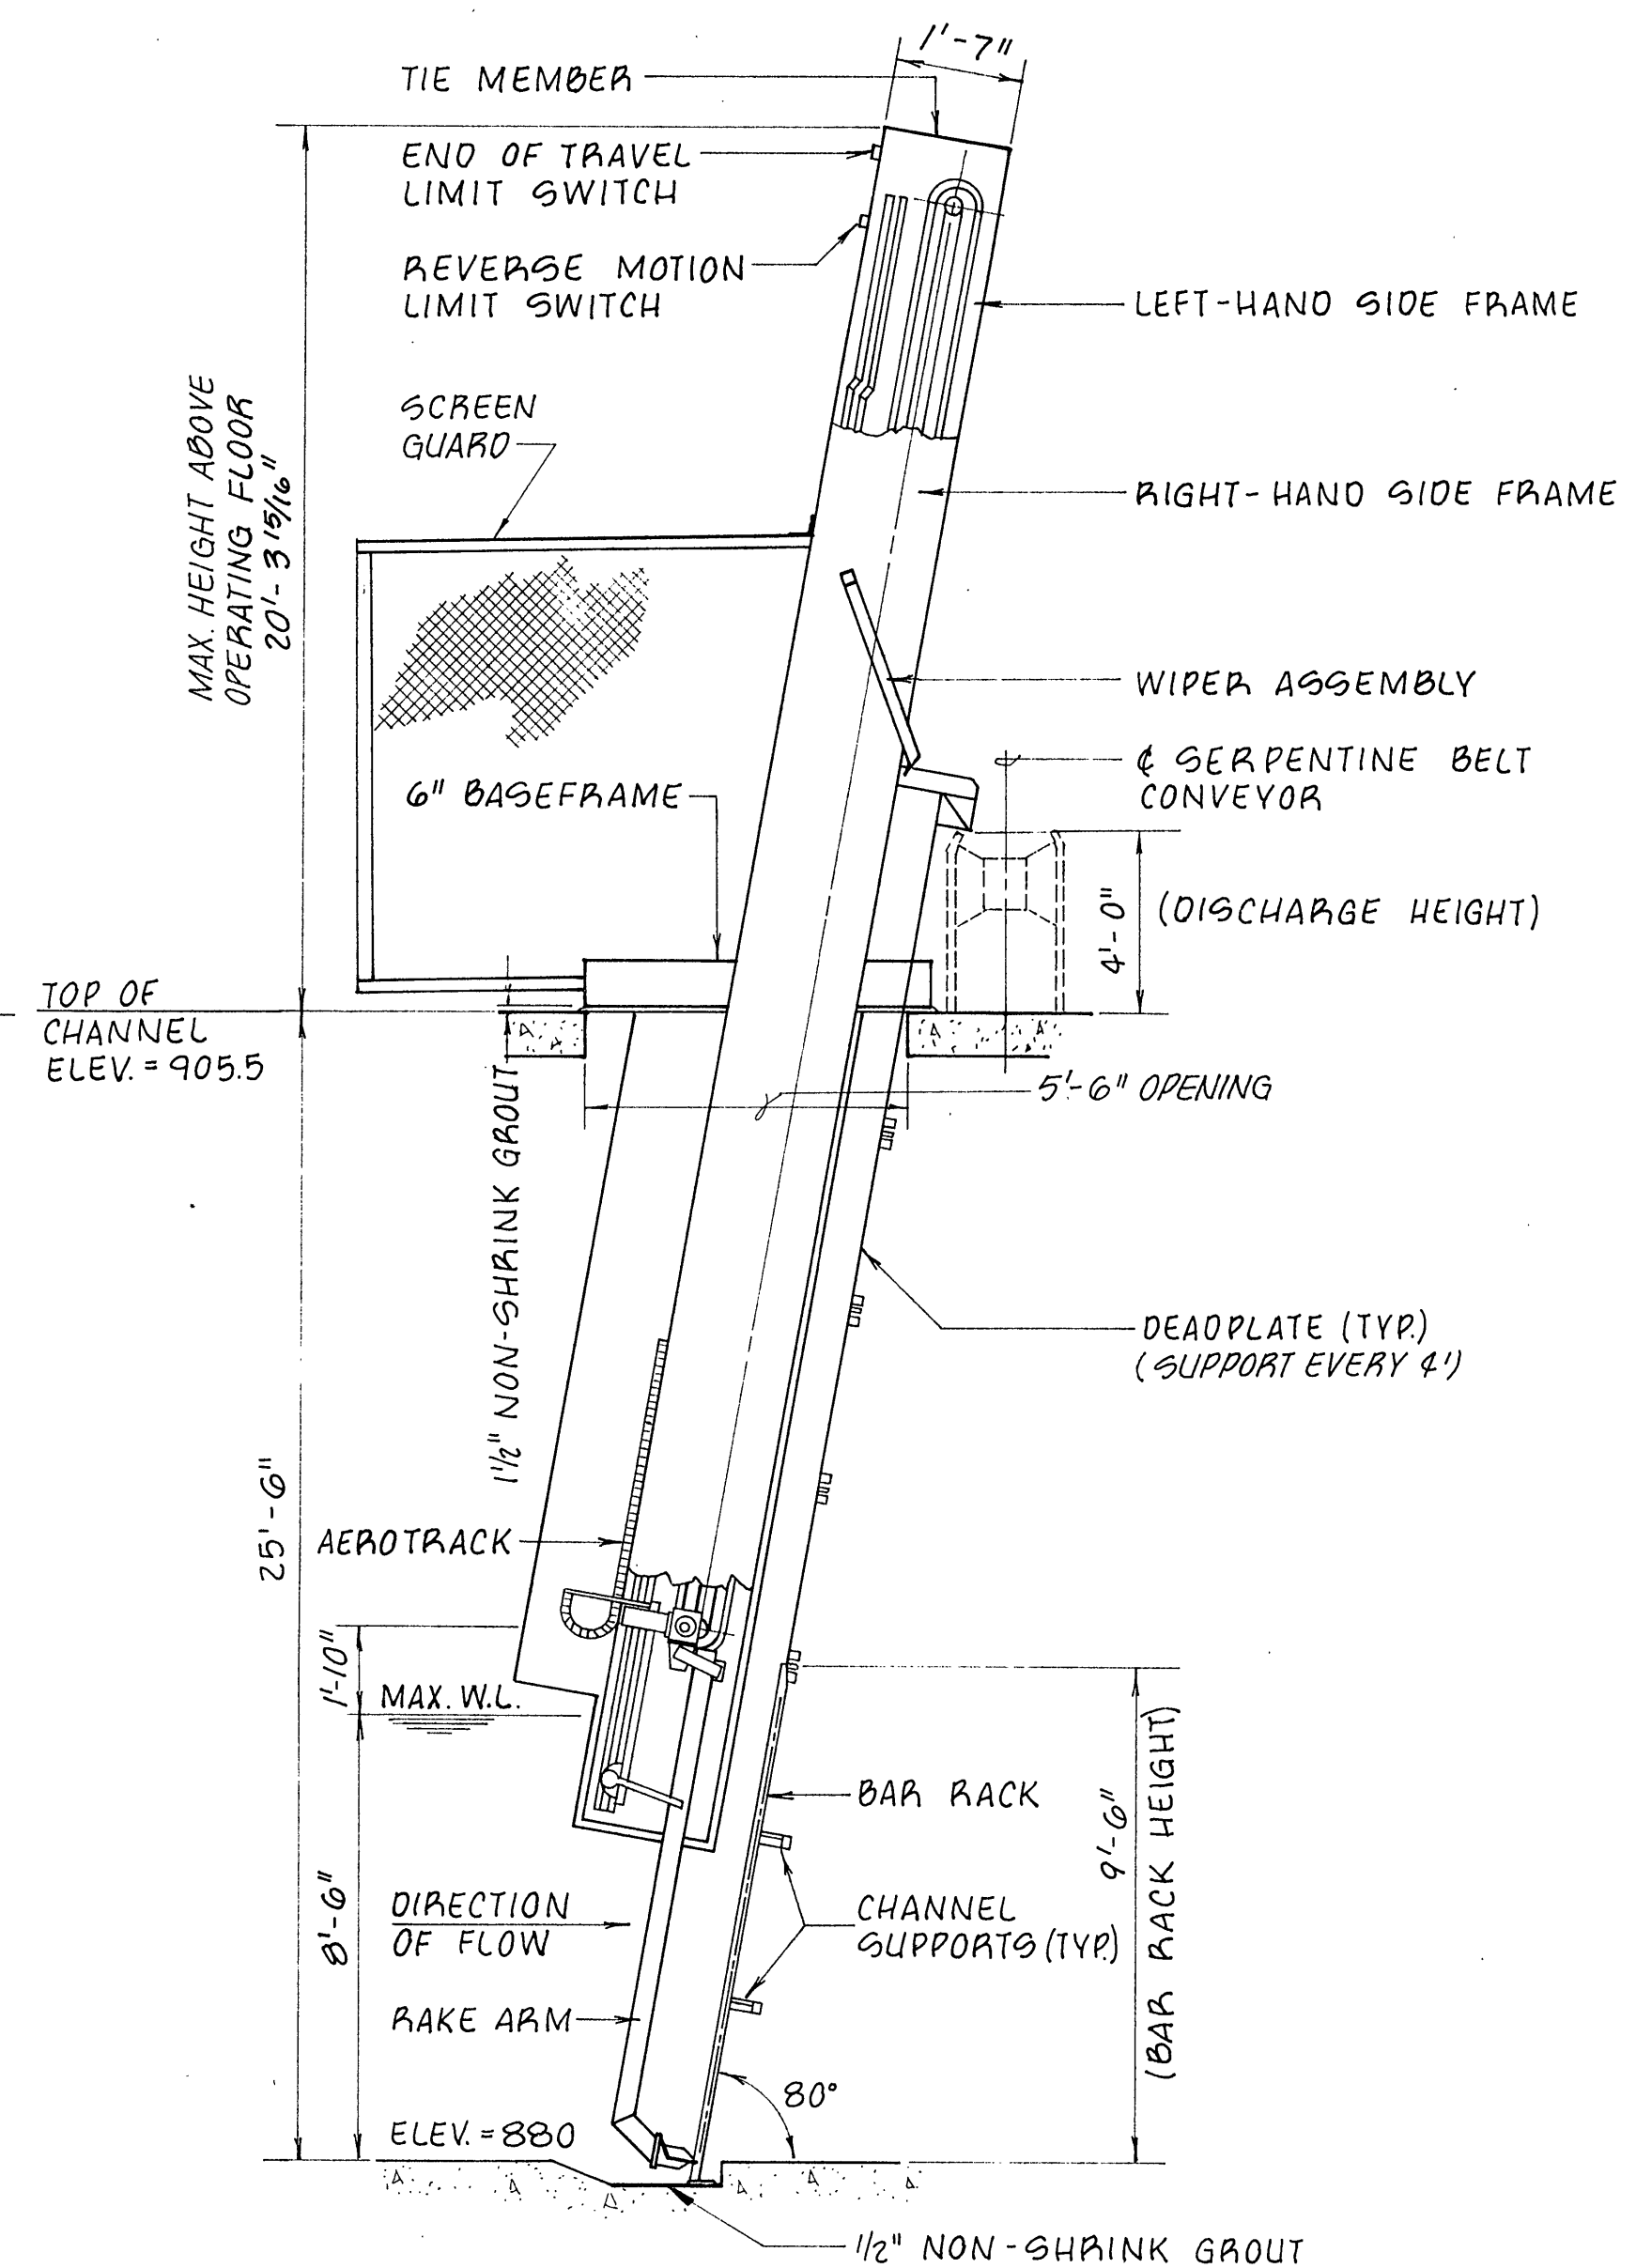

RIGHT SIDE ELEVATION

MECHANICALLY CLEANED BAR SCREEN

Not To Scale

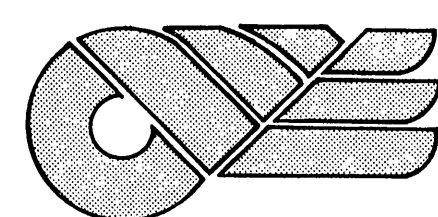


CLEAN WATER ENGINEERS, INC.

P.O. BOX 218
FINCASTLE, VIRGINIA 24090

P.O. BOX 3225
STAUNTON VIRGINIA, 24401

HEADWORKS IMPROVEMENTS
FOR
ROANOKE CITY
WASTEWATER TREATMENT FACILITY
ROANOKE, VIRGINIA

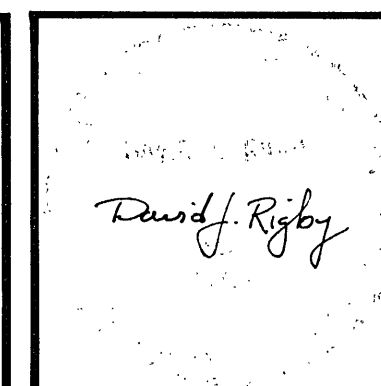

REVISIONS		
NO.	DATE	BY

DESIGNED: CES	SHEET: 4 OF 8
DRAWN: TAM	SCALE: AS SHOWN
CHECKED: CES/CCB	DATE: NOV., 1987
APPROVED: DJR	PROJECT: F87025