



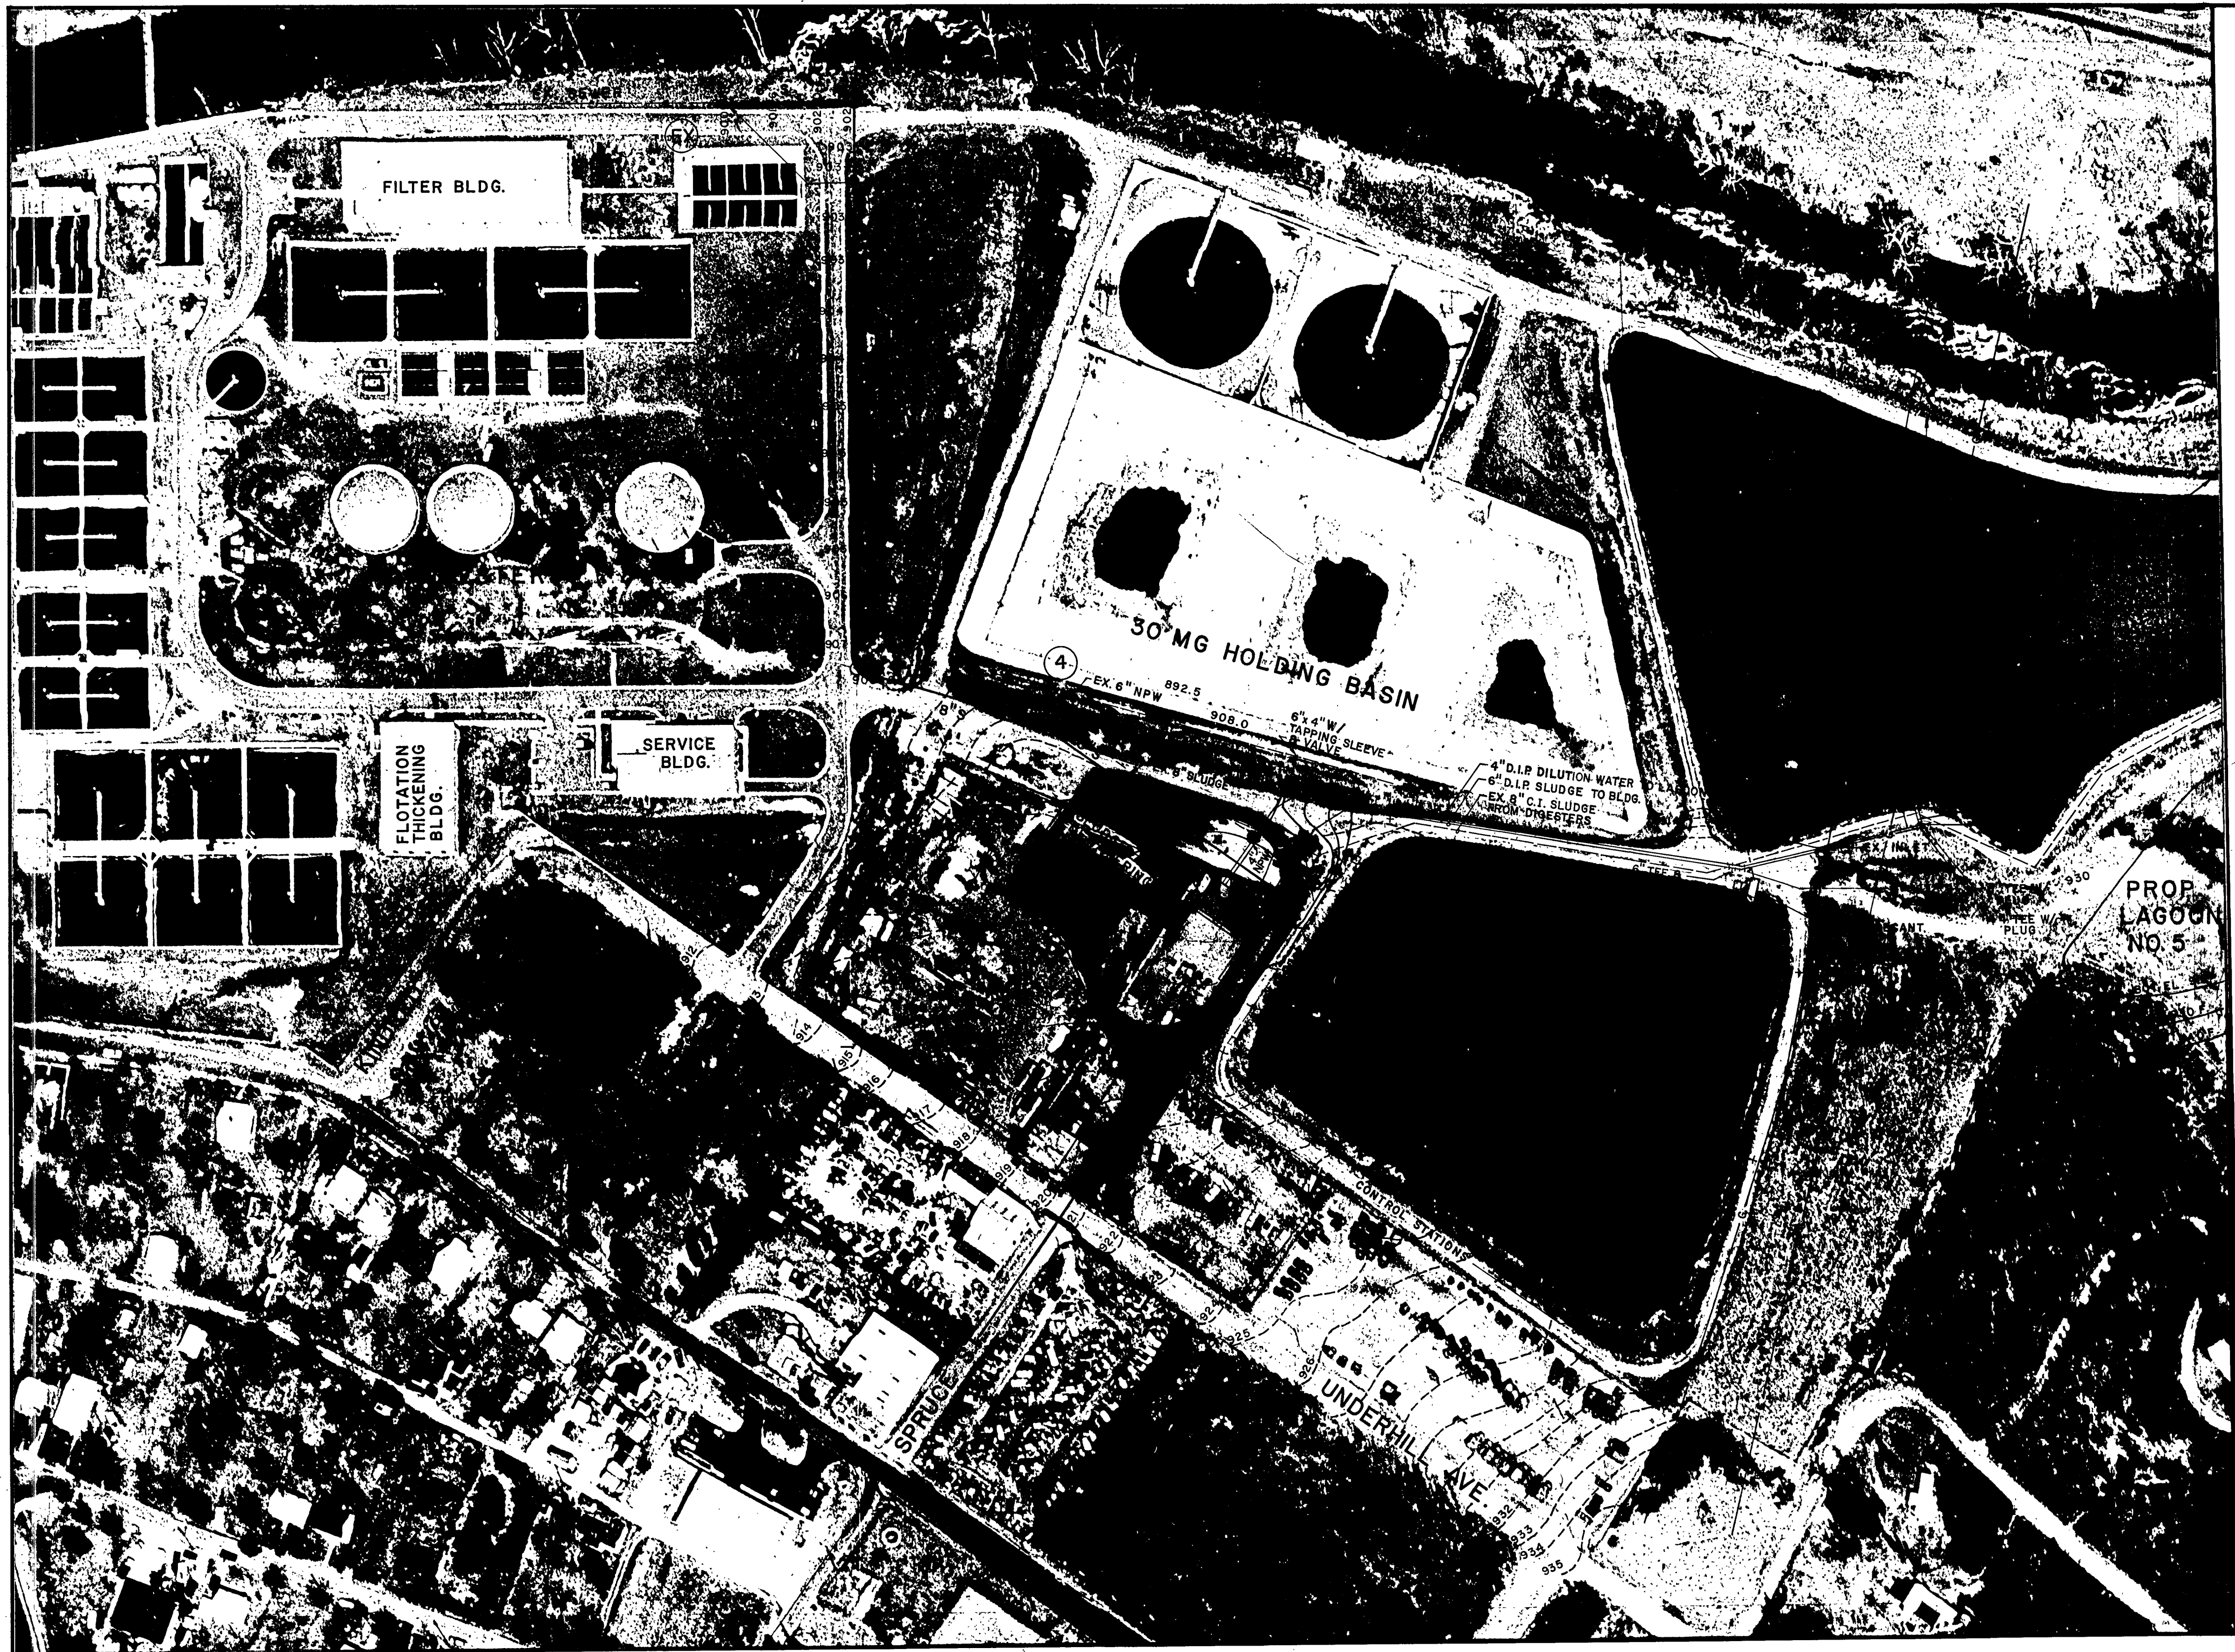


GENERAL NOTES:



THE LOCATIONS OF EXISTING UTILITIES WERE OBTAINED FROM AVAILABLE RECORDS. IMMEDIATELY AFTER AWARD OF THE CONTRACT, AND PRIOR TO ANY PIPE LAYING, THE CONTRACTOR SHALL DIG TEST PITS AT ALL UTILITY CROSSINGS AND CONNECTIONS TO DETERMINE THE EXACT LOCATION HORIZONTALLY AND VERTICALLY.

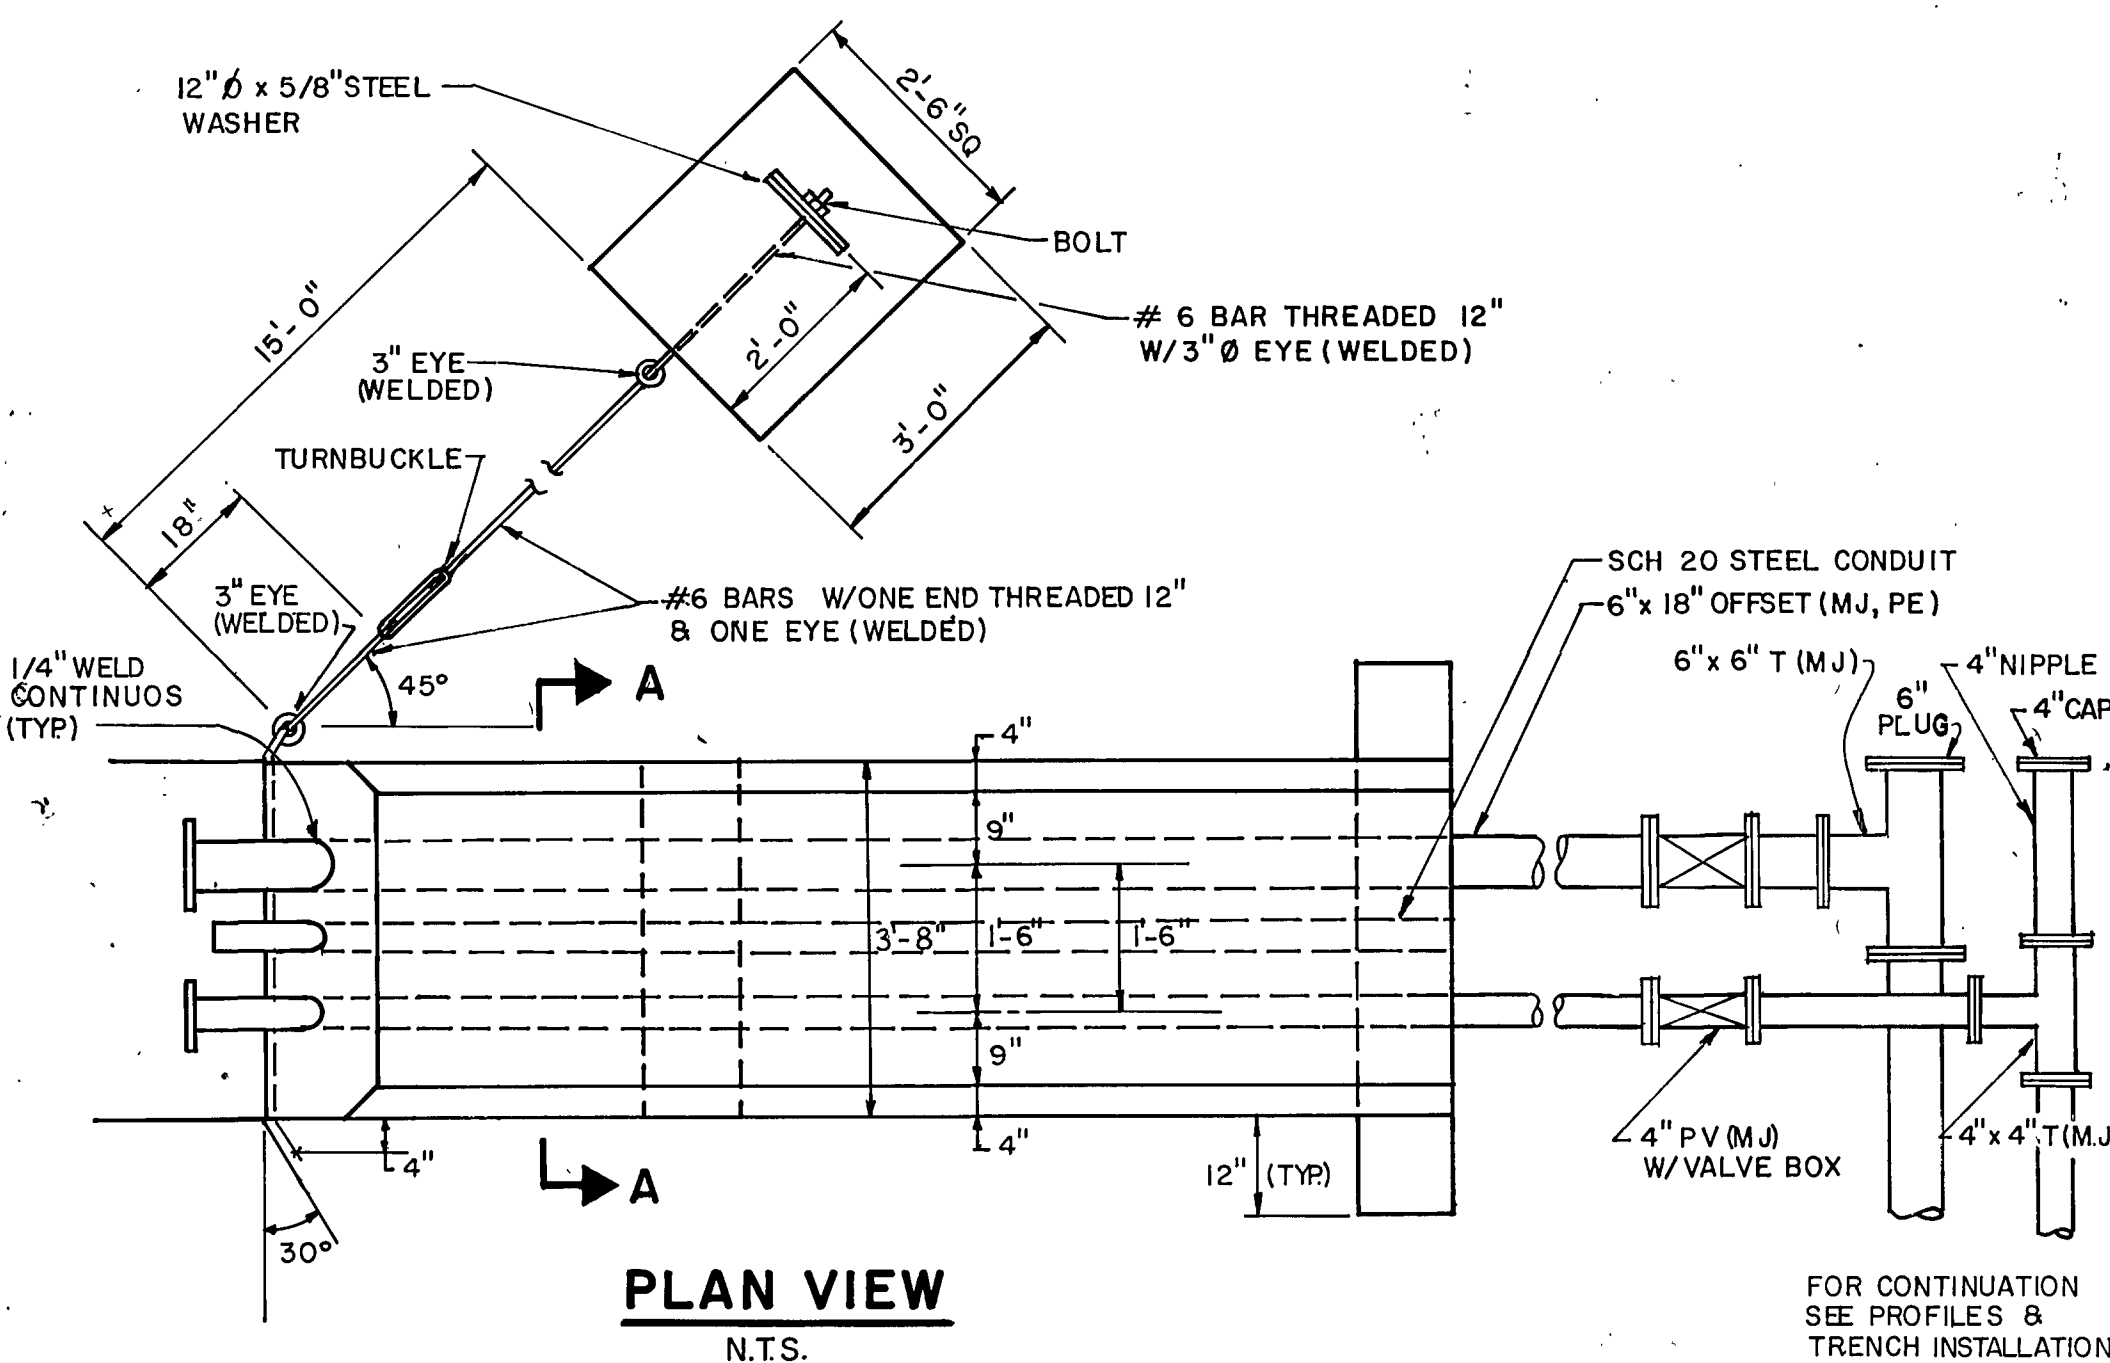

NOTE: TURN # 6 ANCHOR BARS DOWN 15°-SET BLOCK (DEADMAN) IN PLANE OF BAR(15°)

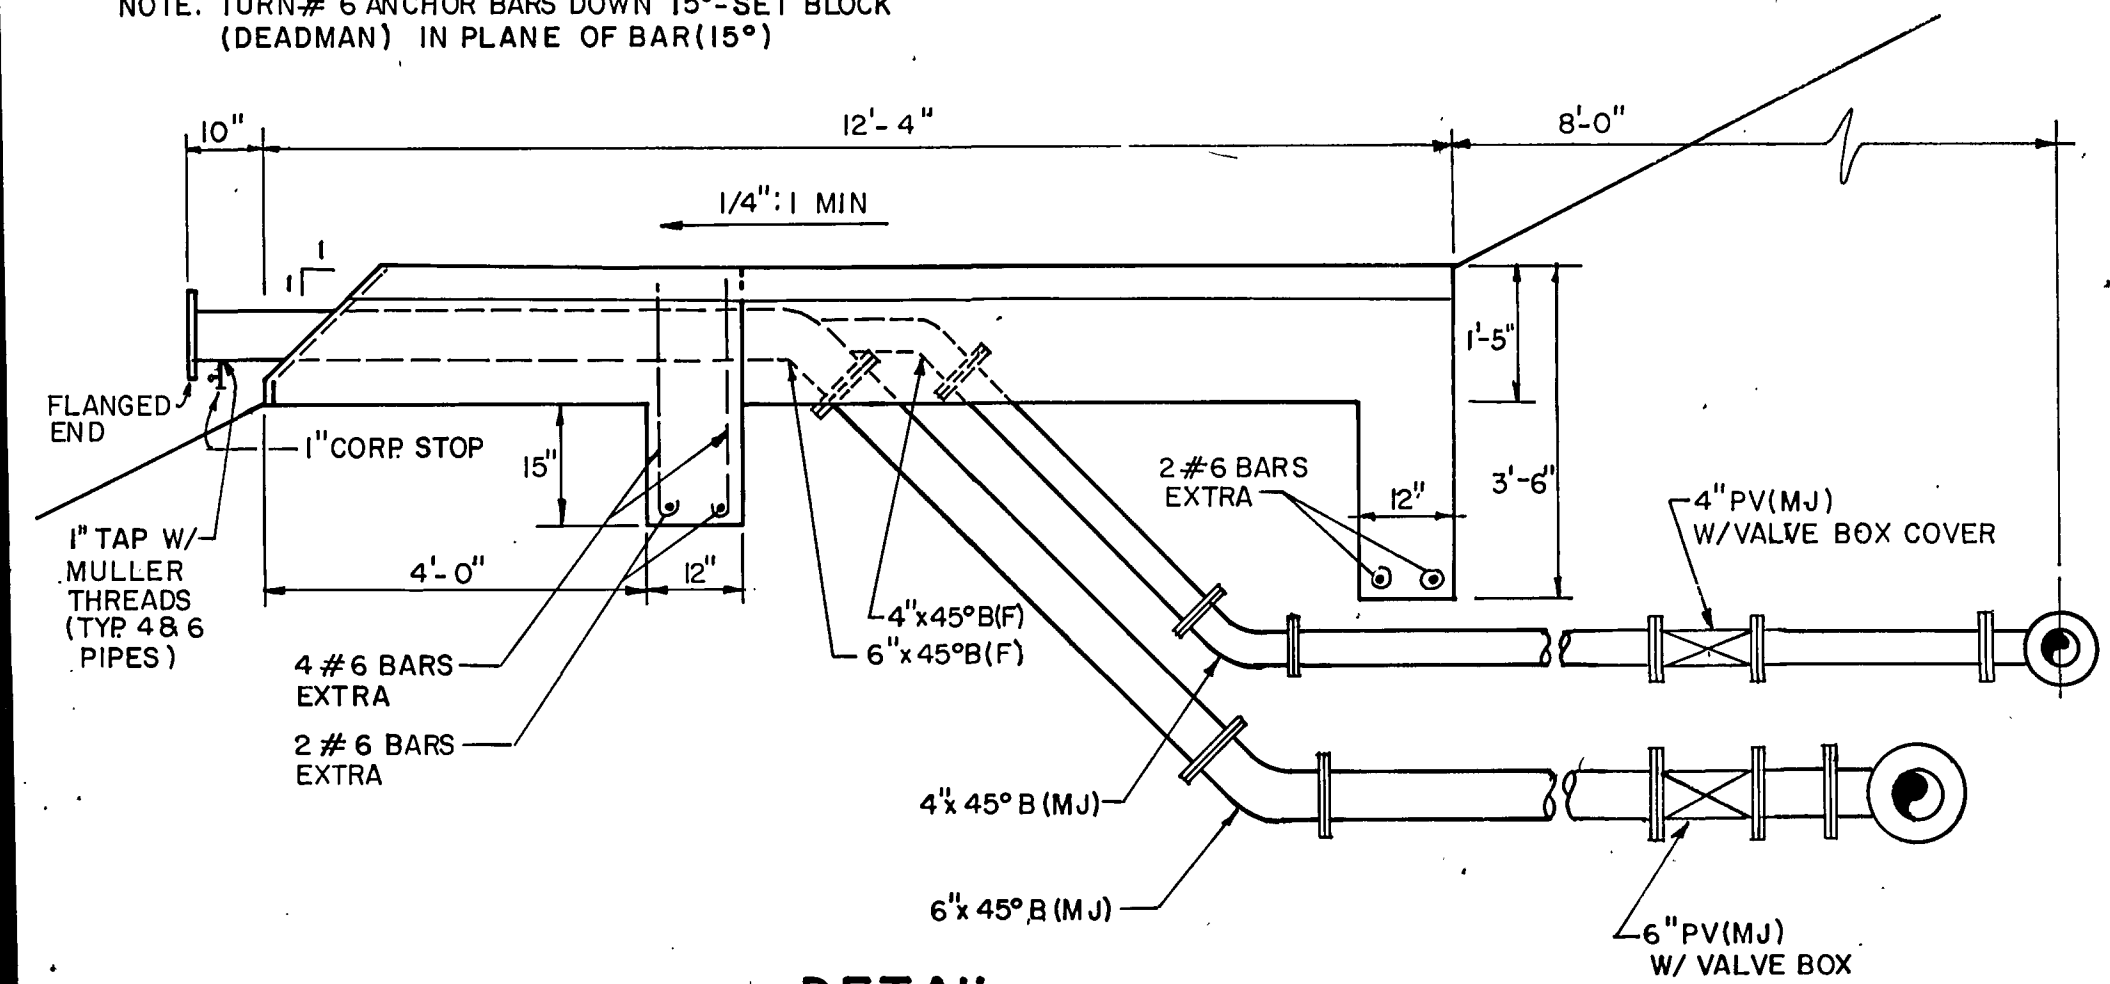

DETAIL
FLEXIBLE PIPE CONNECTION AT BARGE
CONTROL STATION
N.T.S.

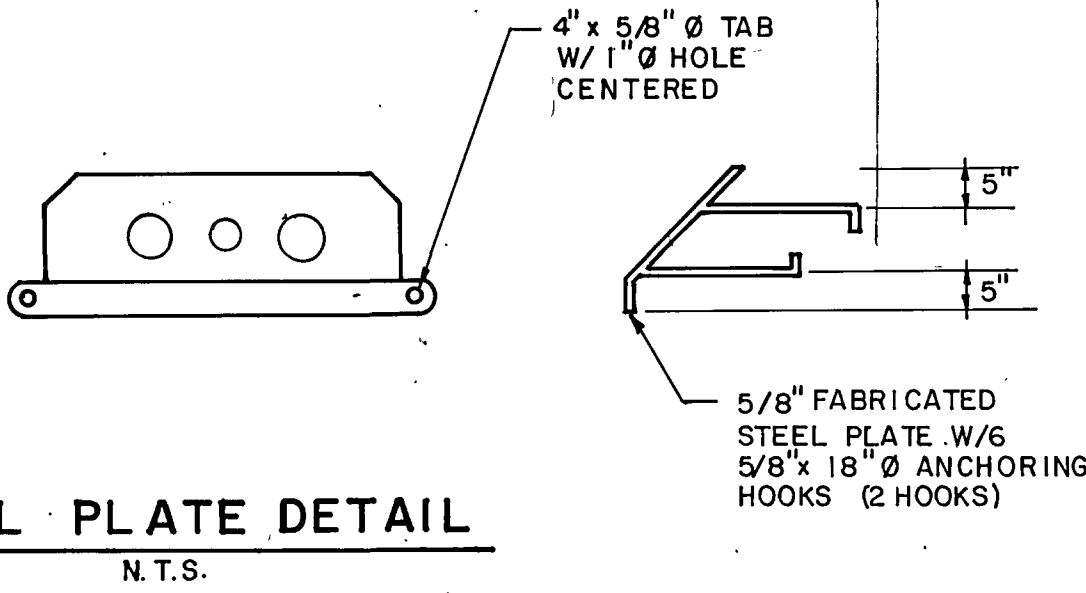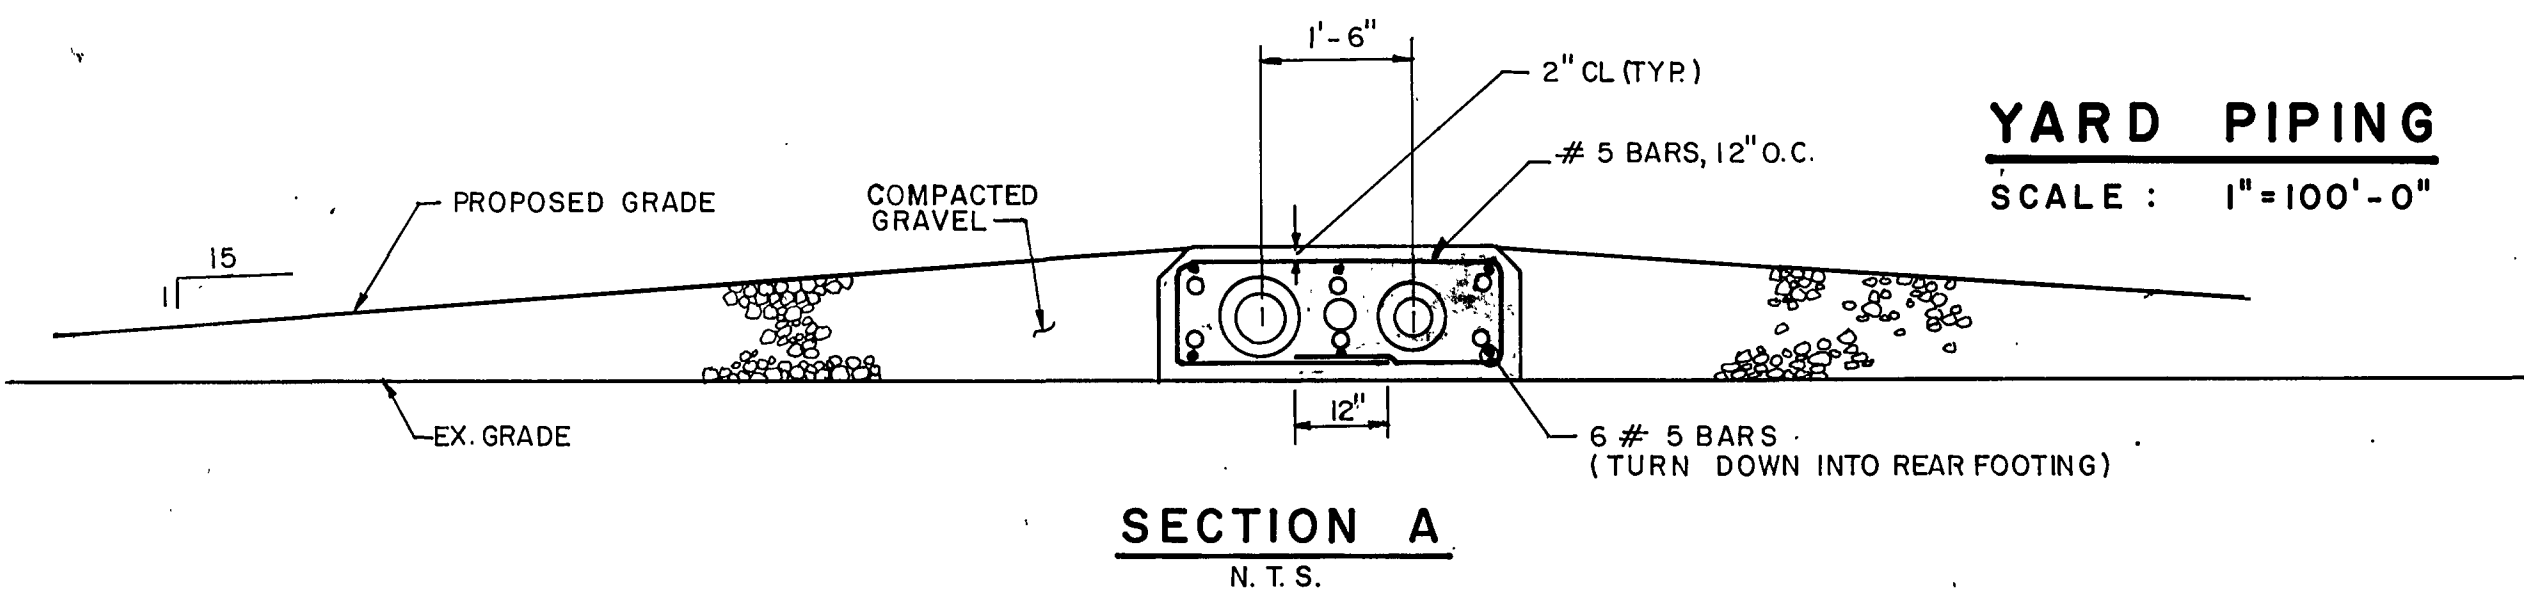

NO.	DATE	DESCRIPTION
1		
2		

Dewberry & Davis

ENGINEERS ARCHITECTS PLANNERS SURVEYORS

8411 Arlington Boulevard Fairfax, Virginia 22031 Telephone 703-560-1100
19201 Montgomery Village Ave. Gaithersburg, Md. 20760 Tele.301-948-4120

PREPARED FOR
CITY OF ROANOKE
ROANOKE, VIRGINIA

CITY OF ROANOKE WASTEWATER TREATMENT PLANT
SLUDGE DEWATERING FACILITIES

YARD PIPING PLAN

SCALE:
1" = 100'-0"
DATE:
AUG. 1981
DESIGNED BY:
RLN
DRAFTED BY:
BPC

SHEET
4
OF
33
FILE NUMBER