



GENERAL NOTES

1. ALL HOSE BIBS SHALL INCLUDE HOSE RACKS AND 20' HOSE WITH HAND CONTROL NOZZLE
2. PROVIDE 6" KICKPLATE CENTERED BELOW HANDRAIL

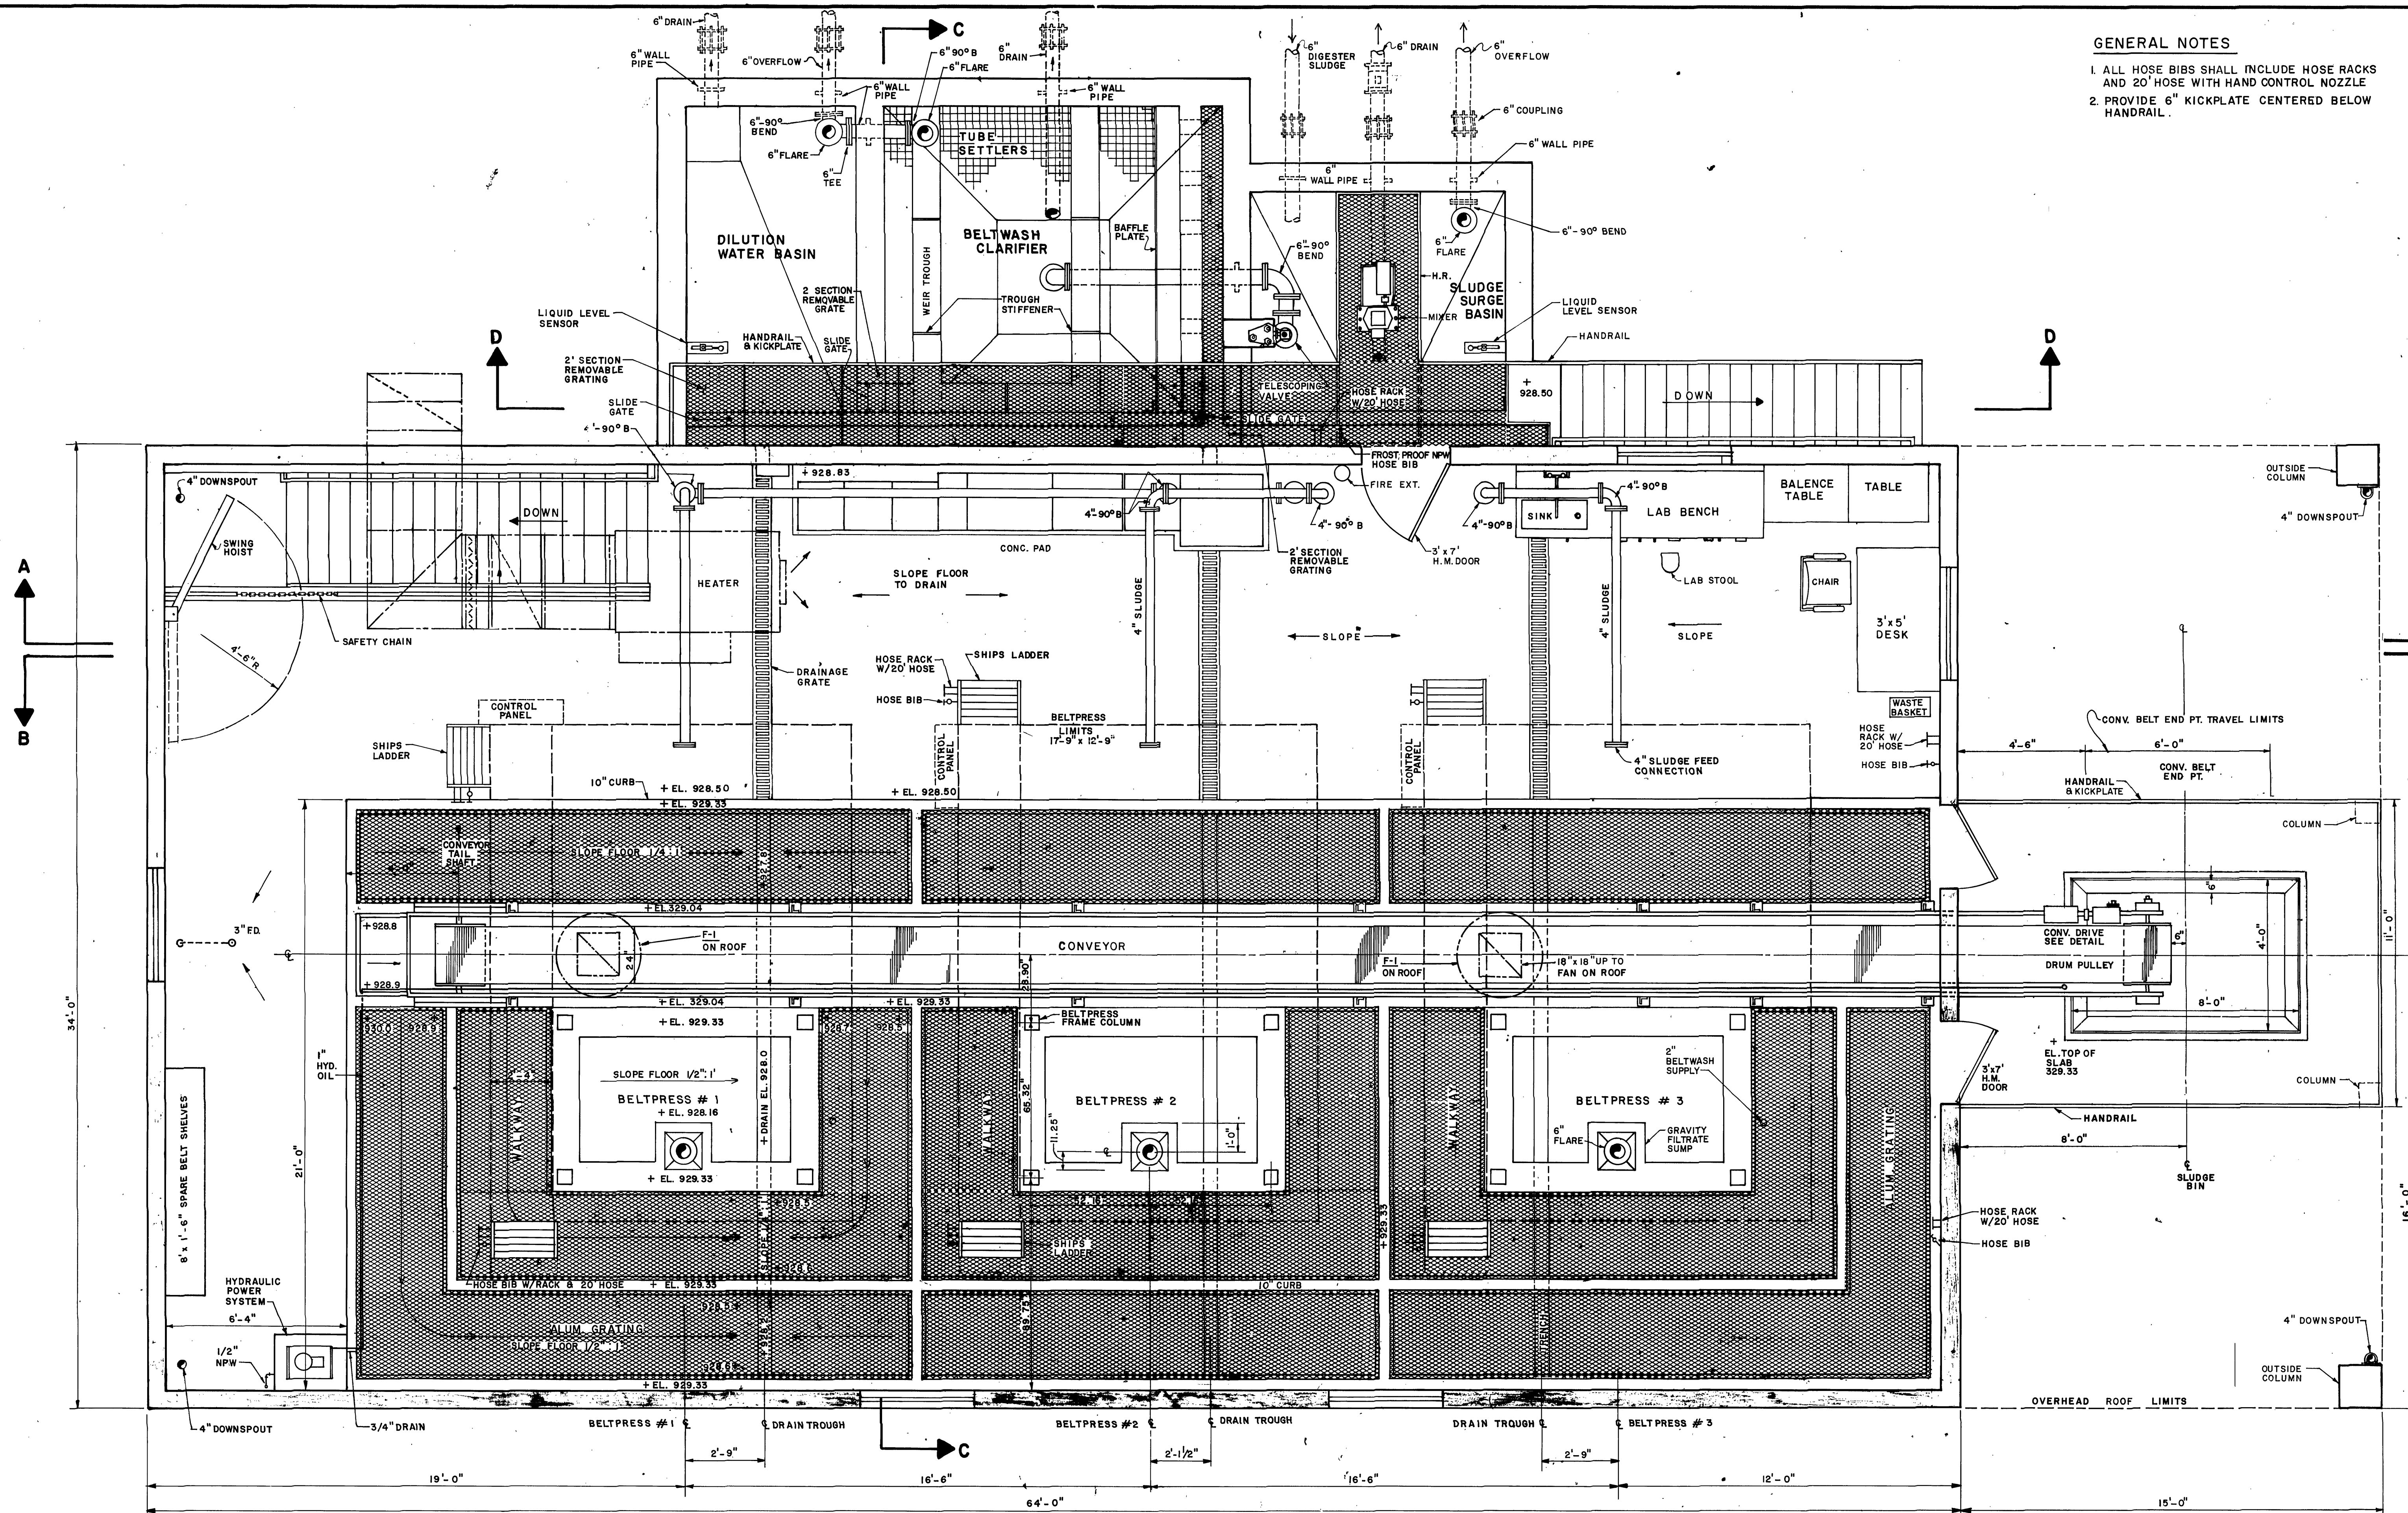

UPPER LEVEL FLOOR PLAN

REVISIONS	
NO.	DESCRIPTION
2	
1	

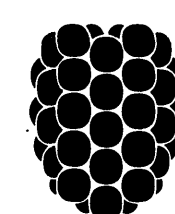

Dewberry & Davis
ENGINEERS ARCHITECTS PLANNERS SURVEYORS
8411 Arlington Boulevard Fairfax, Virginia 22031 Telephone 703-560-1100
19201 Montgomery Village Ave. Gaithersburg, Md. 20760 Tele. 301-948-4120

PREPARED FOR
CITY OF ROANOKE
ROANOKE, VIRGINIA

CITY OF ROANOKE WASTEWATER TREATMENT PLANT
SLUDGE DEWATERING FACILITIES

**SLUDGE DEWATERING BUILDING
UPPER LEVEL FLOOR PLAN**

SCALE:
3/8" = 1'-0"
DATE:
AUG. 1981
DESIGNED BY:
JBC
DRAFTED BY:
RSR

SHEET
9
OF
33
FILE NUMBER
PP 2967