




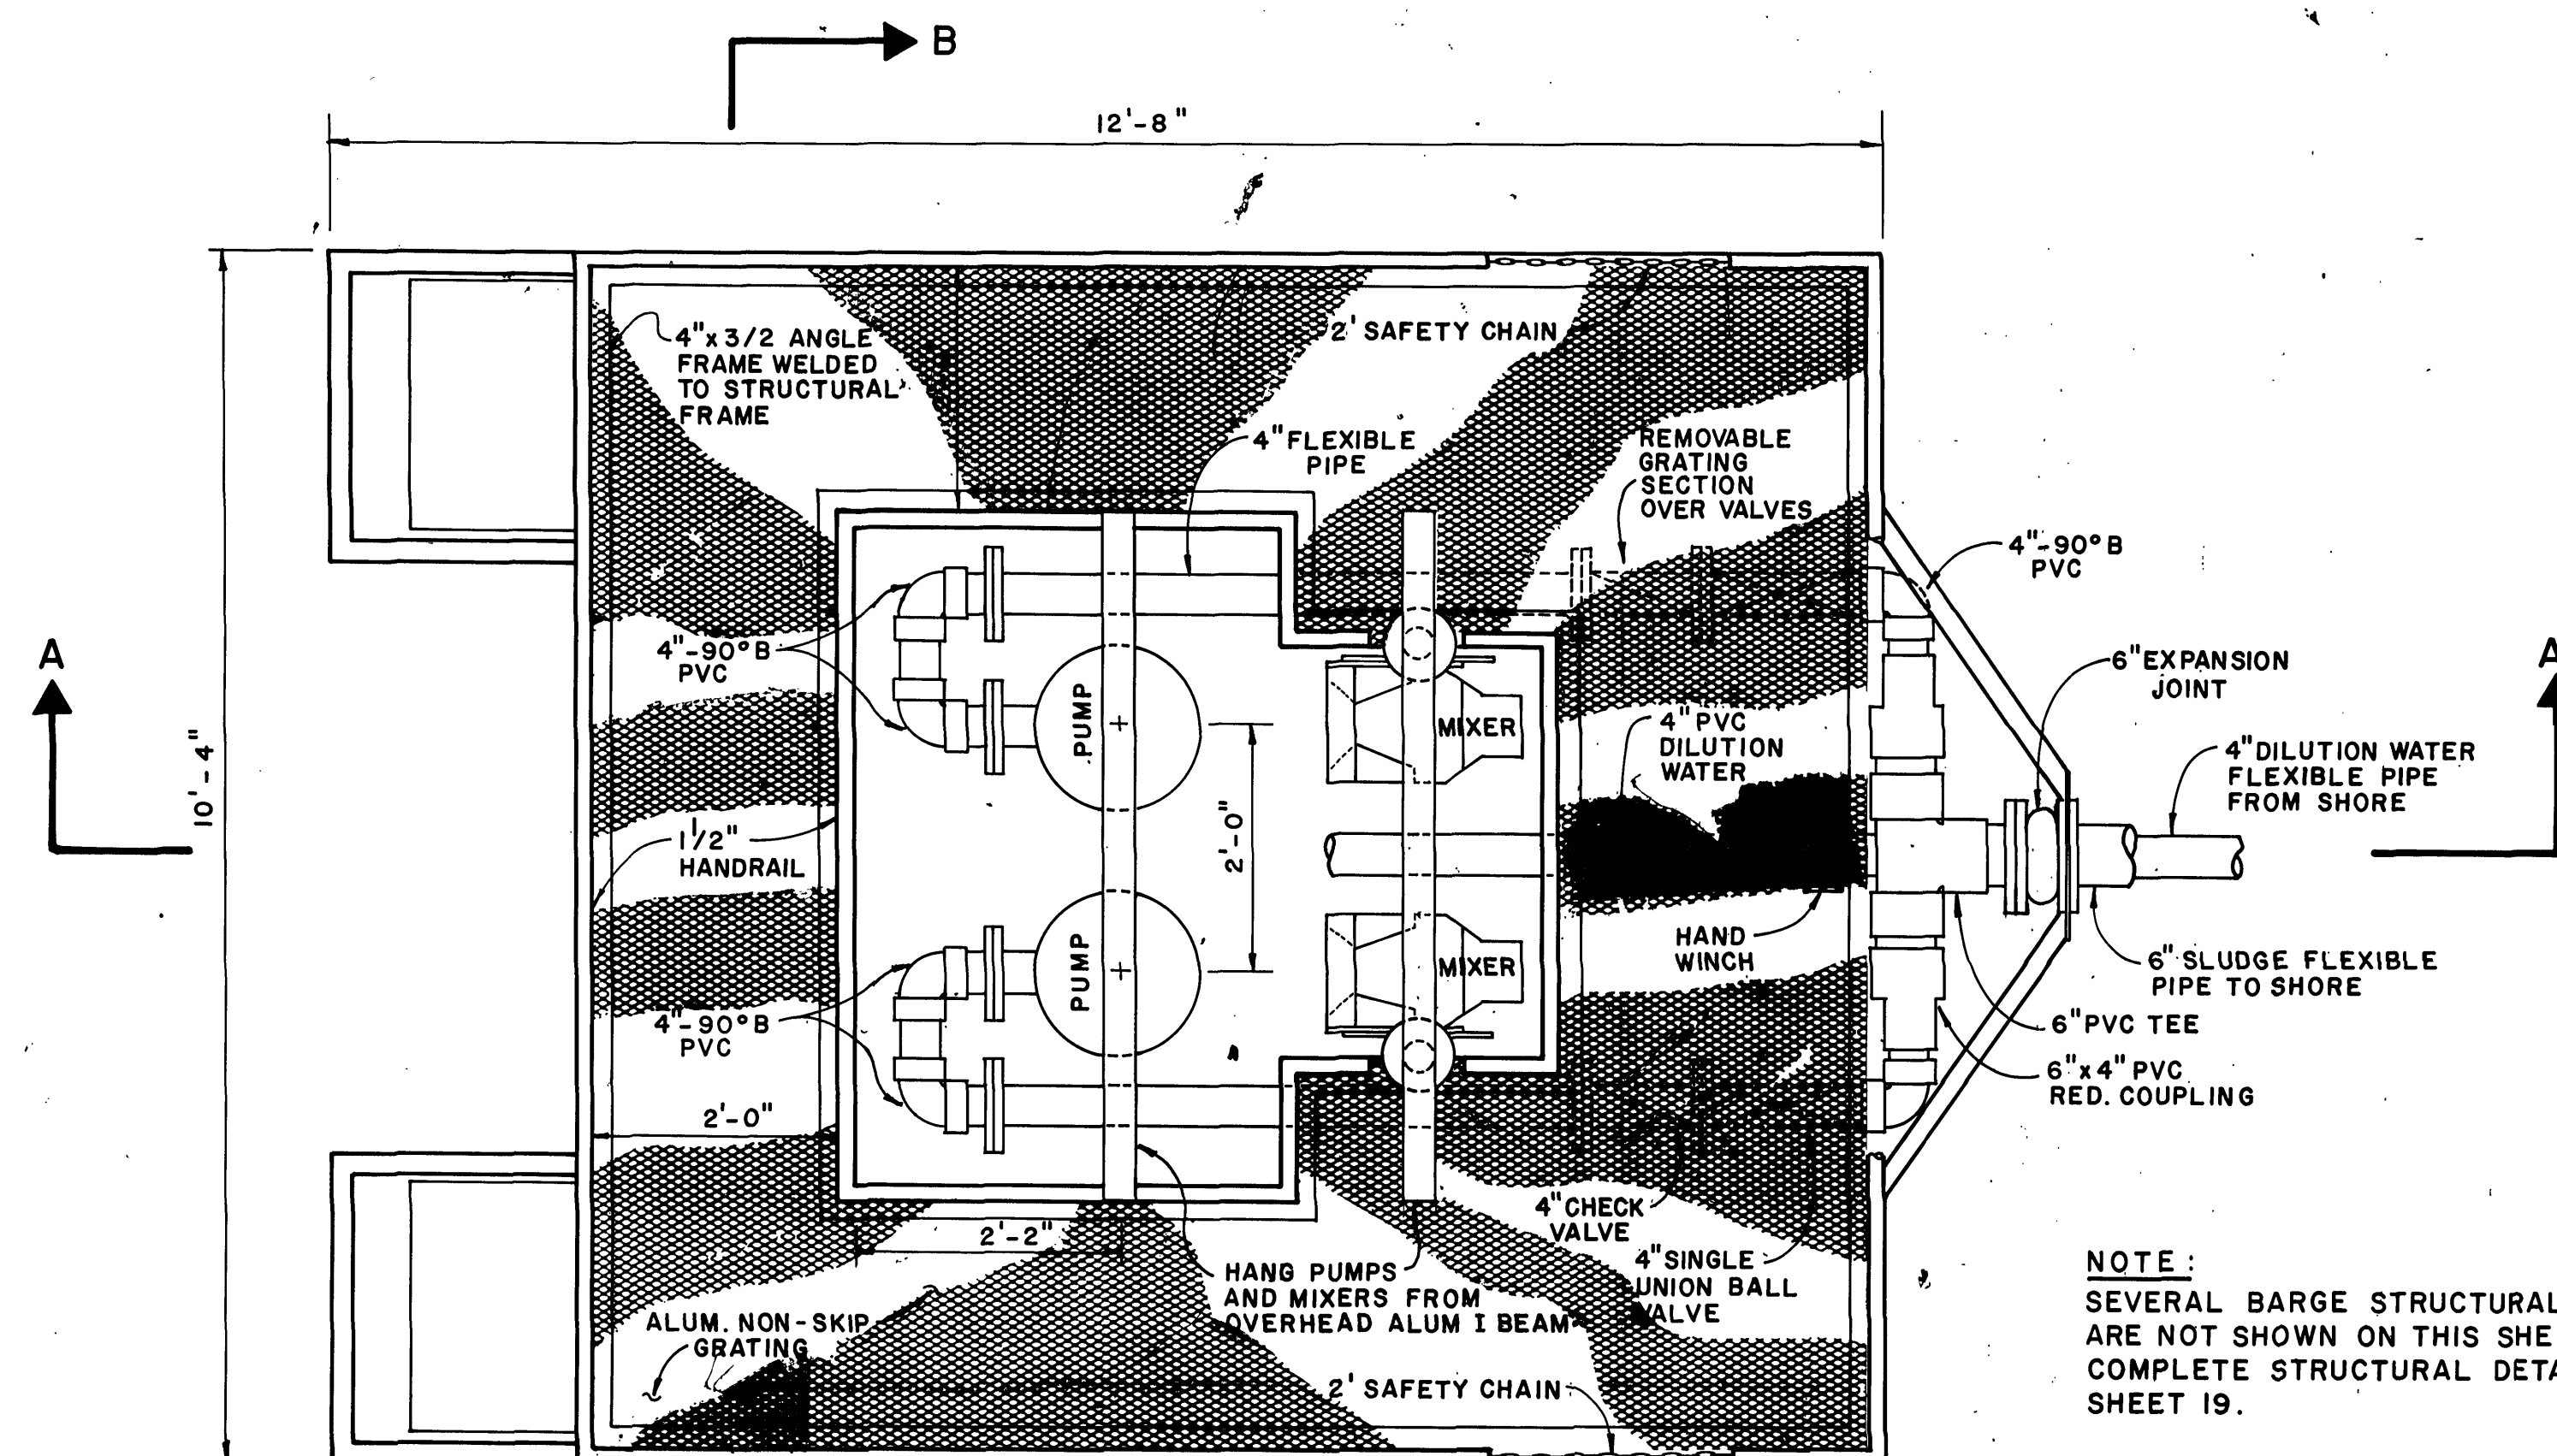


BARGE - PLAN
SCALE: 3/4" = 1'-0"

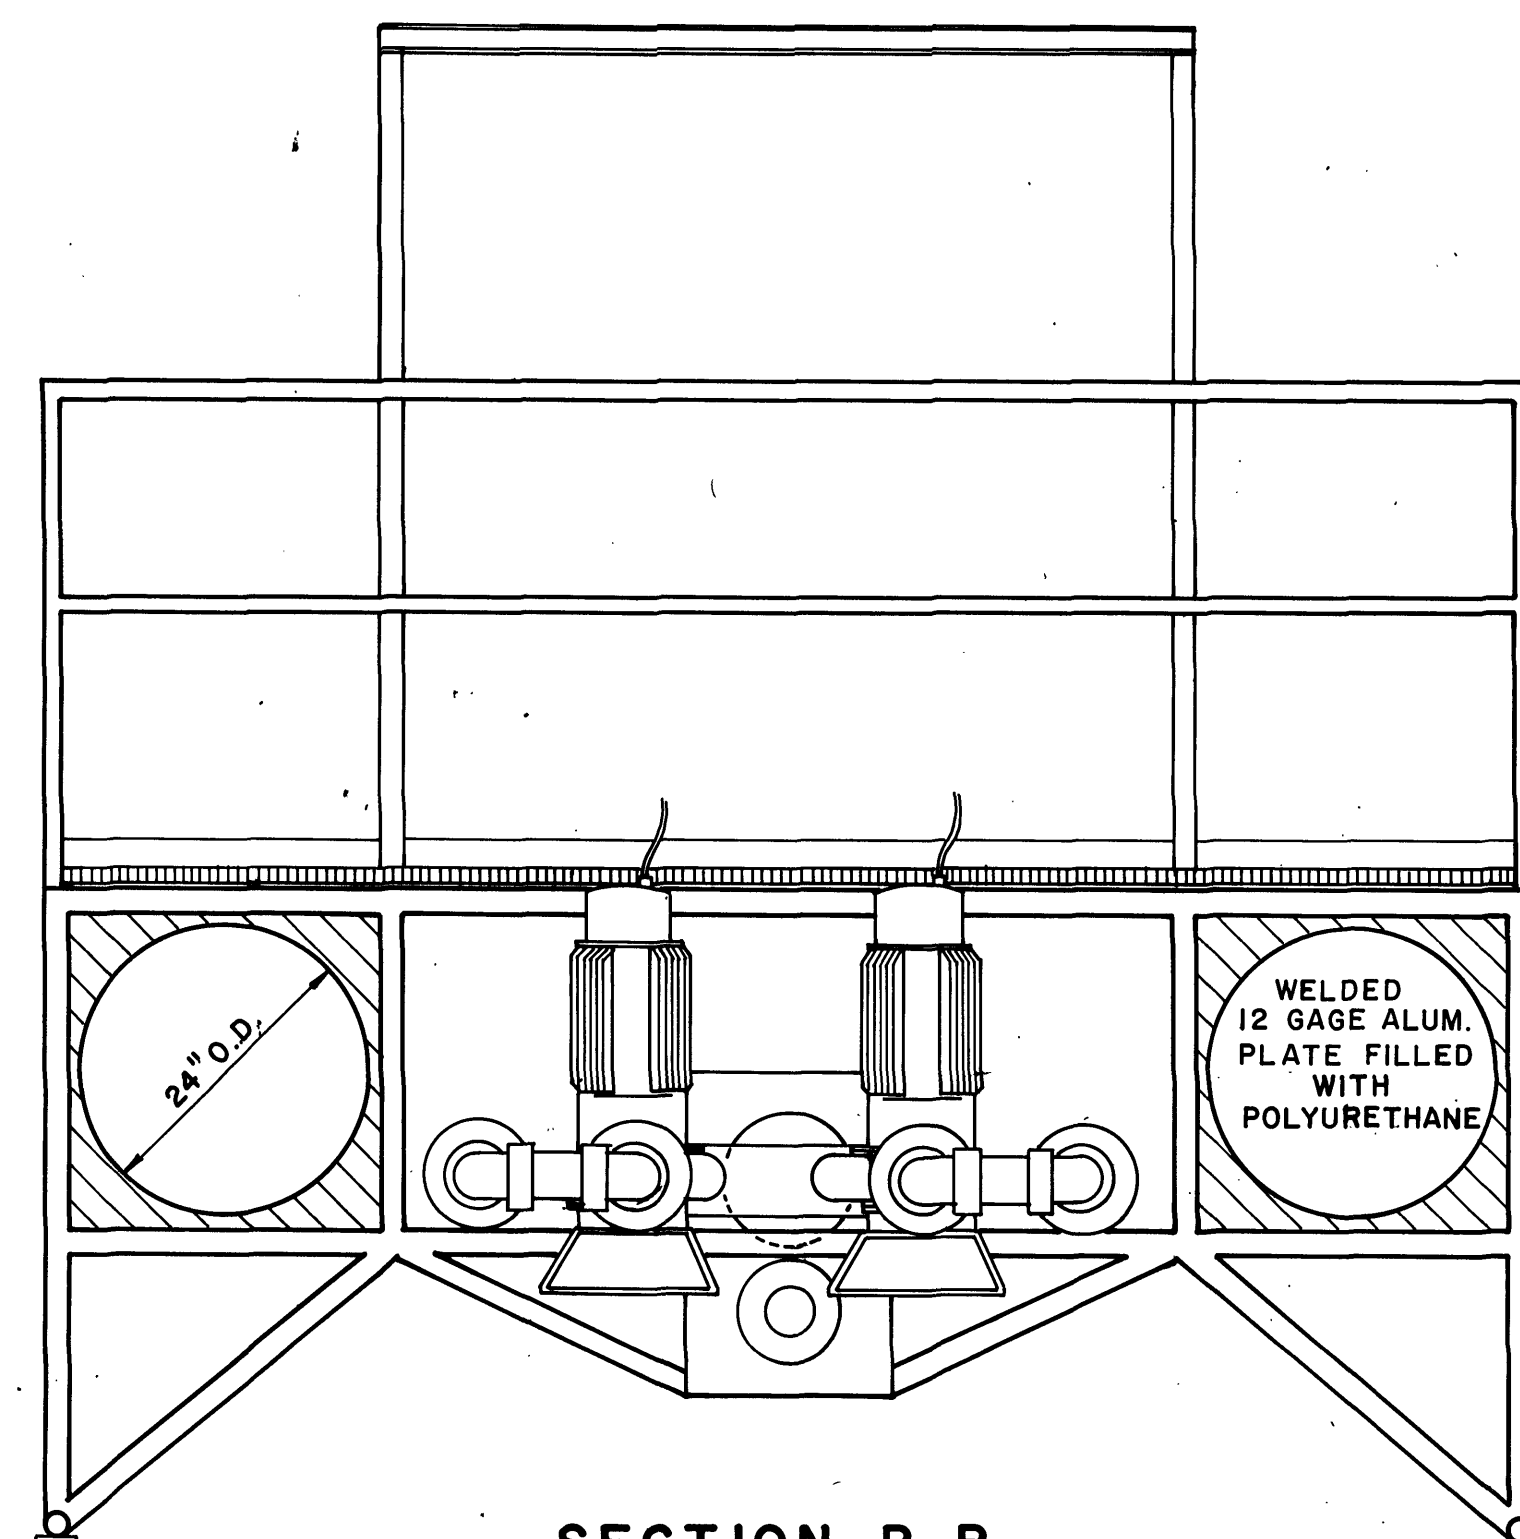

SECTION B-B
SCALE: 3/4" = 1'-0"

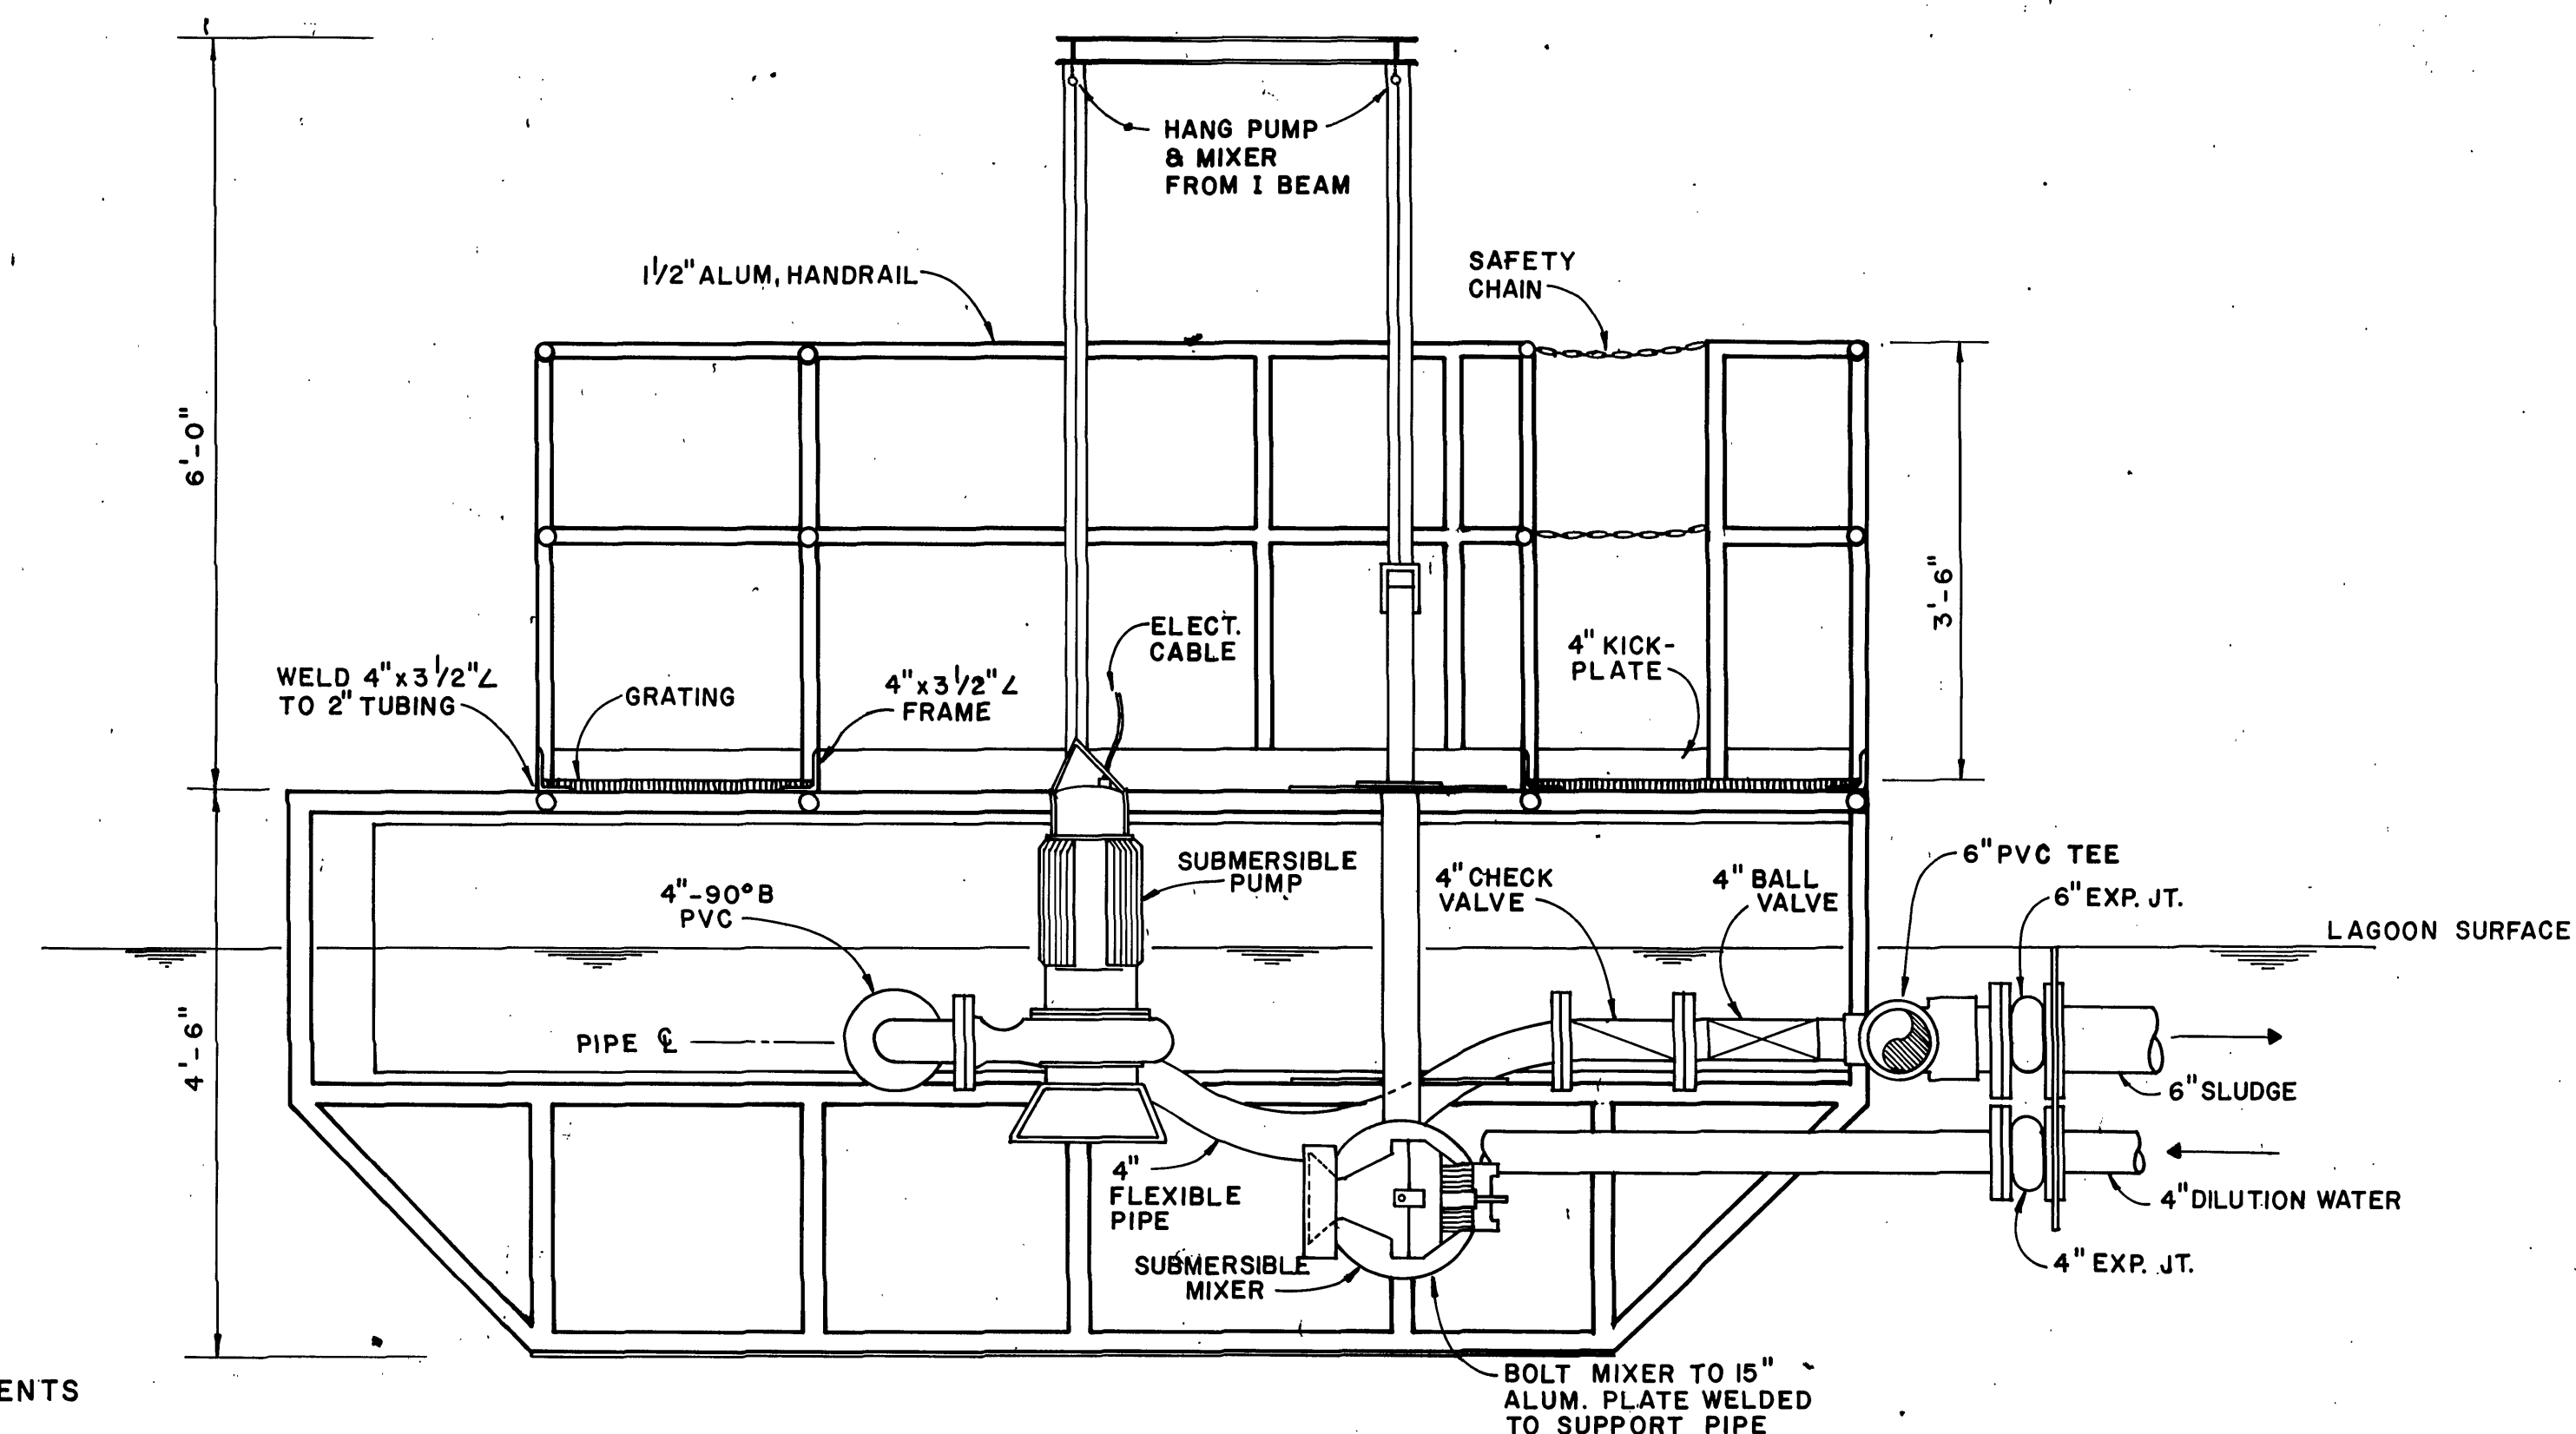

SECTION A-A
SCALE: 3/4" = 1'-0"

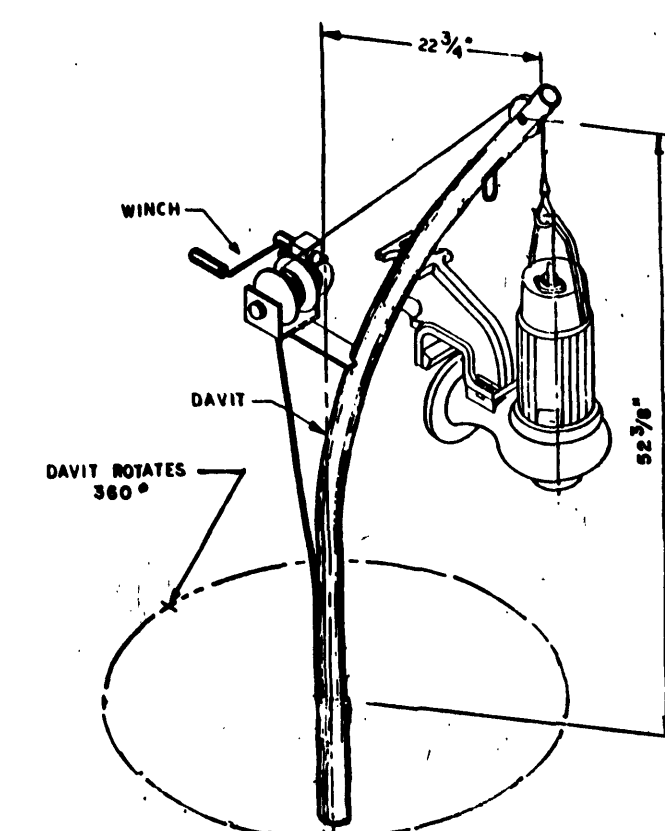

PORTABLE HOIST DETAIL
N.T.S.


NO.	DATE	DESCRIPTION
2		
1		

REVISIONS

Dewberry & Davis

ENGINEERS ARCHITECTS PLANNERS SURVEYORS

8411 Arlington Boulevard Fairfax, Virginia 22031 Telephone 703-560-1100
19201 Montgomery Village Ave. Gaithersburg, Md. 20760 Tele. 301-948-4120

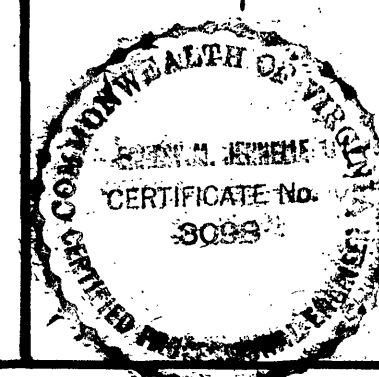

PREPARED FOR
CITY OF ROANOKE
ROANOKE, VIRGINIA

CITY OF ROANOKE WASTEWATER TREATMENT PLANT
SLUDGE DEWATERING FACILITIES

BARGE MECHANICAL DETAILS

SCALE:
AS SHOWN
DATE:
AUG. 1981
DESIGNED BY:
JBC
DRAFTED BY:
DPC

SHEET
18
OF
33
FILE NUMBER
PP 2967