



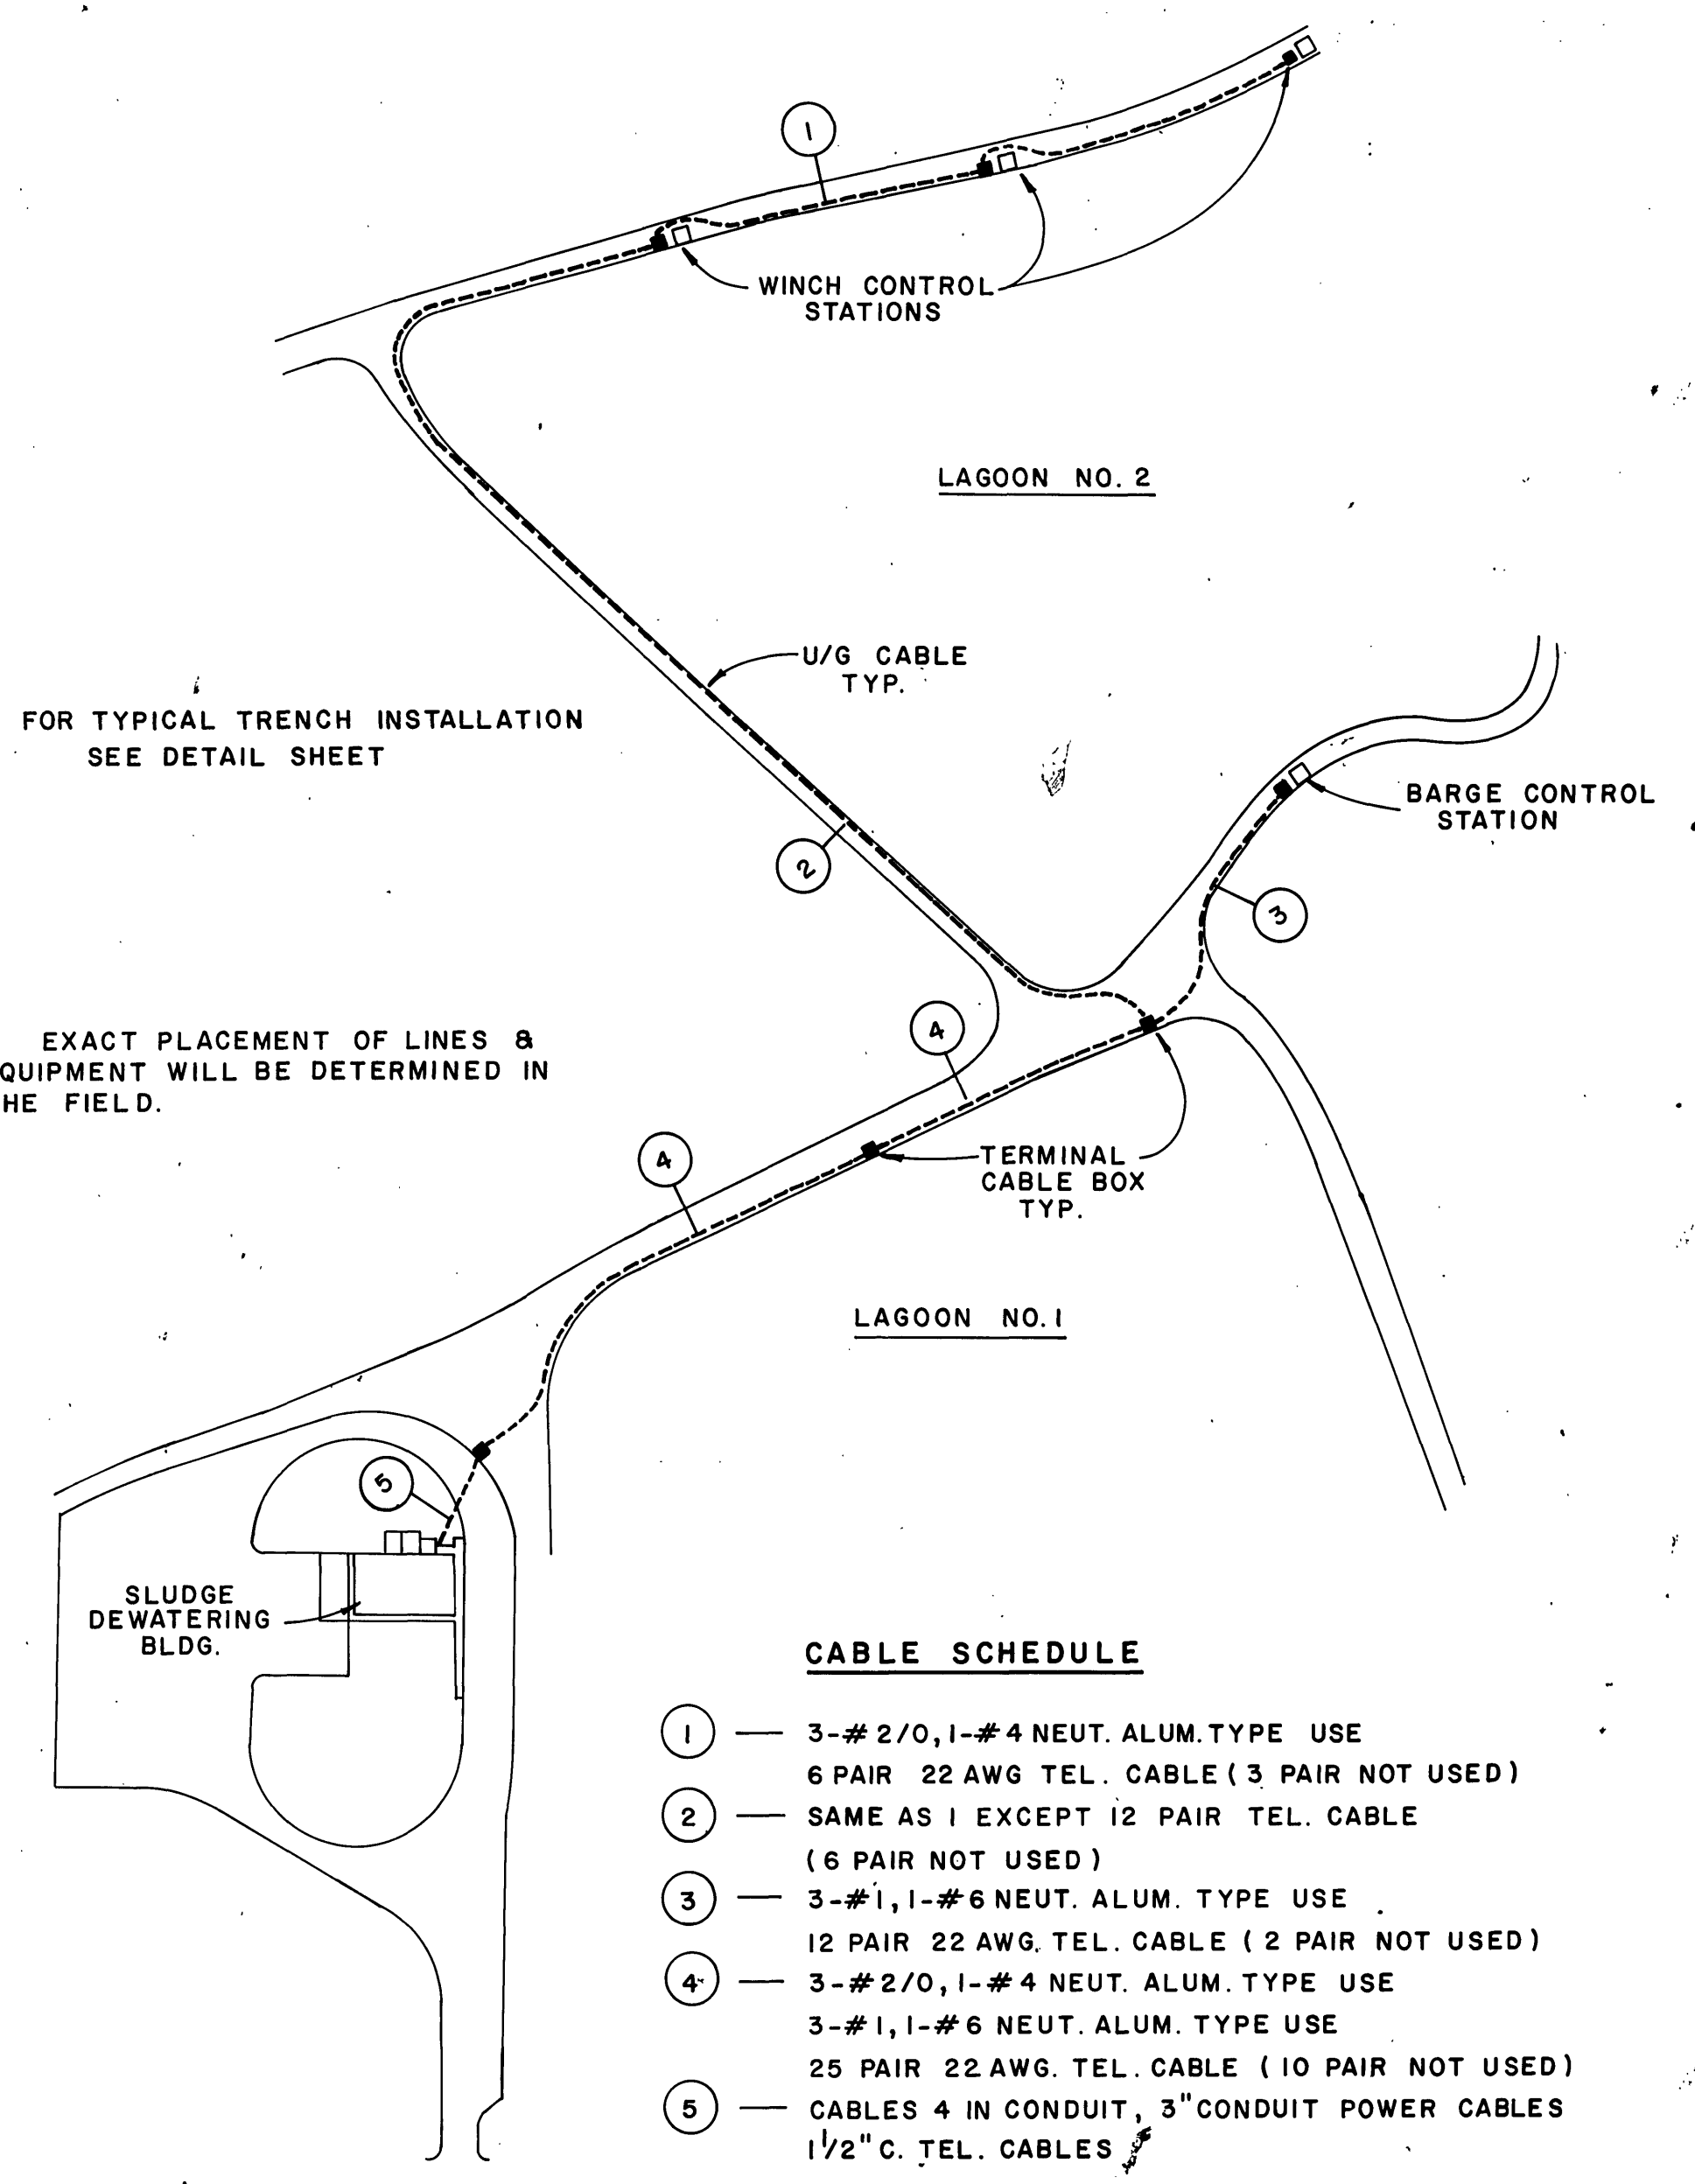


- CABLE SCHEDULE**
- ① — 3-# 2/0, 1-# 4 NEUT. ALUM. TYPE USE
6 PAIR 22 AWG TEL. CABLE (3 PAIR NOT USED)
 - ② — SAME AS ① EXCEPT 12 PAIR TEL. CABLE
(6 PAIR NOT USED)
 - ③ — 3-# 1, 1-# 6 NEUT. ALUM. TYPE USE
12 PAIR 22 AWG TEL. CABLE (2 PAIR NOT USED)
 - ④ — 3-# 2/0, 1-# 4 NEUT. ALUM. TYPE USE
3-# 1, 1-# 6 NEUT. ALUM. TYPE USE
25 PAIR 22 AWG TEL. CABLE (10 PAIR NOT USED)
 - ⑤ — CABLES 4 IN CONDUIT, 3" CONDUIT POWER CABLES
1 1/2" C. TEL. CABLES

**PLAN, SHOWING UNDERGROUND CABLE
CONSTRUCTION TO BARGE & WINCH STATIONS**
SCALE: 1" = 100'-0"
REFER TO SHEET 4 FOR EXACT LOCATION OF WINCH & BARGE CONTROL STATIONS

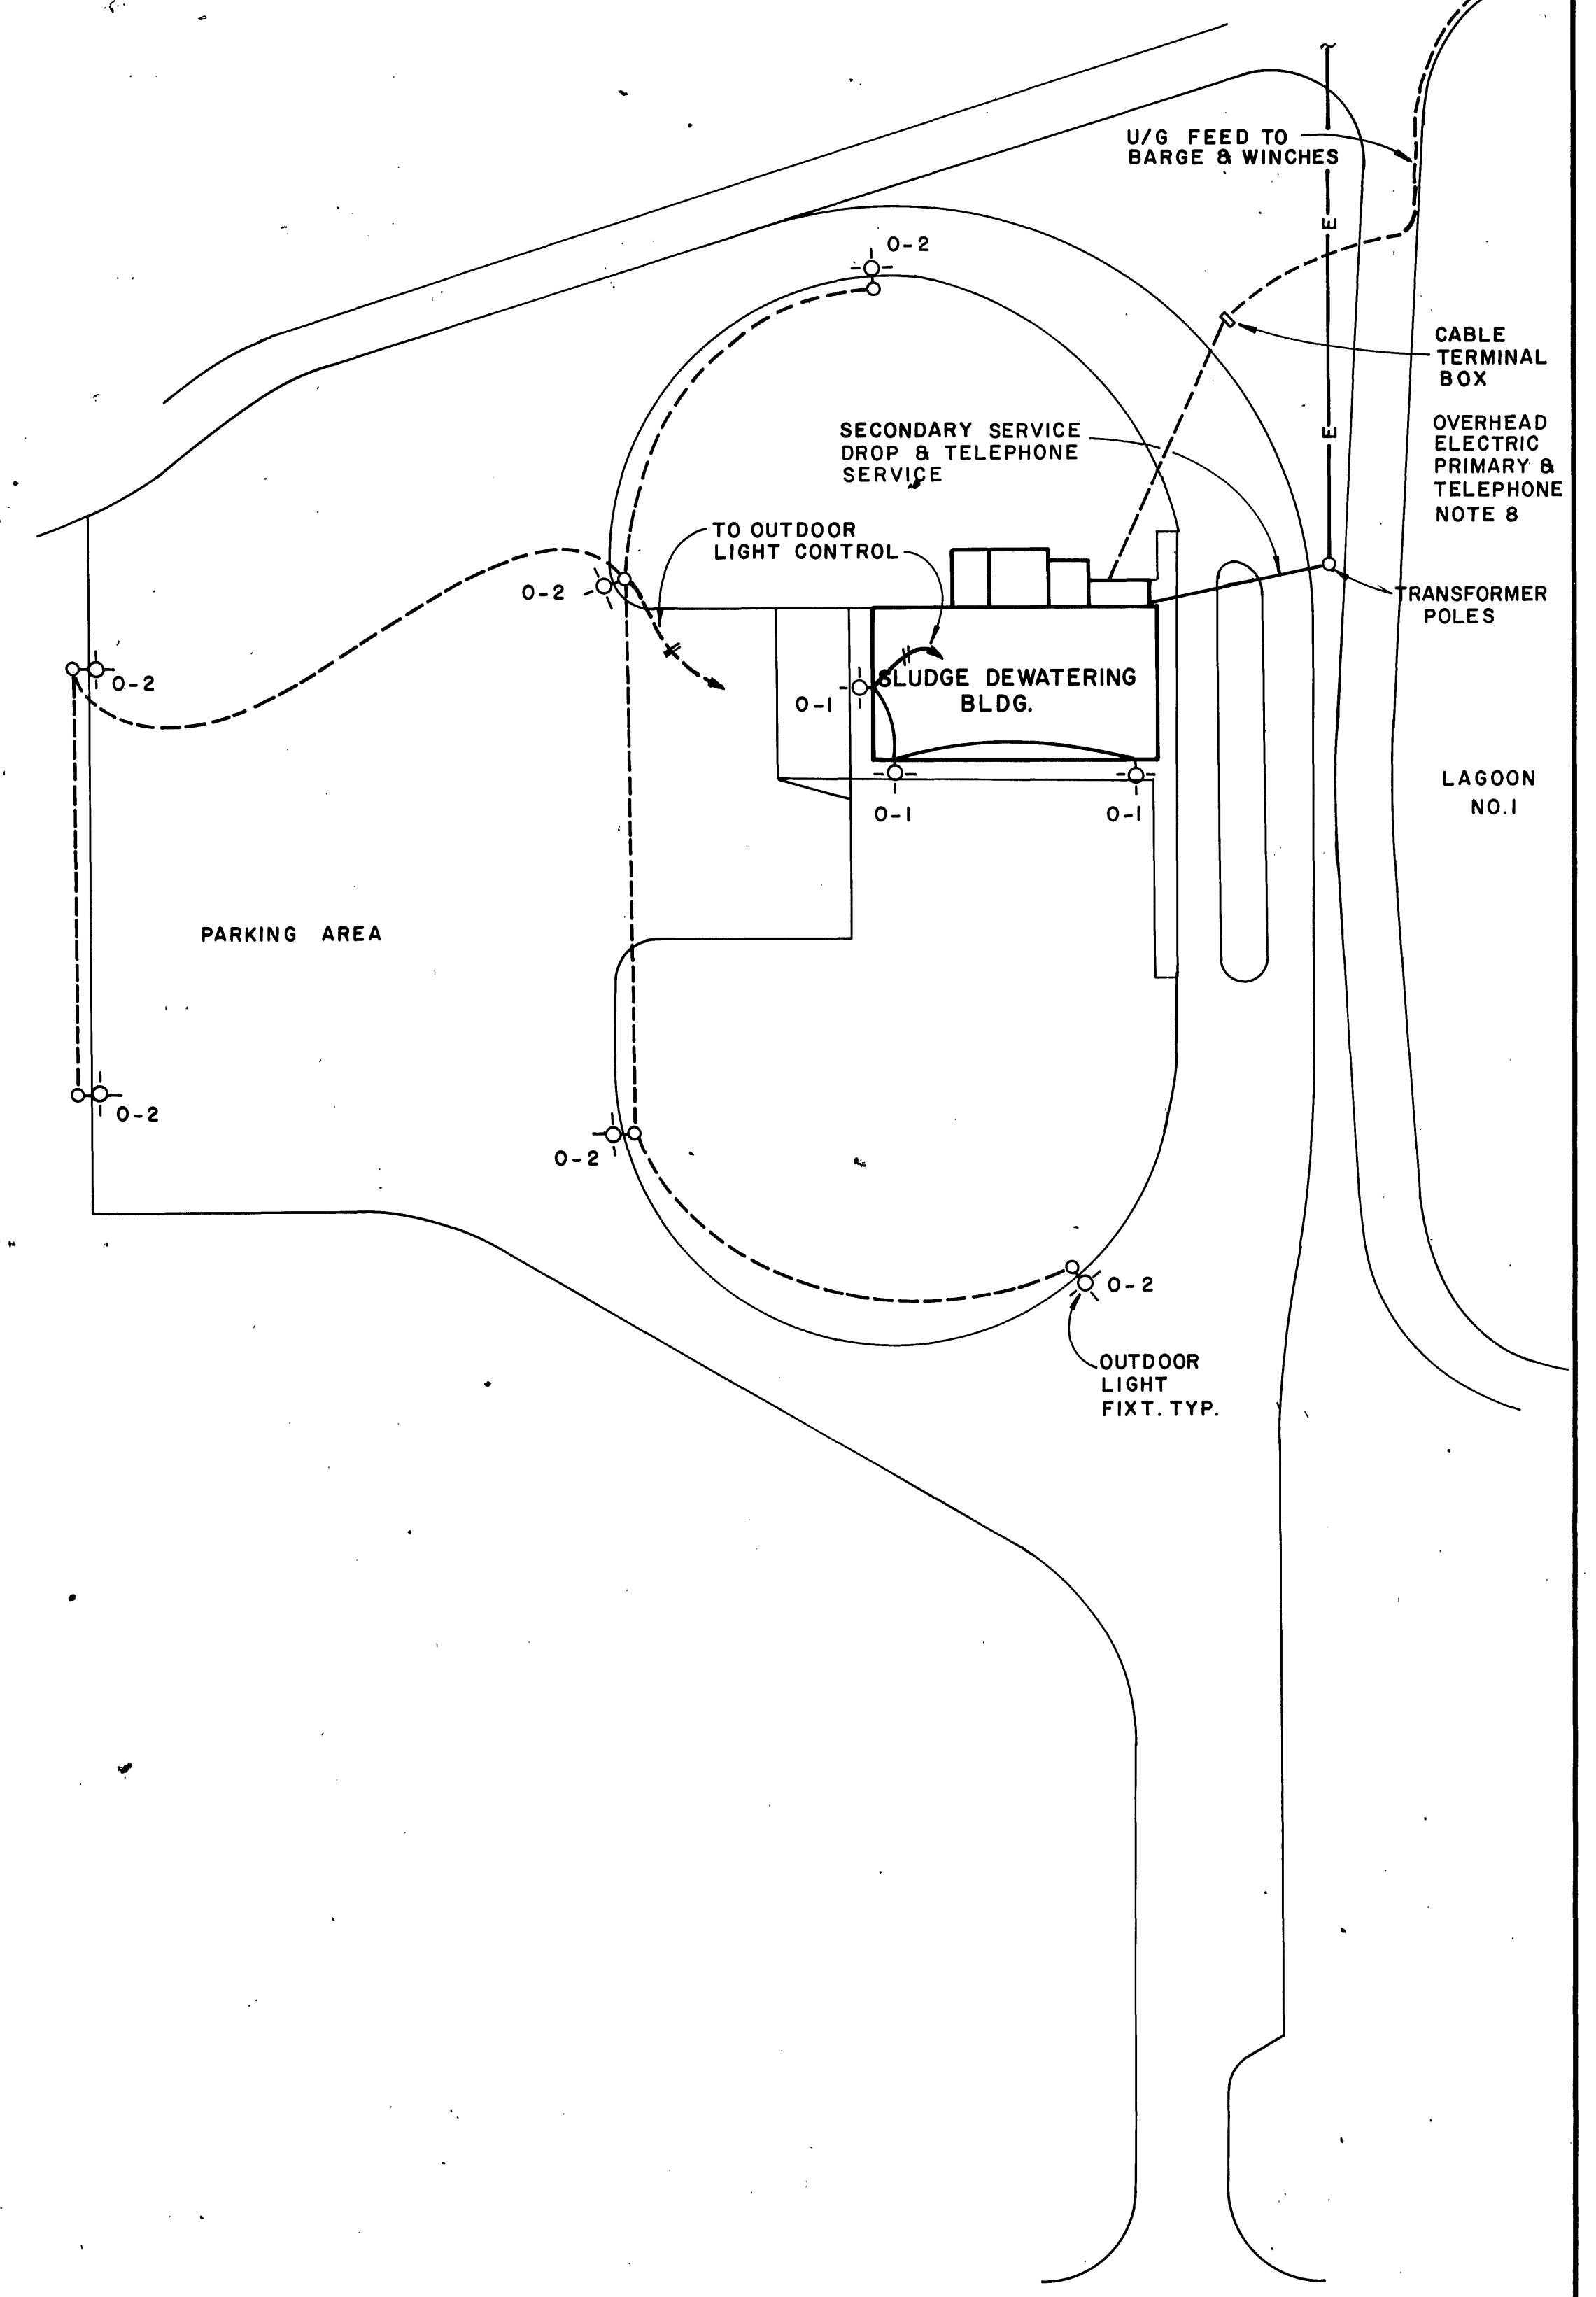


ELECTRICAL SITE PLAN
SCALE: 1" = 30'

REVISIONS			SCALE:	SHEET
NO.	DATE	DESCRIPTION		
2			AS SHOWN	27
1			DATE:	OF
			AUG. 1981	33
			DESIGNED BY:	FILE NUMBER
			DB	
			DRAFTED BY:	PP 2967
			DPC	

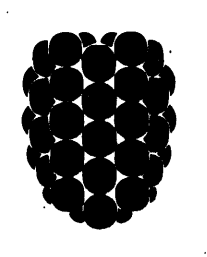

Dewberry & Davis
ENGINEERS ARCHITECTS PLANNERS SURVEYORS
8411 Arlington Boulevard Fairfax, Virginia 22031 Telephone 703-560-1100
19201 Montgomery Village Ave. Gaithersburg, Md. 20760 Tele. 301-948-4120

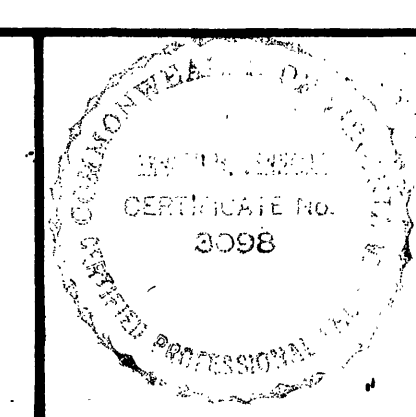

PREPARED FOR
CITY OF ROANOKE
ROANOKE, VIRGINIA

CITY OF ROANOKE WASTEWATER TREATMENT PLANT
SLUDGE DEWATERING FACILITIES

**ELECTRICAL
SITE PLAN**

BRUNING 44-142 45862