



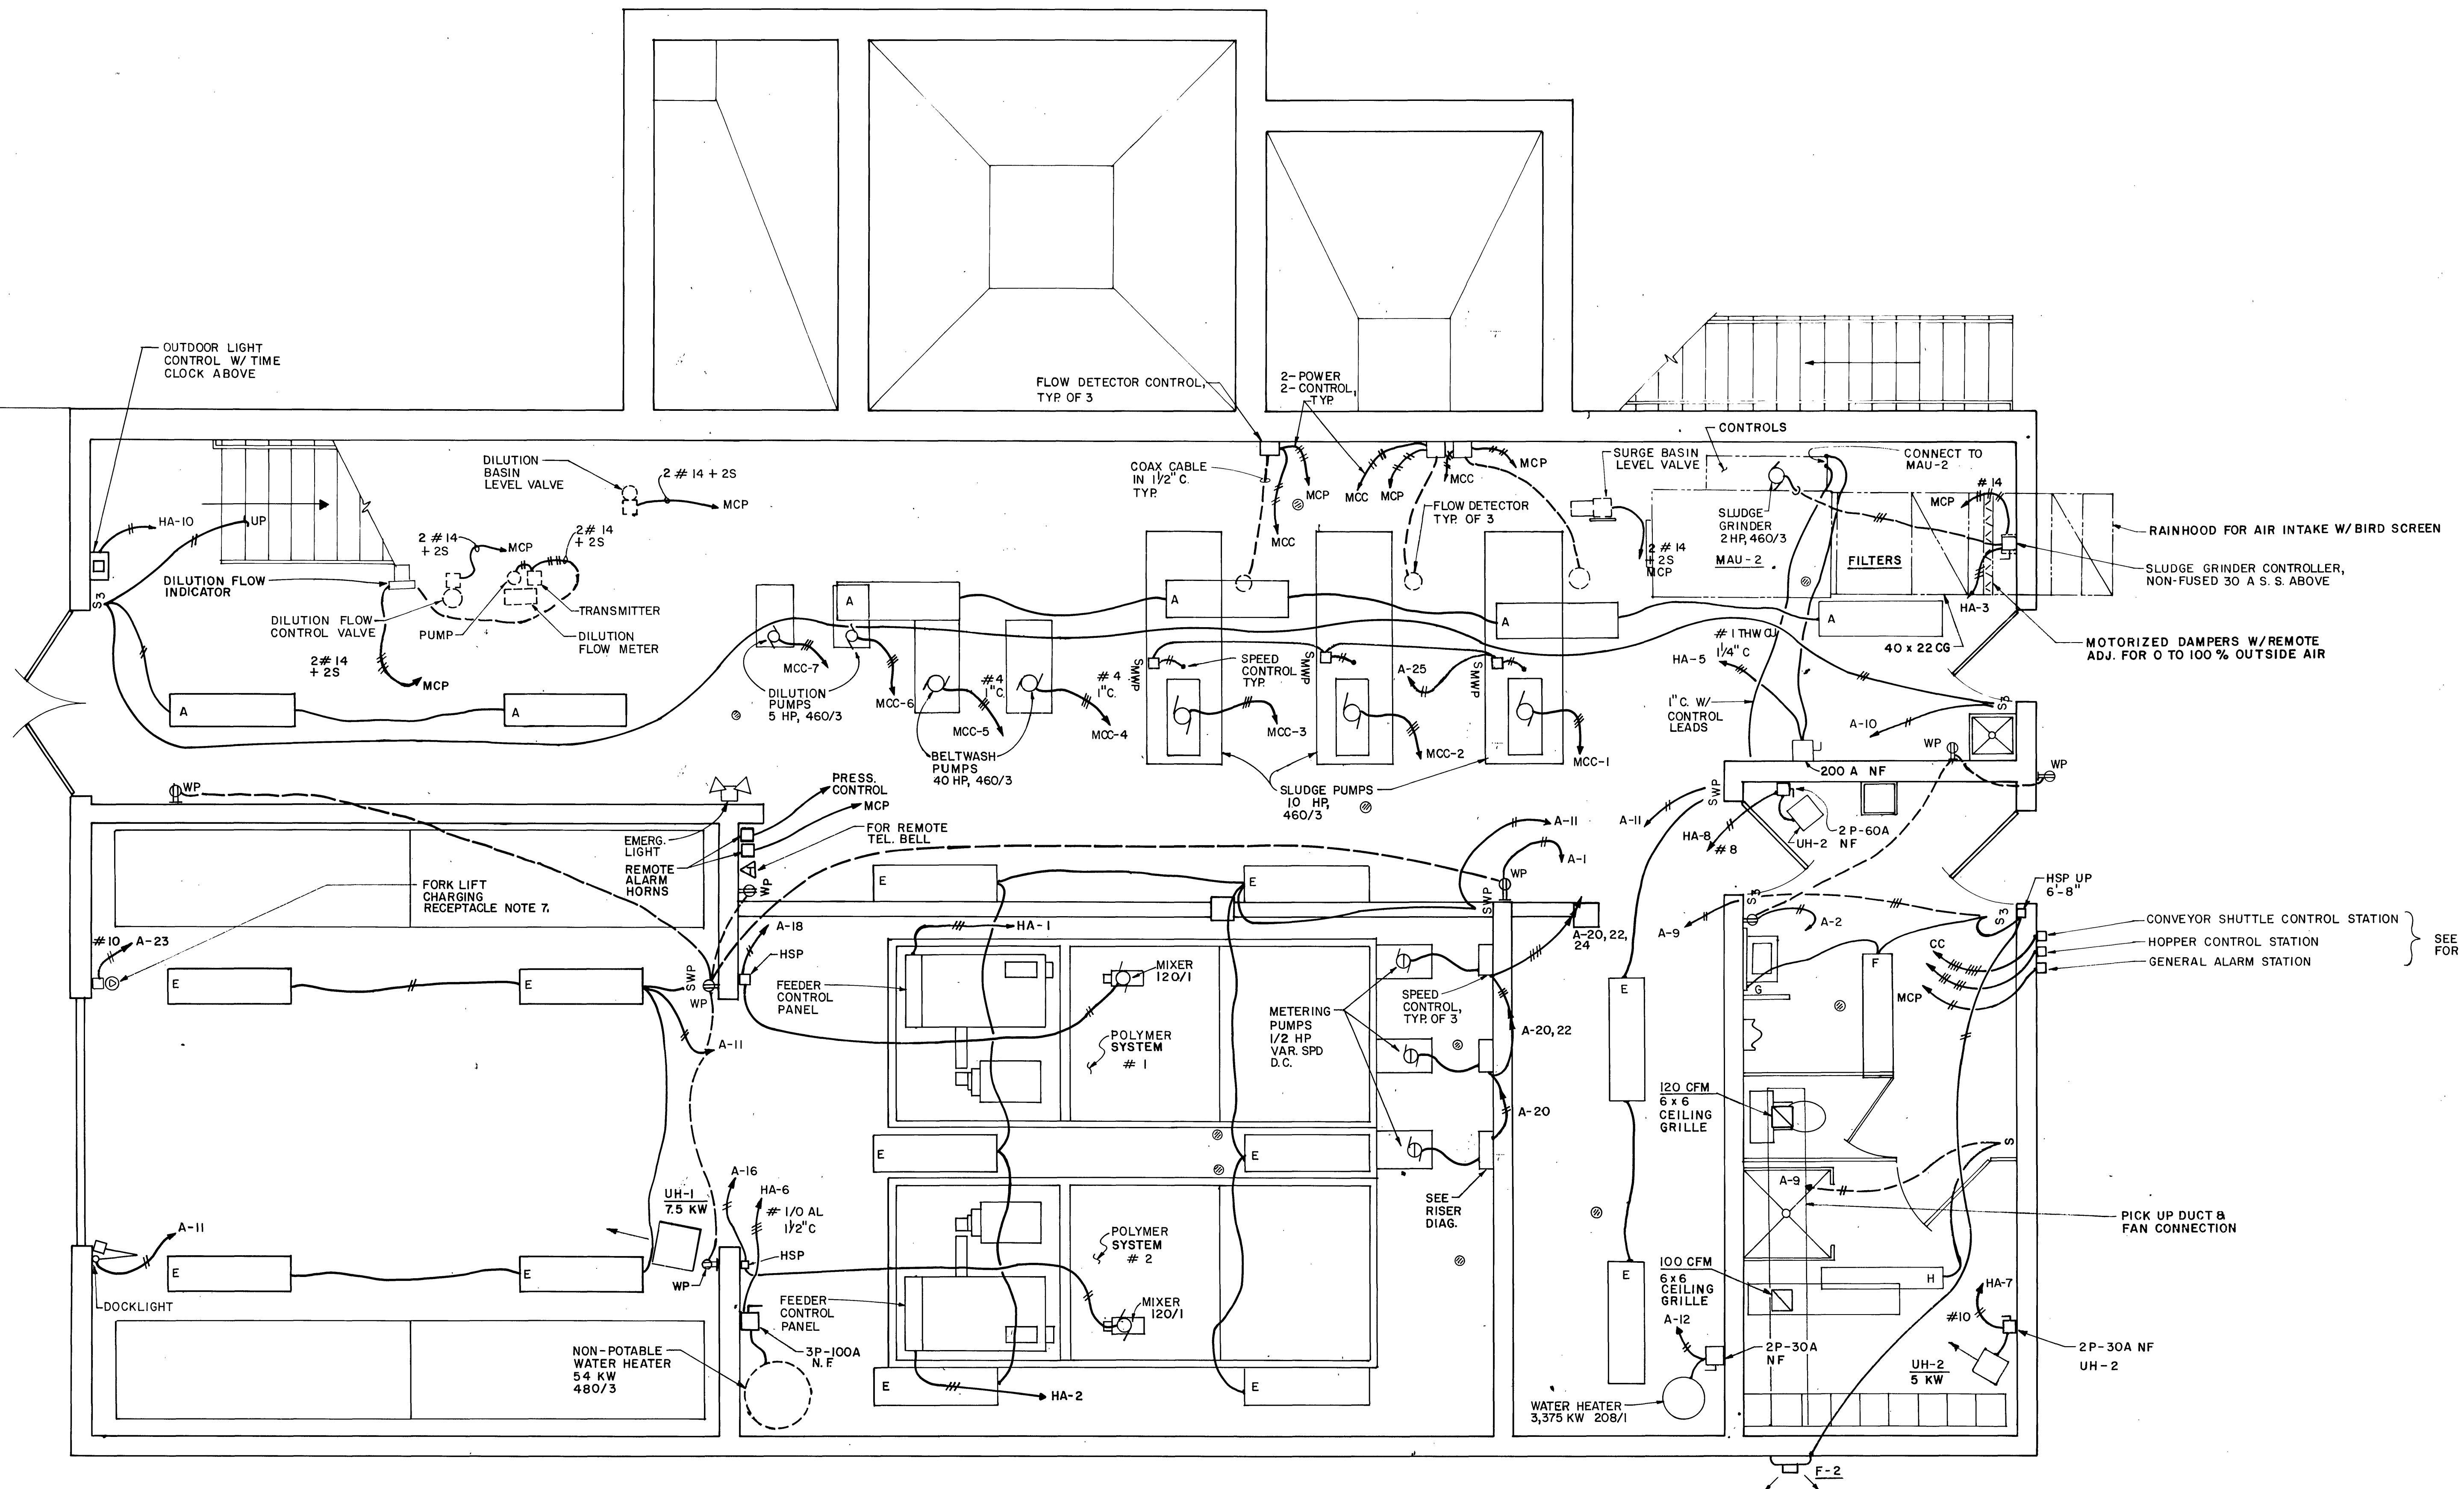

LOWER LEVEL FLOOR PLAN

| NO. | DATE | DESCRIPTION |
|-----|------|-------------|
| 2   |      |             |
| 1   |      |             |

| REVISIONS |  | SCALE:       | SHEET       |
|-----------|--|--------------|-------------|
|           |  | 3/8" = 1'-0" | 28          |
|           |  | DATE:        | OF          |
|           |  | AUG. 1981    | 33          |
|           |  | DESIGNED BY: | FILE NUMBER |
|           |  | DB           |             |
|           |  | DRAFTED BY:  | PP 2967     |
|           |  | RSR          |             |

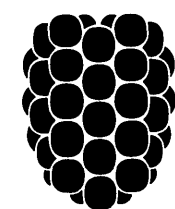

**Dewberry & Davis**  
ENGINEERS ARCHITECTS PLANNERS SURVEYORS  
8411 Arlington Boulevard Fairfax, Virginia 22031 Telephone 703-560-1100  
19201 Montgomery Village Ave. Gaithersburg, Md. 20760 Tele. 301-948-4120

PREPARED FOR  
CITY OF ROANOKE  
ROANOKE, VIRGINIA

CITY OF ROANOKE WASTEWATER TREATMENT PLANT  
SLUDGE DEWATERING FACILITIES

ELECTRICAL PLAN