


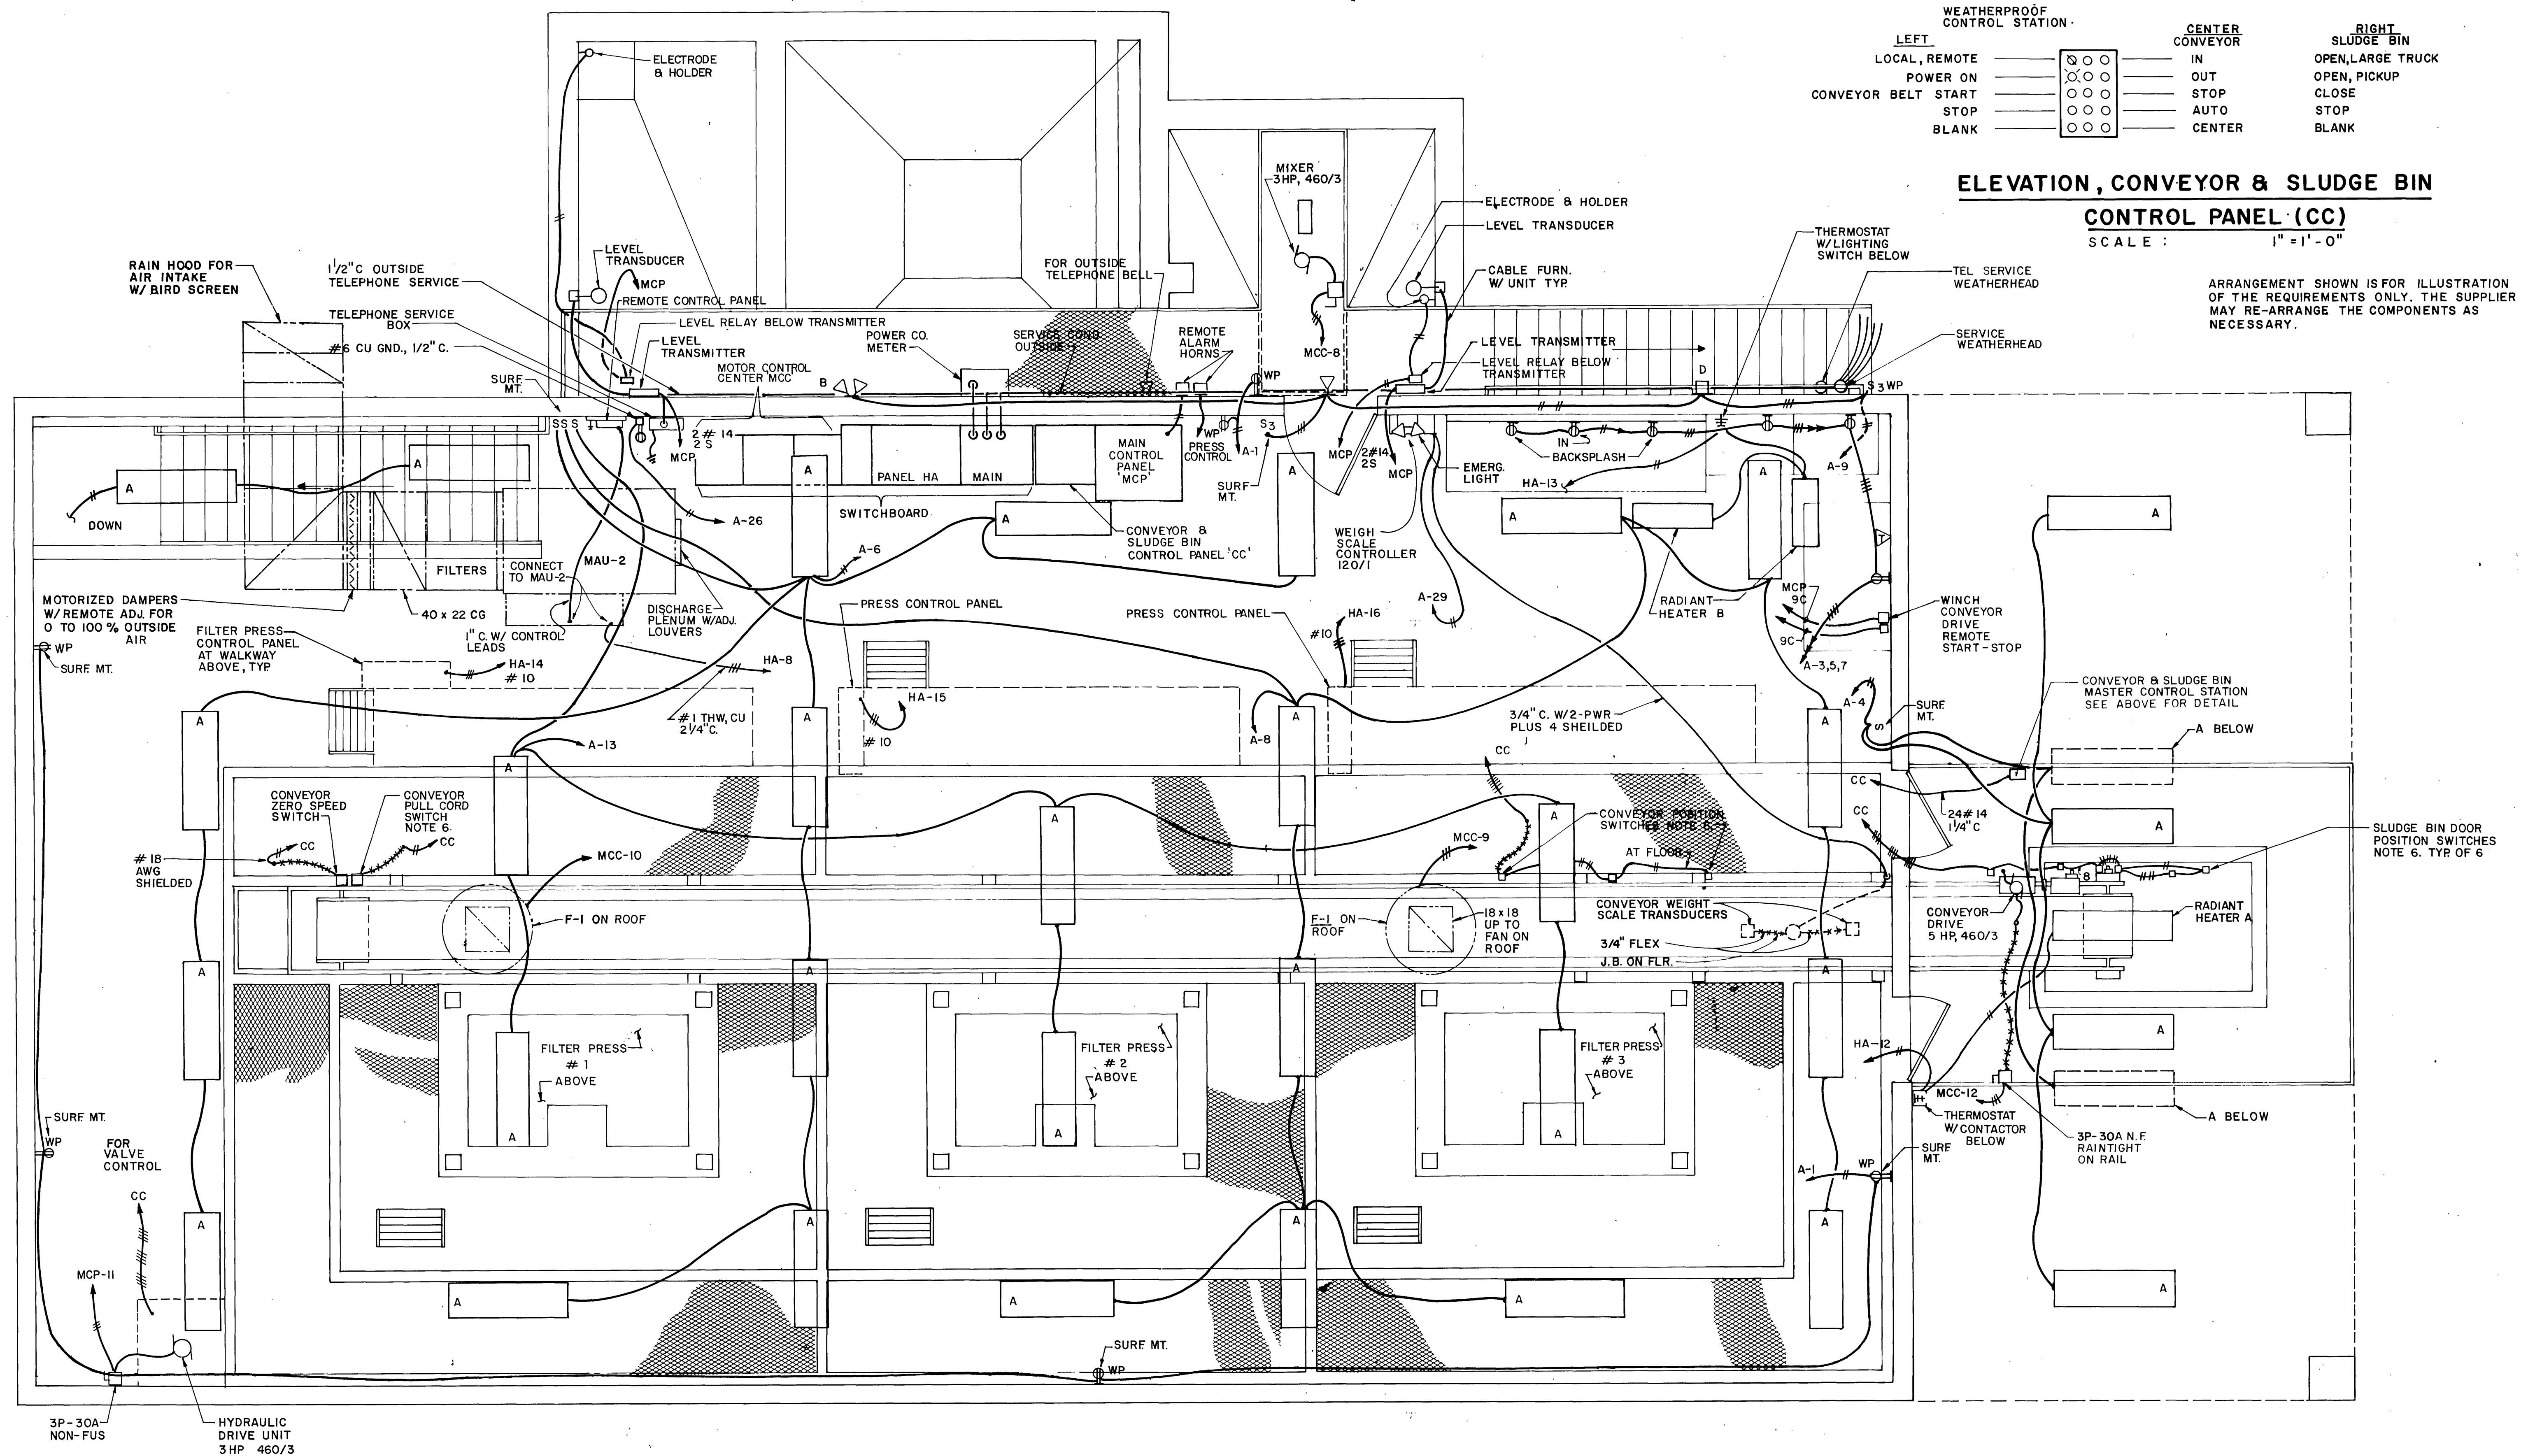

UPPER LEVEL FLOOR PLAN

**Dewberry & Davis**  
 ENGINEERS ARCHITECTS PLANNERS SURVEYORS  
 8411 Arlington Boulevard Fairfax, Virginia 22031 Telephone 703-560-1100  
 19201 Montgomery Village Ave. Gaithersburg, Md. 20760 Tele. 301-948-4120

PREPARED FOR  
 CITY OF ROANOKE  
 ROANOKE, VIRGINIA

CITY OF ROANOKE WASTEWATER TREATMENT PLANT  
 SLUDGE DEWATERING FACILITIES

**ELECTRICAL PLAN**

|              |              |             |         |
|--------------|--------------|-------------|---------|
| SCALE:       | 3/8" = 1'-0" | SHEET       | 29      |
| DATE:        | AUG. 1981    | OF          | 33      |
| DESIGNED BY: | DB           | FILE NUMBER | PP 2967 |
| DRAFTED BY:  | RSR          |             |         |

| NO. | DATE | DESCRIPTION |
|-----|------|-------------|
| 1   |      |             |
| 2   |      |             |

BRUNING 44-142 45662