




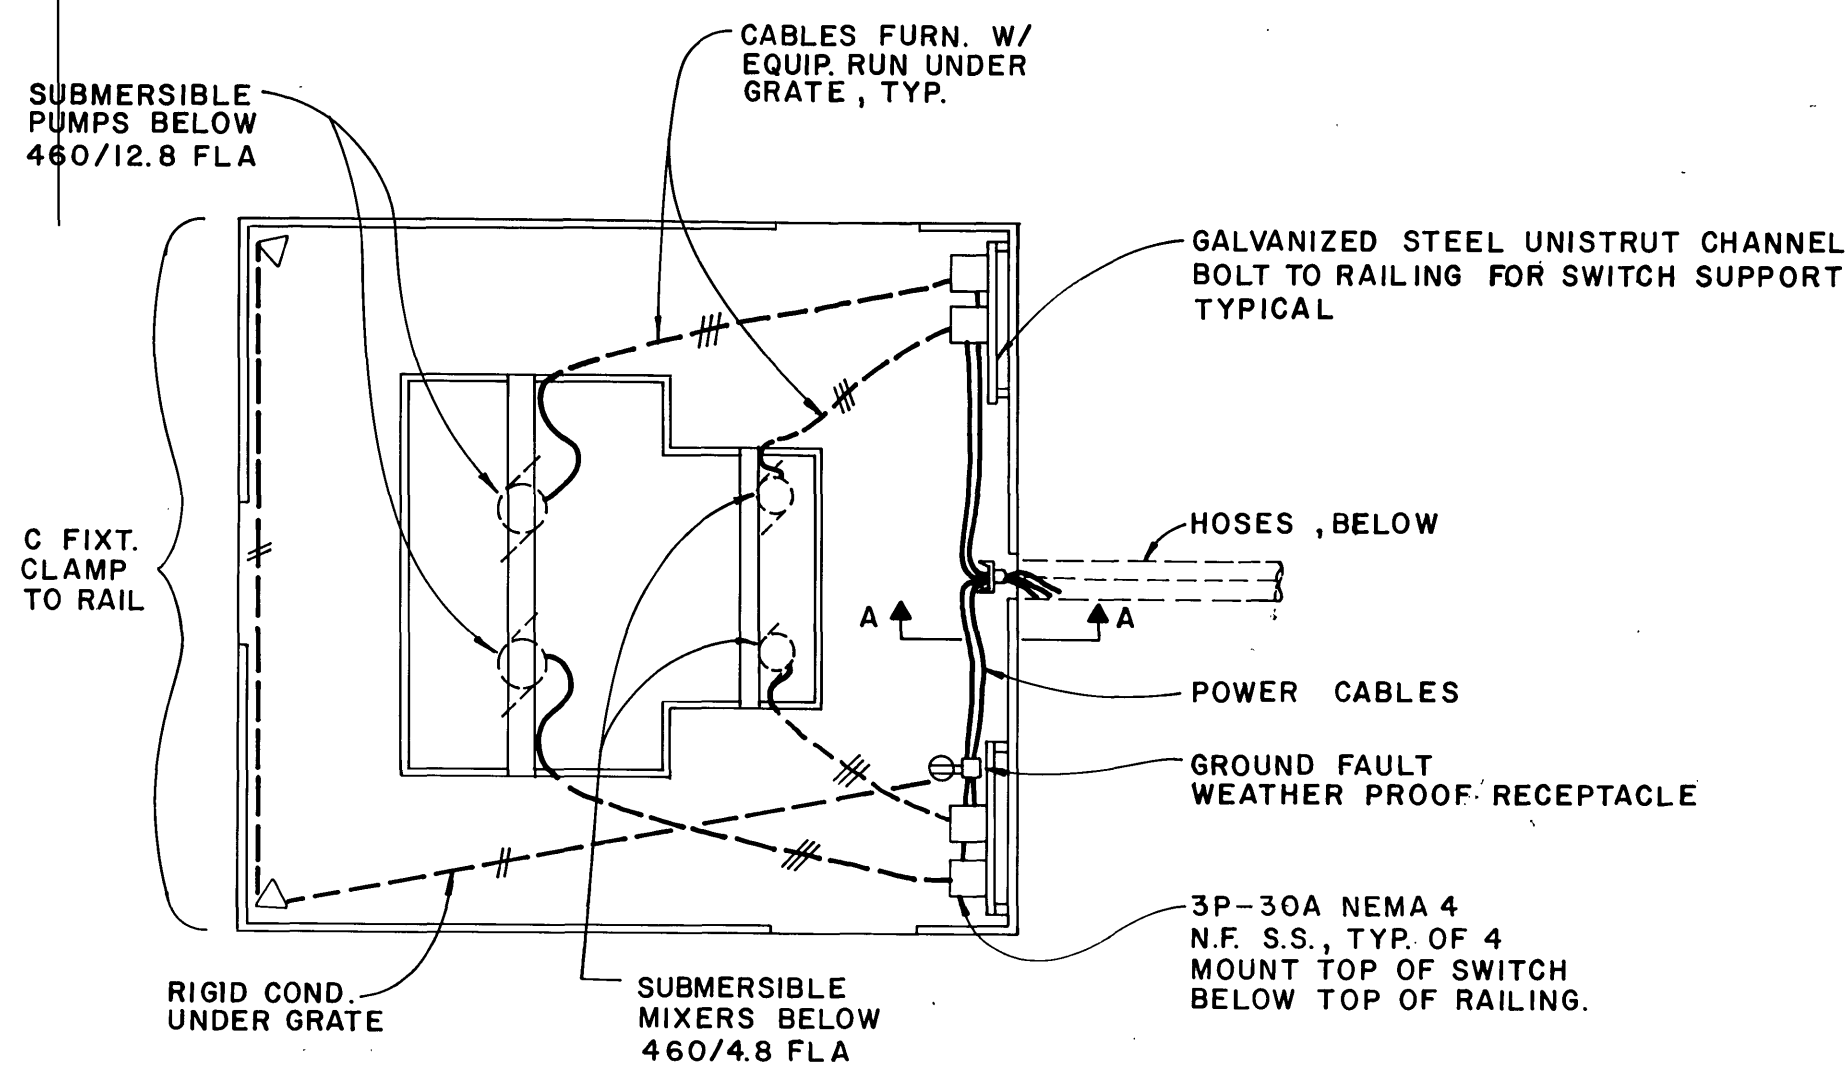

BARGE ELECTRICAL PLAN
SCALE: 3/4" = 1'-0"

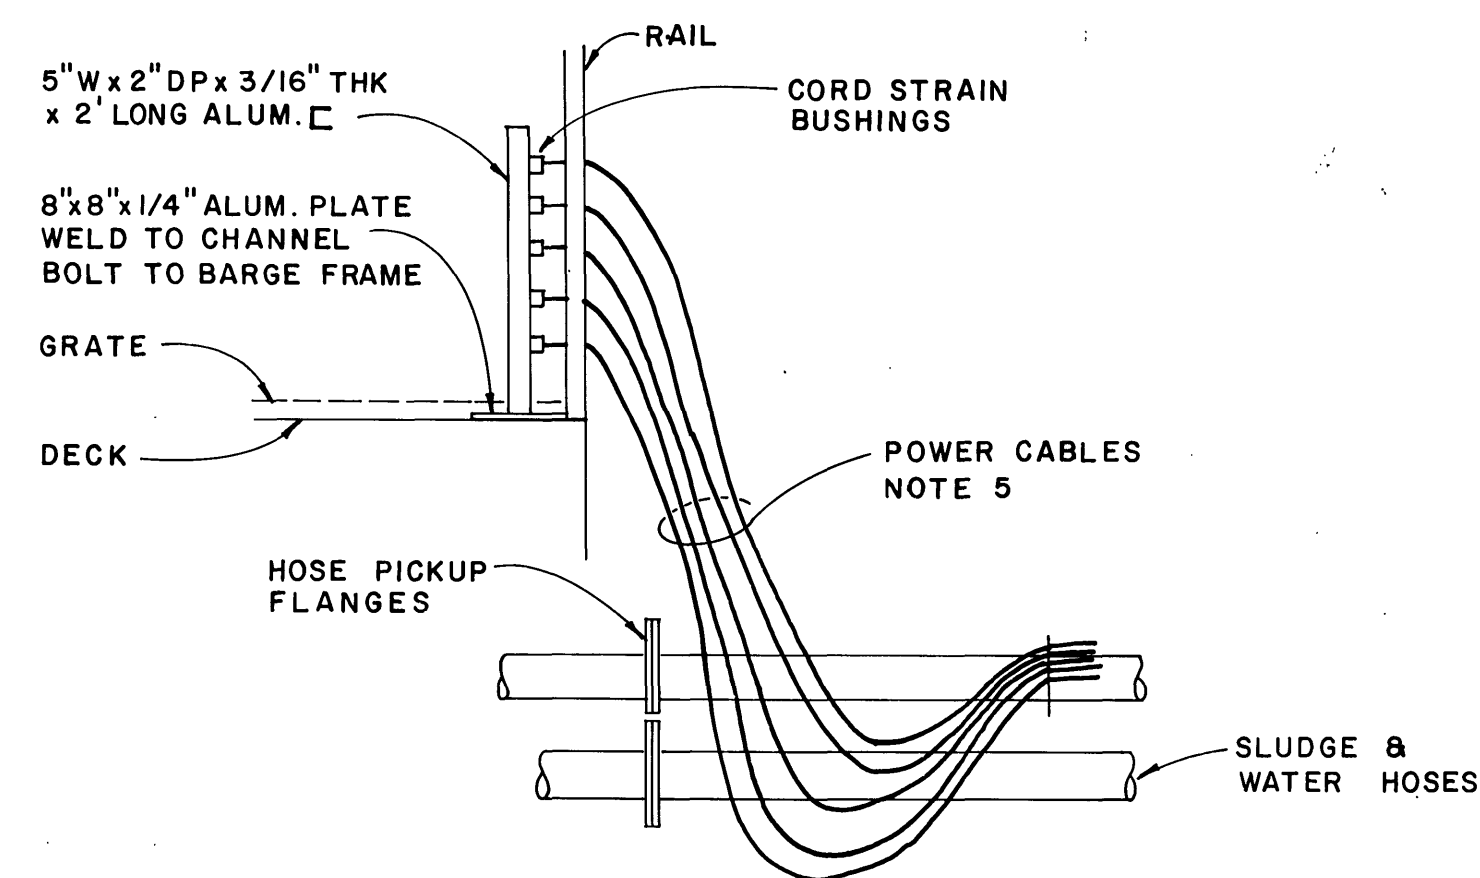


VIEW A-A
N.T.S.

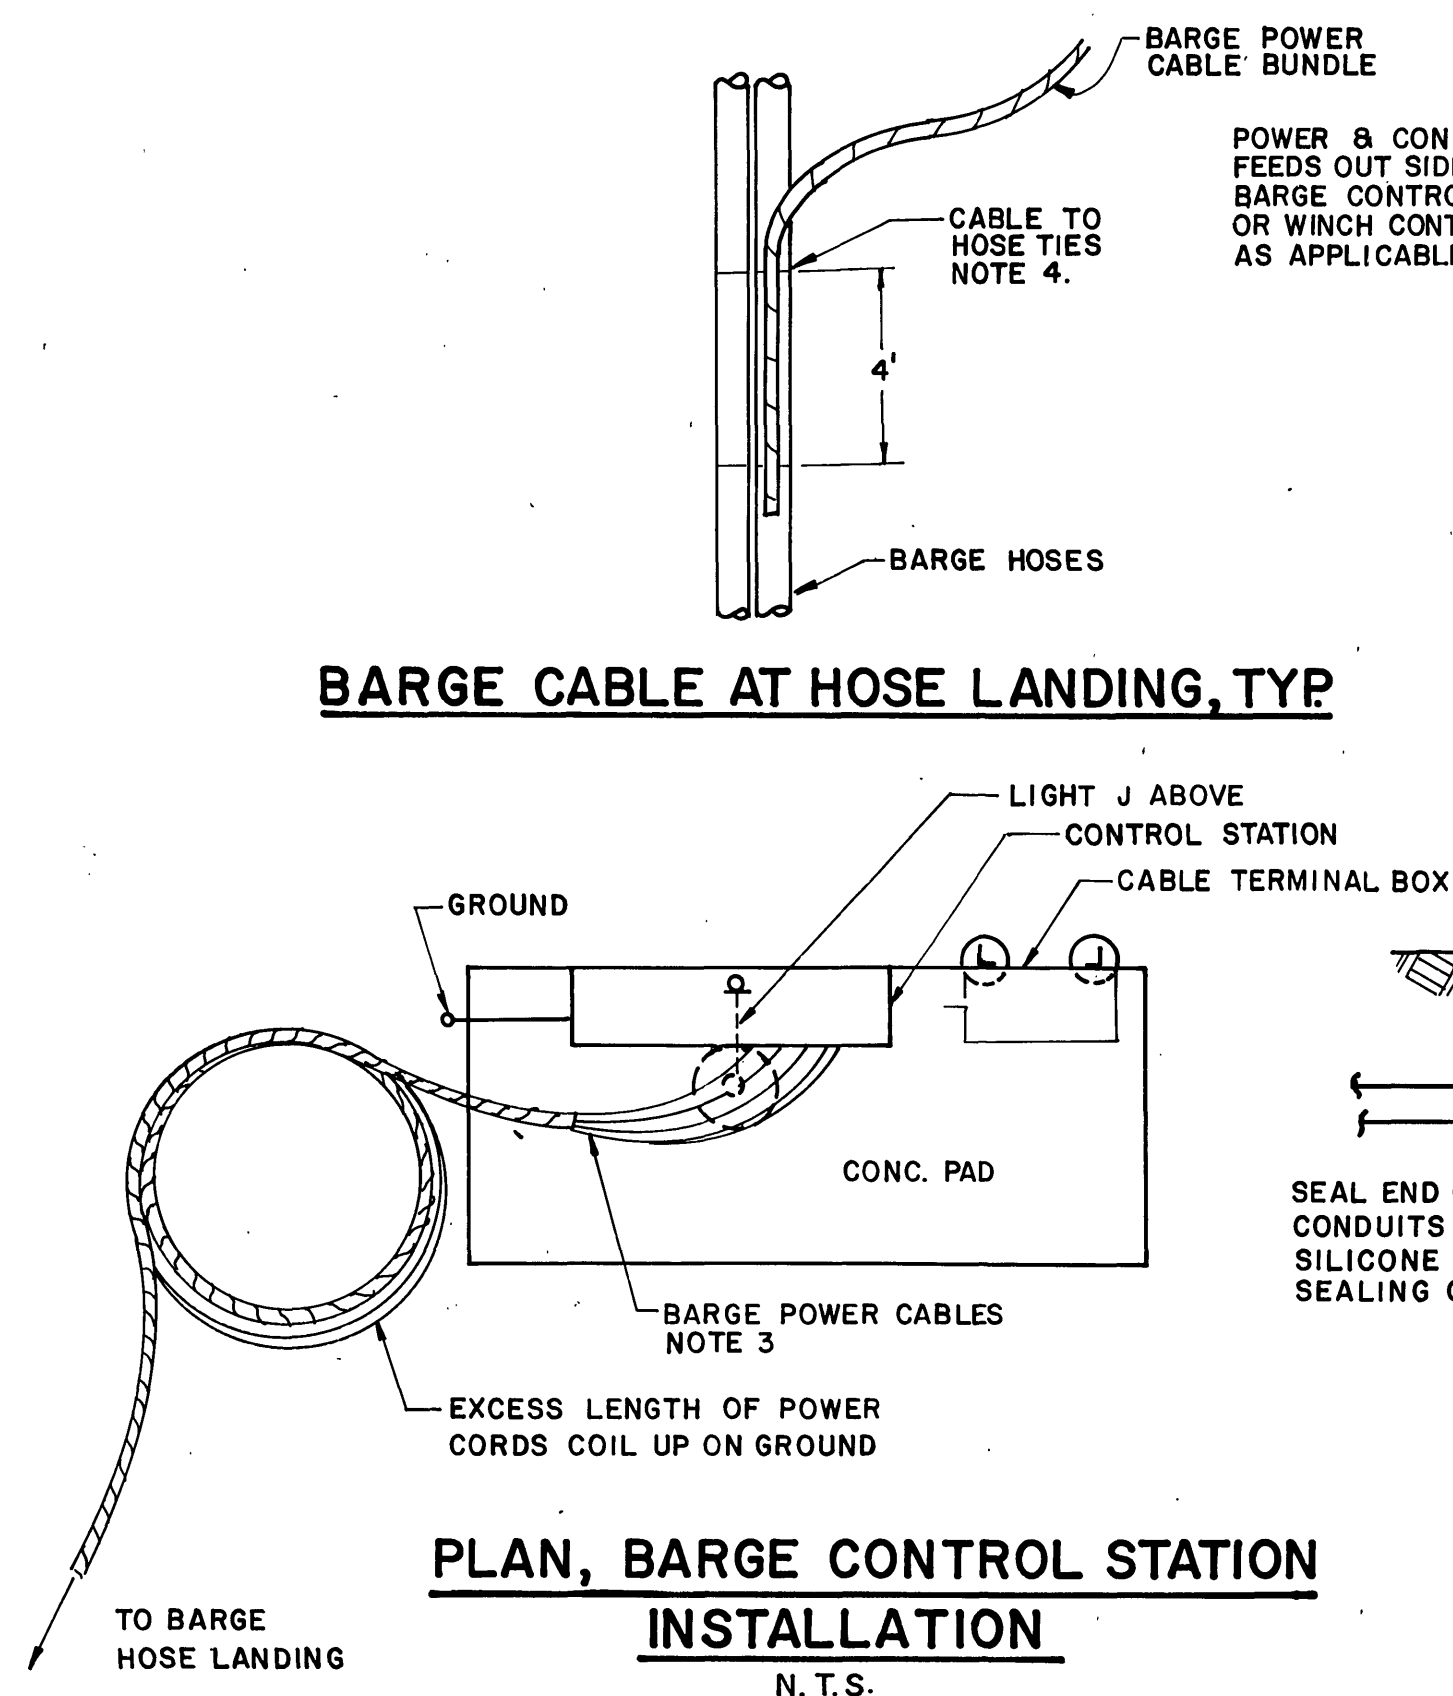


BARGE CABLE AT HOSE LANDING, TYP.


PLAN, BARGE CONTROL STATION INSTALLATION
N.T.S.

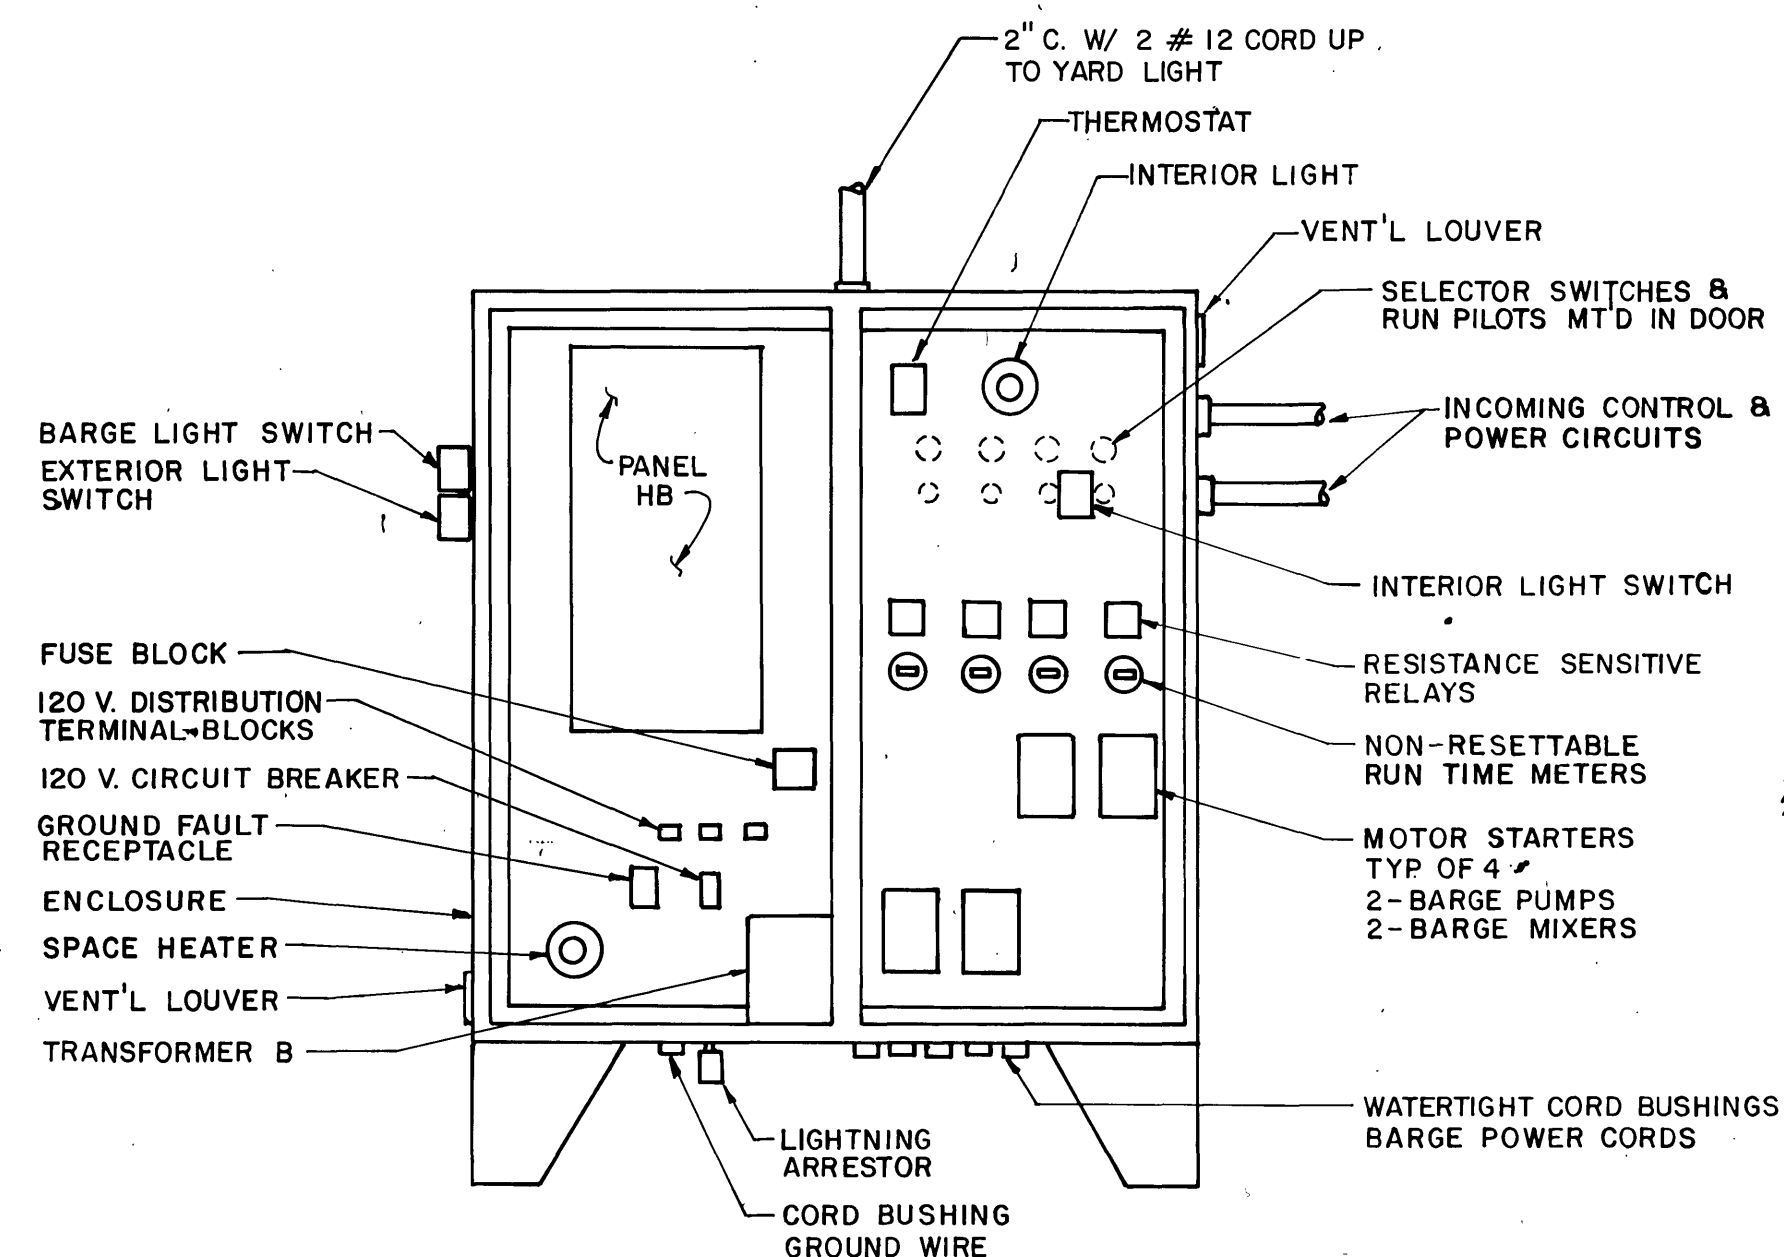

ELEVATION
BARGE CONTROL STATION SHOWING COMPONENTS
SEE SCHEDULE FOR DESCRIPTION
N.T.S.

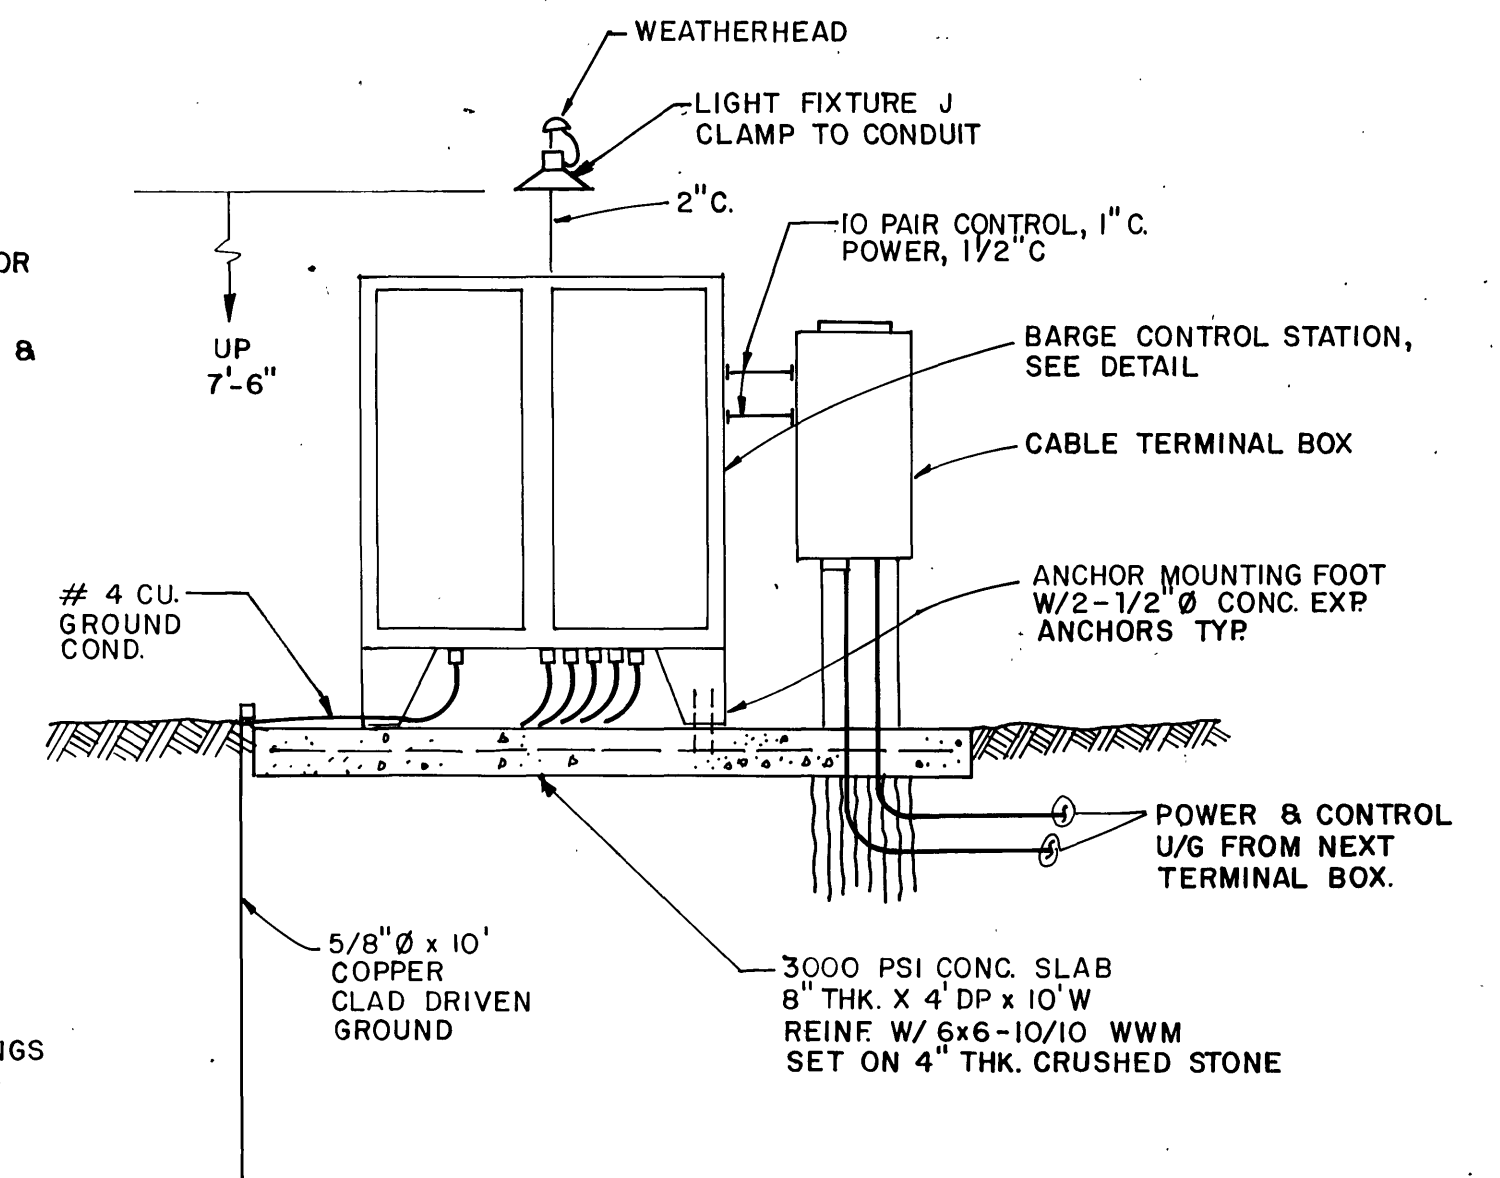


ELEVATION
BARGE CONTROL STATION INSTALLATION
N.T.S.

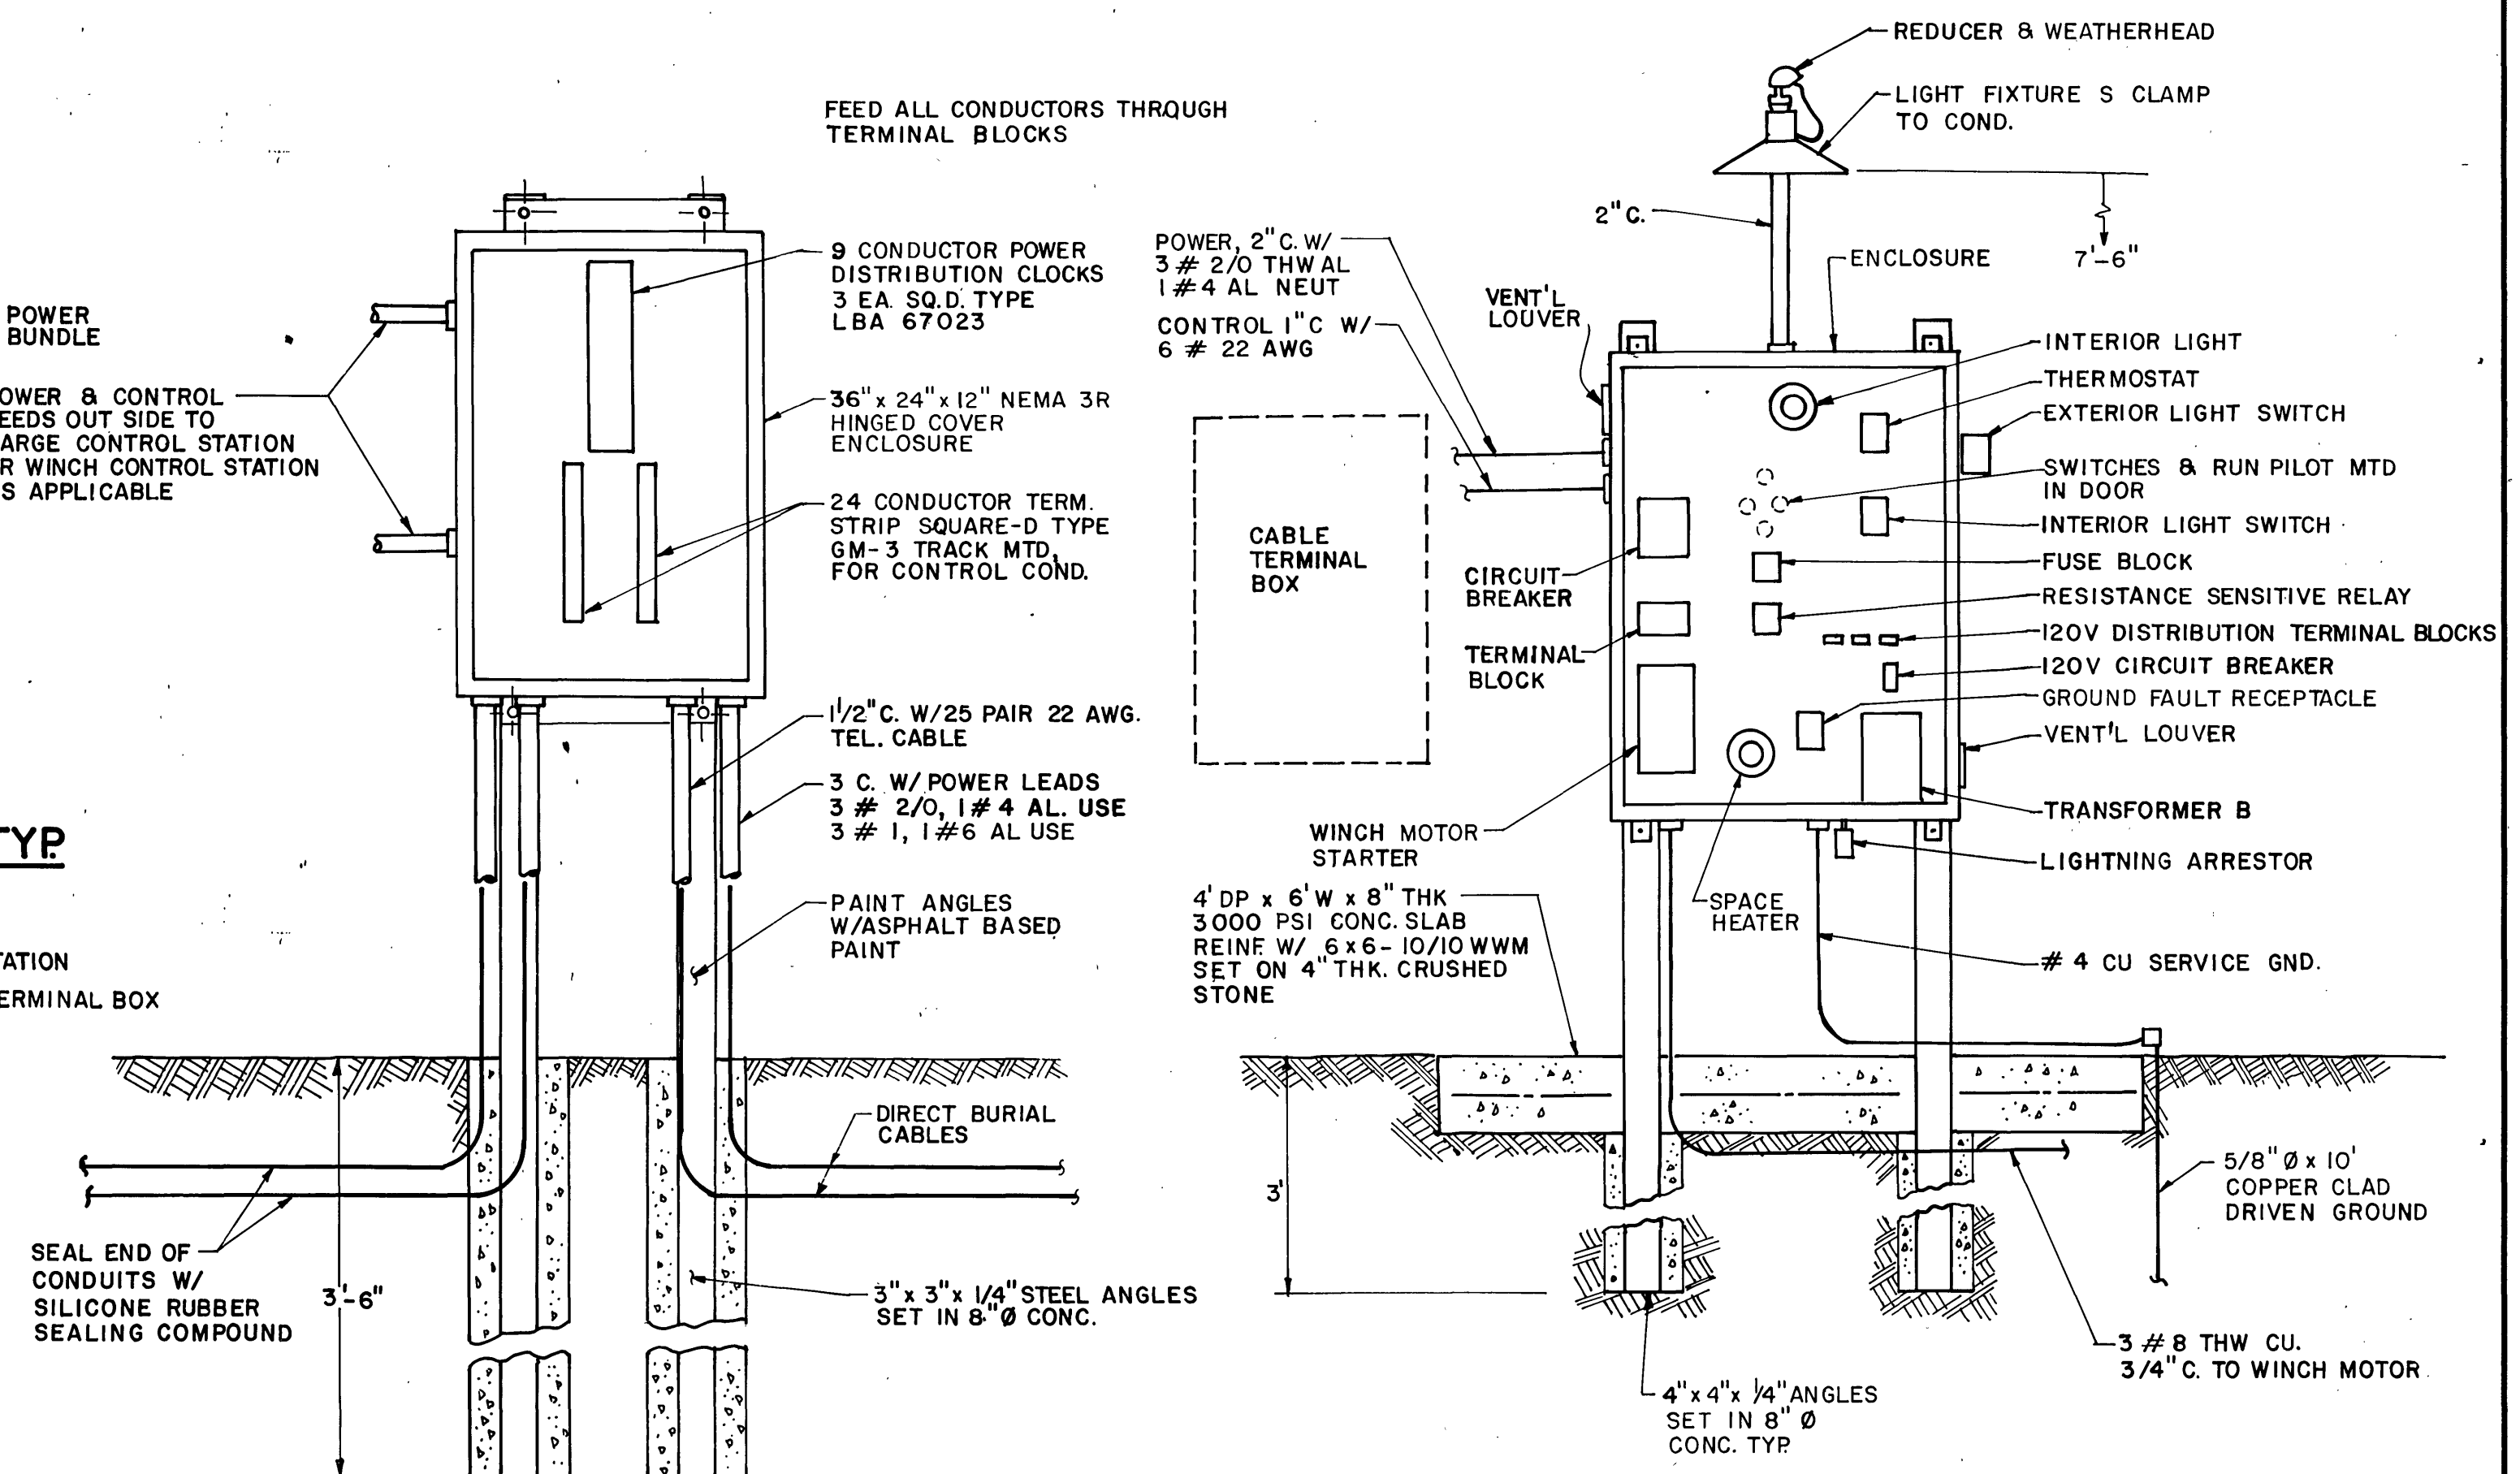

ELEVATION, UNDERGROUND CABLE TERMINAL BOX, TYP.
SCALE: 1" = 1'-0"

ELEVATION, WINCH CONTROL STATION
SCALE: 3/4" = 1'-0"

NO.	DATE	DESCRIPTION
2		
1		
REVISIONS		

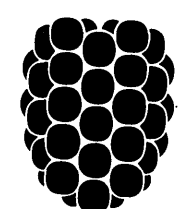

Dewberry & Davis
ENGINEERS ARCHITECTS PLANNERS SURVEYORS
8411 Arlington Boulevard Fairfax, Virginia 22031 Telephone 703-560-1100
19201 Montgomery Village Ave. Gaithersburg, Md. 20760 Tele. 301-948-4120

PREPARED FOR
CITY OF ROANOKE
ROANOKE, VIRGINIA

CITY OF ROANOKE WASTEWATER TREATMENT PLANT
SLUDGE DEWATERING FACILITIES

**BARGE & WINCH
ELECTRICAL DETAILS**

SCALE: AS SHOWN
DATE: AUG. 1981
DESIGNED BY: DB
DRAFTED BY: RSR
SHEET 33 OF 33
FILE NUMBER PP 2967